



CITY OF ROCHESTER
CONTRACT DRAWINGS FOR
ROUTE 202A WATER MAIN EXTENSION &
WATER STORAGE TANK
ROCHESTER, NH
NOVEMBER 2021
CONFORMED REFERENCE DRAWINGS

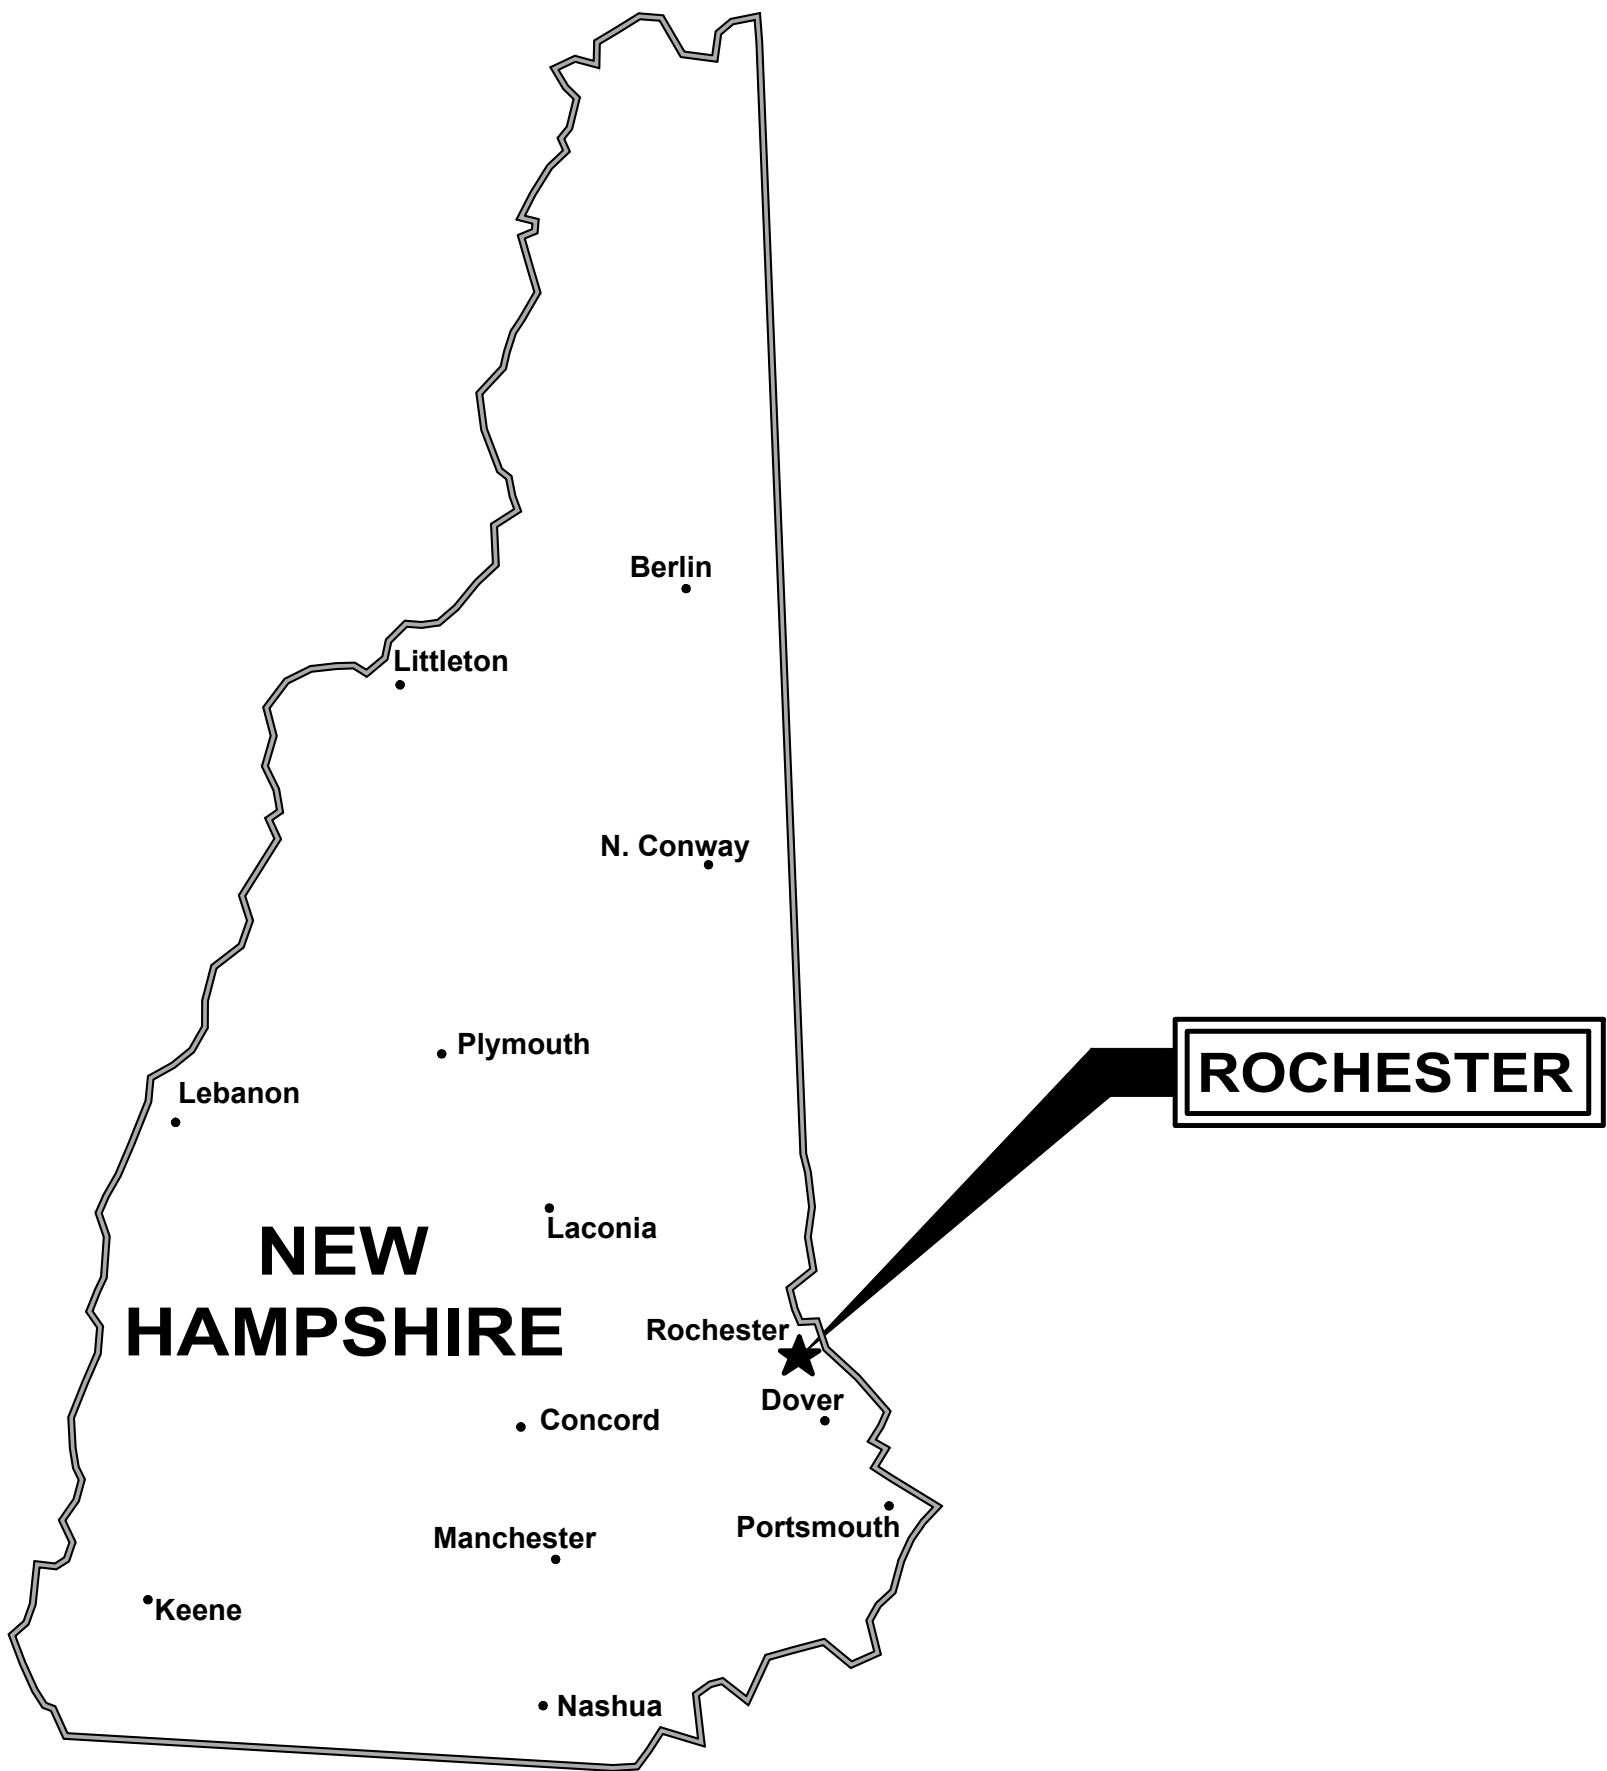

DRAWING INDEX	
GENERAL	
-----	COVER SHEET
CIVIL-WATER MAIN	
C-1	GENERAL NOTES, ABBREVIATIONS AND LEGEND
C-2	SHEET INDEX
C-3	PLAN & PROFILE I - STRAFFORD RD (RTE 202A) -CROWN POINT RD STA 100+00 TO 112+00
C-4	PLAN & PROFILE II - CROWN POINT RD (RTE 202A) STA 112+00 TO 124+00
C-5	PLAN & PROFILE III - CROWN POINT RD (RTE 202A) STA 124+00 TO 136+00
C-6	PLAN & PROFILE IV - CROWN POINT RD (RTE 202A) STA 136+00 TO 148+00
C-7	PLAN & PROFILE V - WALNUT ST (RTE 202A) STA 148+00 TO 160+00
C-8	PLAN & PROFILE VI - WALNUT ST (RTE 202A) STA 160+00 TO 172+00
C-9	PLAN & PROFILE VII - WALNUT ST (RTE 202A) STA 172+00 TO 184+00
C-10	PLAN & PROFILE VIII - WALNUT ST (RTE 202A) STA 184+00 TO 196+00
C-11	PLAN & PROFILE IX - WALNUT ST (RTE 202A)-BICKFORD RD STA 196+00 TO 205+00
C-12	PLAN & PROFILE X - BICKFORD RD STA 205+00 TO 216+00
C-13	PLAN & PROFILE XI - BICKFORD RD STA 216+00 TO STA 228+00
C-14	PLAN & PROFILE XII - BICKFORD RD - HIGHFIELDS STA 228+00 TO 236+40
C-15	PLAN & PROFILE XIII - FIDDLEHEAD LN - BID ALTERNATE A STA 400+00 TO STA 409+00
C-16	PLAN & PROFILE XVI - FIDDLEHEAD LN - BID ALTERNATE A STA 409+00 TO 415+00
C-17	PLAN & PROFILE XV - WINKLEY FARM LN STA 300+00 TO 312+00
C-18	PLAN & PROFILE XVI - WINKLEY FARM LN STA 312+00 TO 324+00
C-19	PLAN & PROFILE XVII - WINKLEY FARM LN STA 324+00 TO 333+00
C-20	PLAN & PROFILE XVIII - WINKLEY FARM LN STA 333+00 TO 345+00
C-21	PLAN & PROFILE XIX - WINKLEY FARM LN STA 345+00 TO 352+37
C-22	BRIDGE CROSSING DETAIL SHEET
C-23	EROSION CONTROL NOTES & DETAILS
C-24	DETAILS I
C-25	DETAILS II
C-26	DETAILS III
C-27	DETAILS IV
STRUCTURAL-WATER MAIN	
S-1	WATER MAIN BRIDGE CROSSING - PIPE SUPPORT PLAN AND DETAILS
CIVIL-WATER STORAGE TANK	
C-28	GENERAL NOTES, ABBREVIATIONS AND LEGEND
C-29	EXISTING CONDITIONS PLAN
C-30	STORAGE TANK SITE PLAN
C-31	STORAGE TANK DETAILS I
STRUCTURAL-WATER STORAGE TANK	
S-2	STORAGE TANK STRUCTURAL DETAILS I
S-3	STORAGE TANK STRUCTURAL DETAILS II
S-4	STORAGE TANK STRUCTURAL DETAILS III
S-5	STORAGE TANK STRUCTURAL DETAILS IV
ELECTRICAL-WATER STORAGE TANK	
E-1	ELECTRICAL NOTES, LEGEND, ABBREVIATIONS, NEMA AND CONDUIT INSTALLATION SCHEDULE
E-2	ELECTRICAL SITE PLAN
E-3	SINGLE LINE DIAGRAM
E-4	ELECTRICAL DETAILS I
E-5	ELECTRICAL DETAILS II

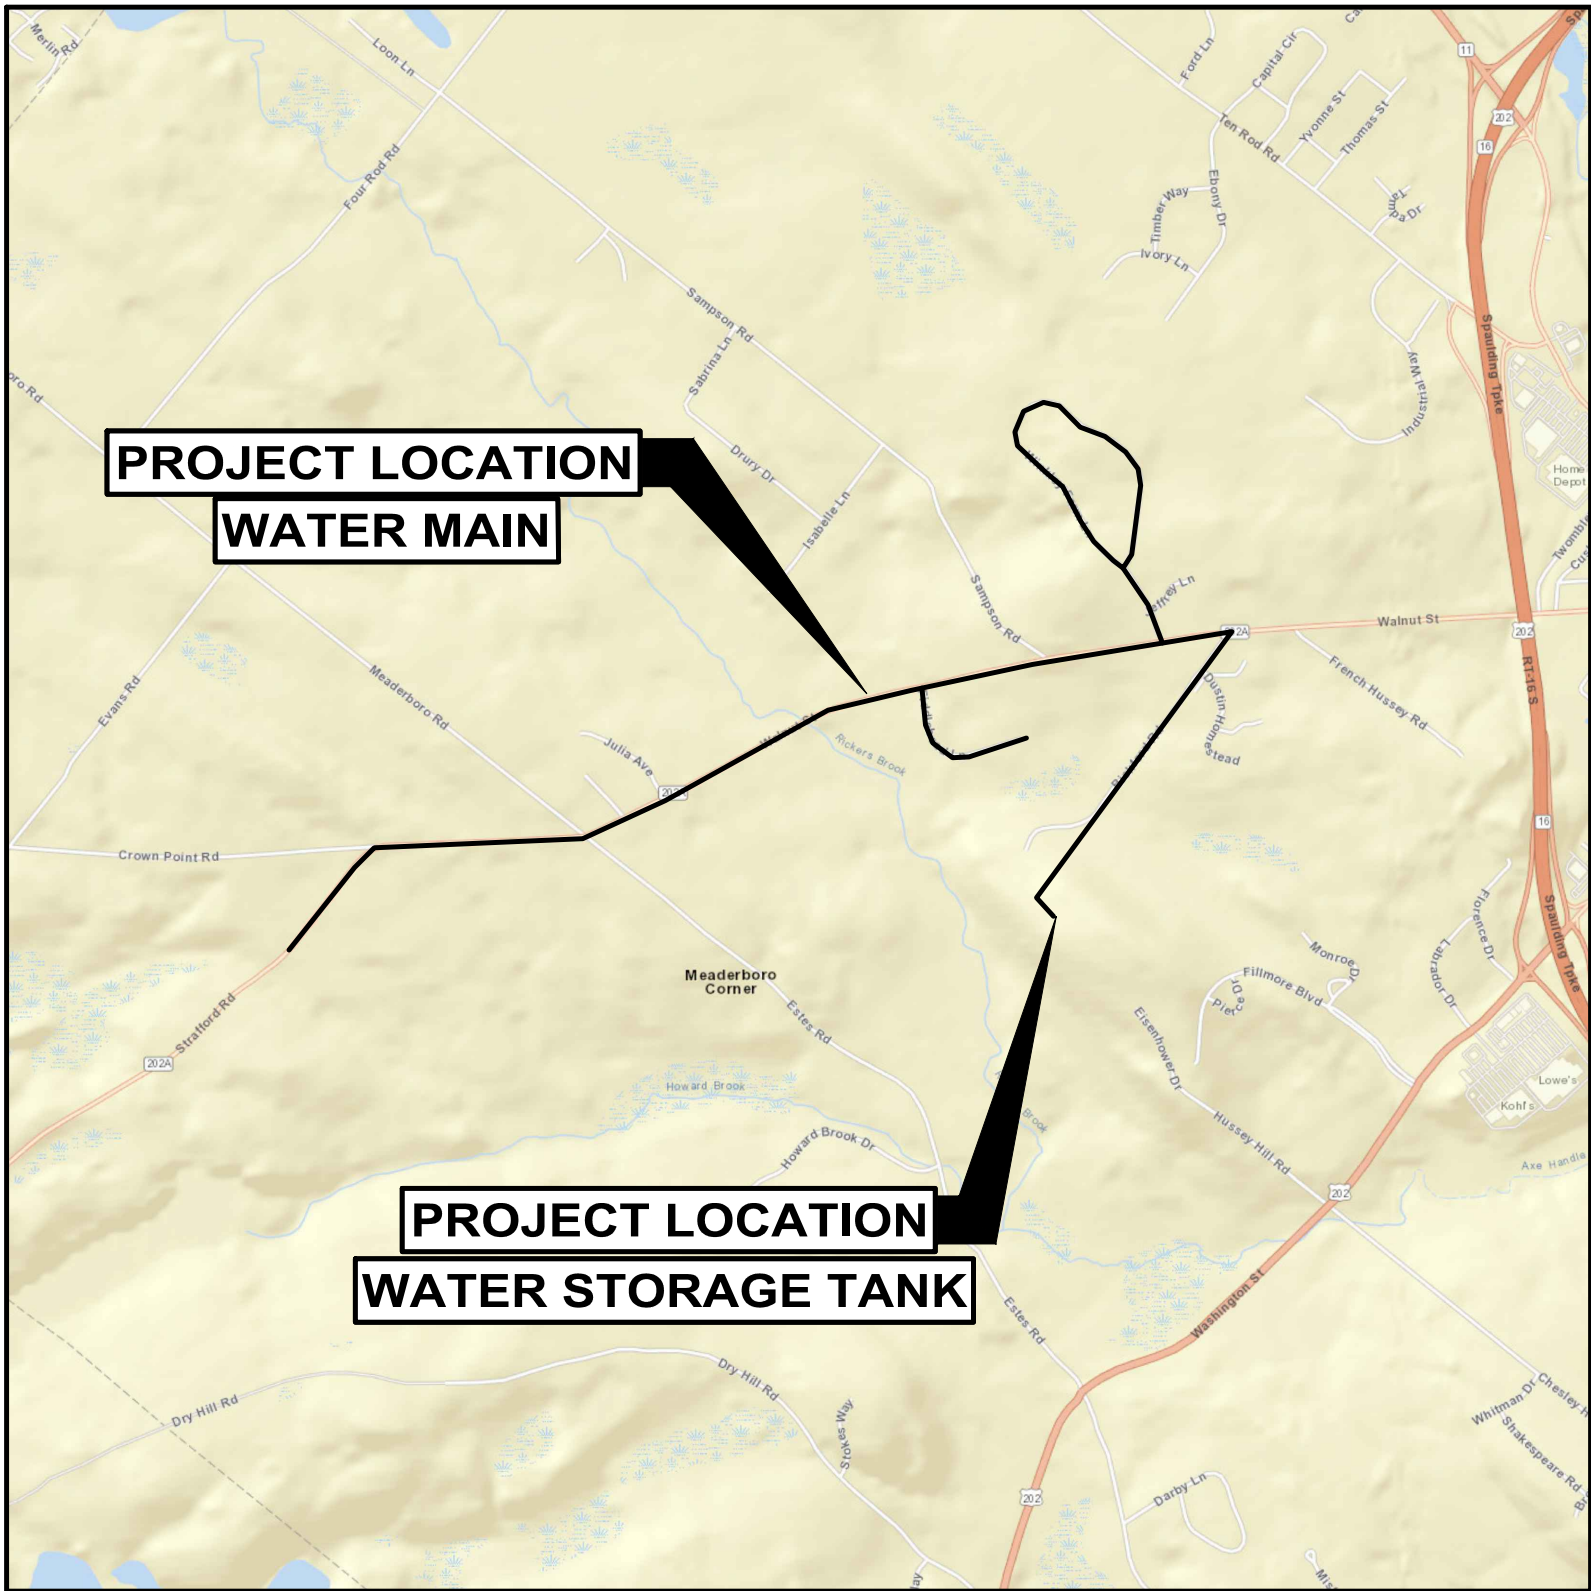

LOCATION PLAN


CONFORMED REFERENCE DRAWINGS NOVEMBER 2021: THE CONFORMED REFERENCE DOCUMENTS HAVE BEEN REVISED TO INCORPORATE CLARIFICATIONS AND/OR DRAWING AND SPECIFICATION CHANGES FROM THE PROJECT ADDENDA IN ORDER TO CLEARLY AND ACCURATELY DEPICT THESE CLARIFICATIONS/CHANGES FOR CONVENIENCE AND REFERENCE. THE EXECUTED CONTRACT DOCUMENTS, INCLUDING THE ISSUED FOR BID DRAWINGS AND SPECIFICATIONS, AND ANY SUBSEQUENT ADDENDA SHALL BE THE BASIS FOR ALL ACCEPTED WORK UNDER THIS CONTRACT.

WRIGHT-PIERCE


Engineering a Better Environment

Offices Throughout New England

888.621.8156 | www.wright-pierce.com

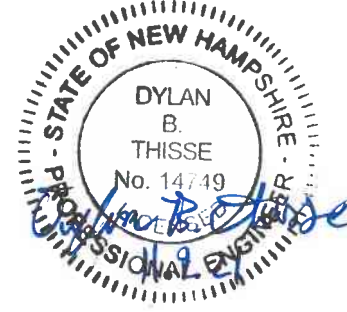

FOR REVIEW _____
FOR BIDDING AUGUST 2021
WP PROJECT No. 14206B

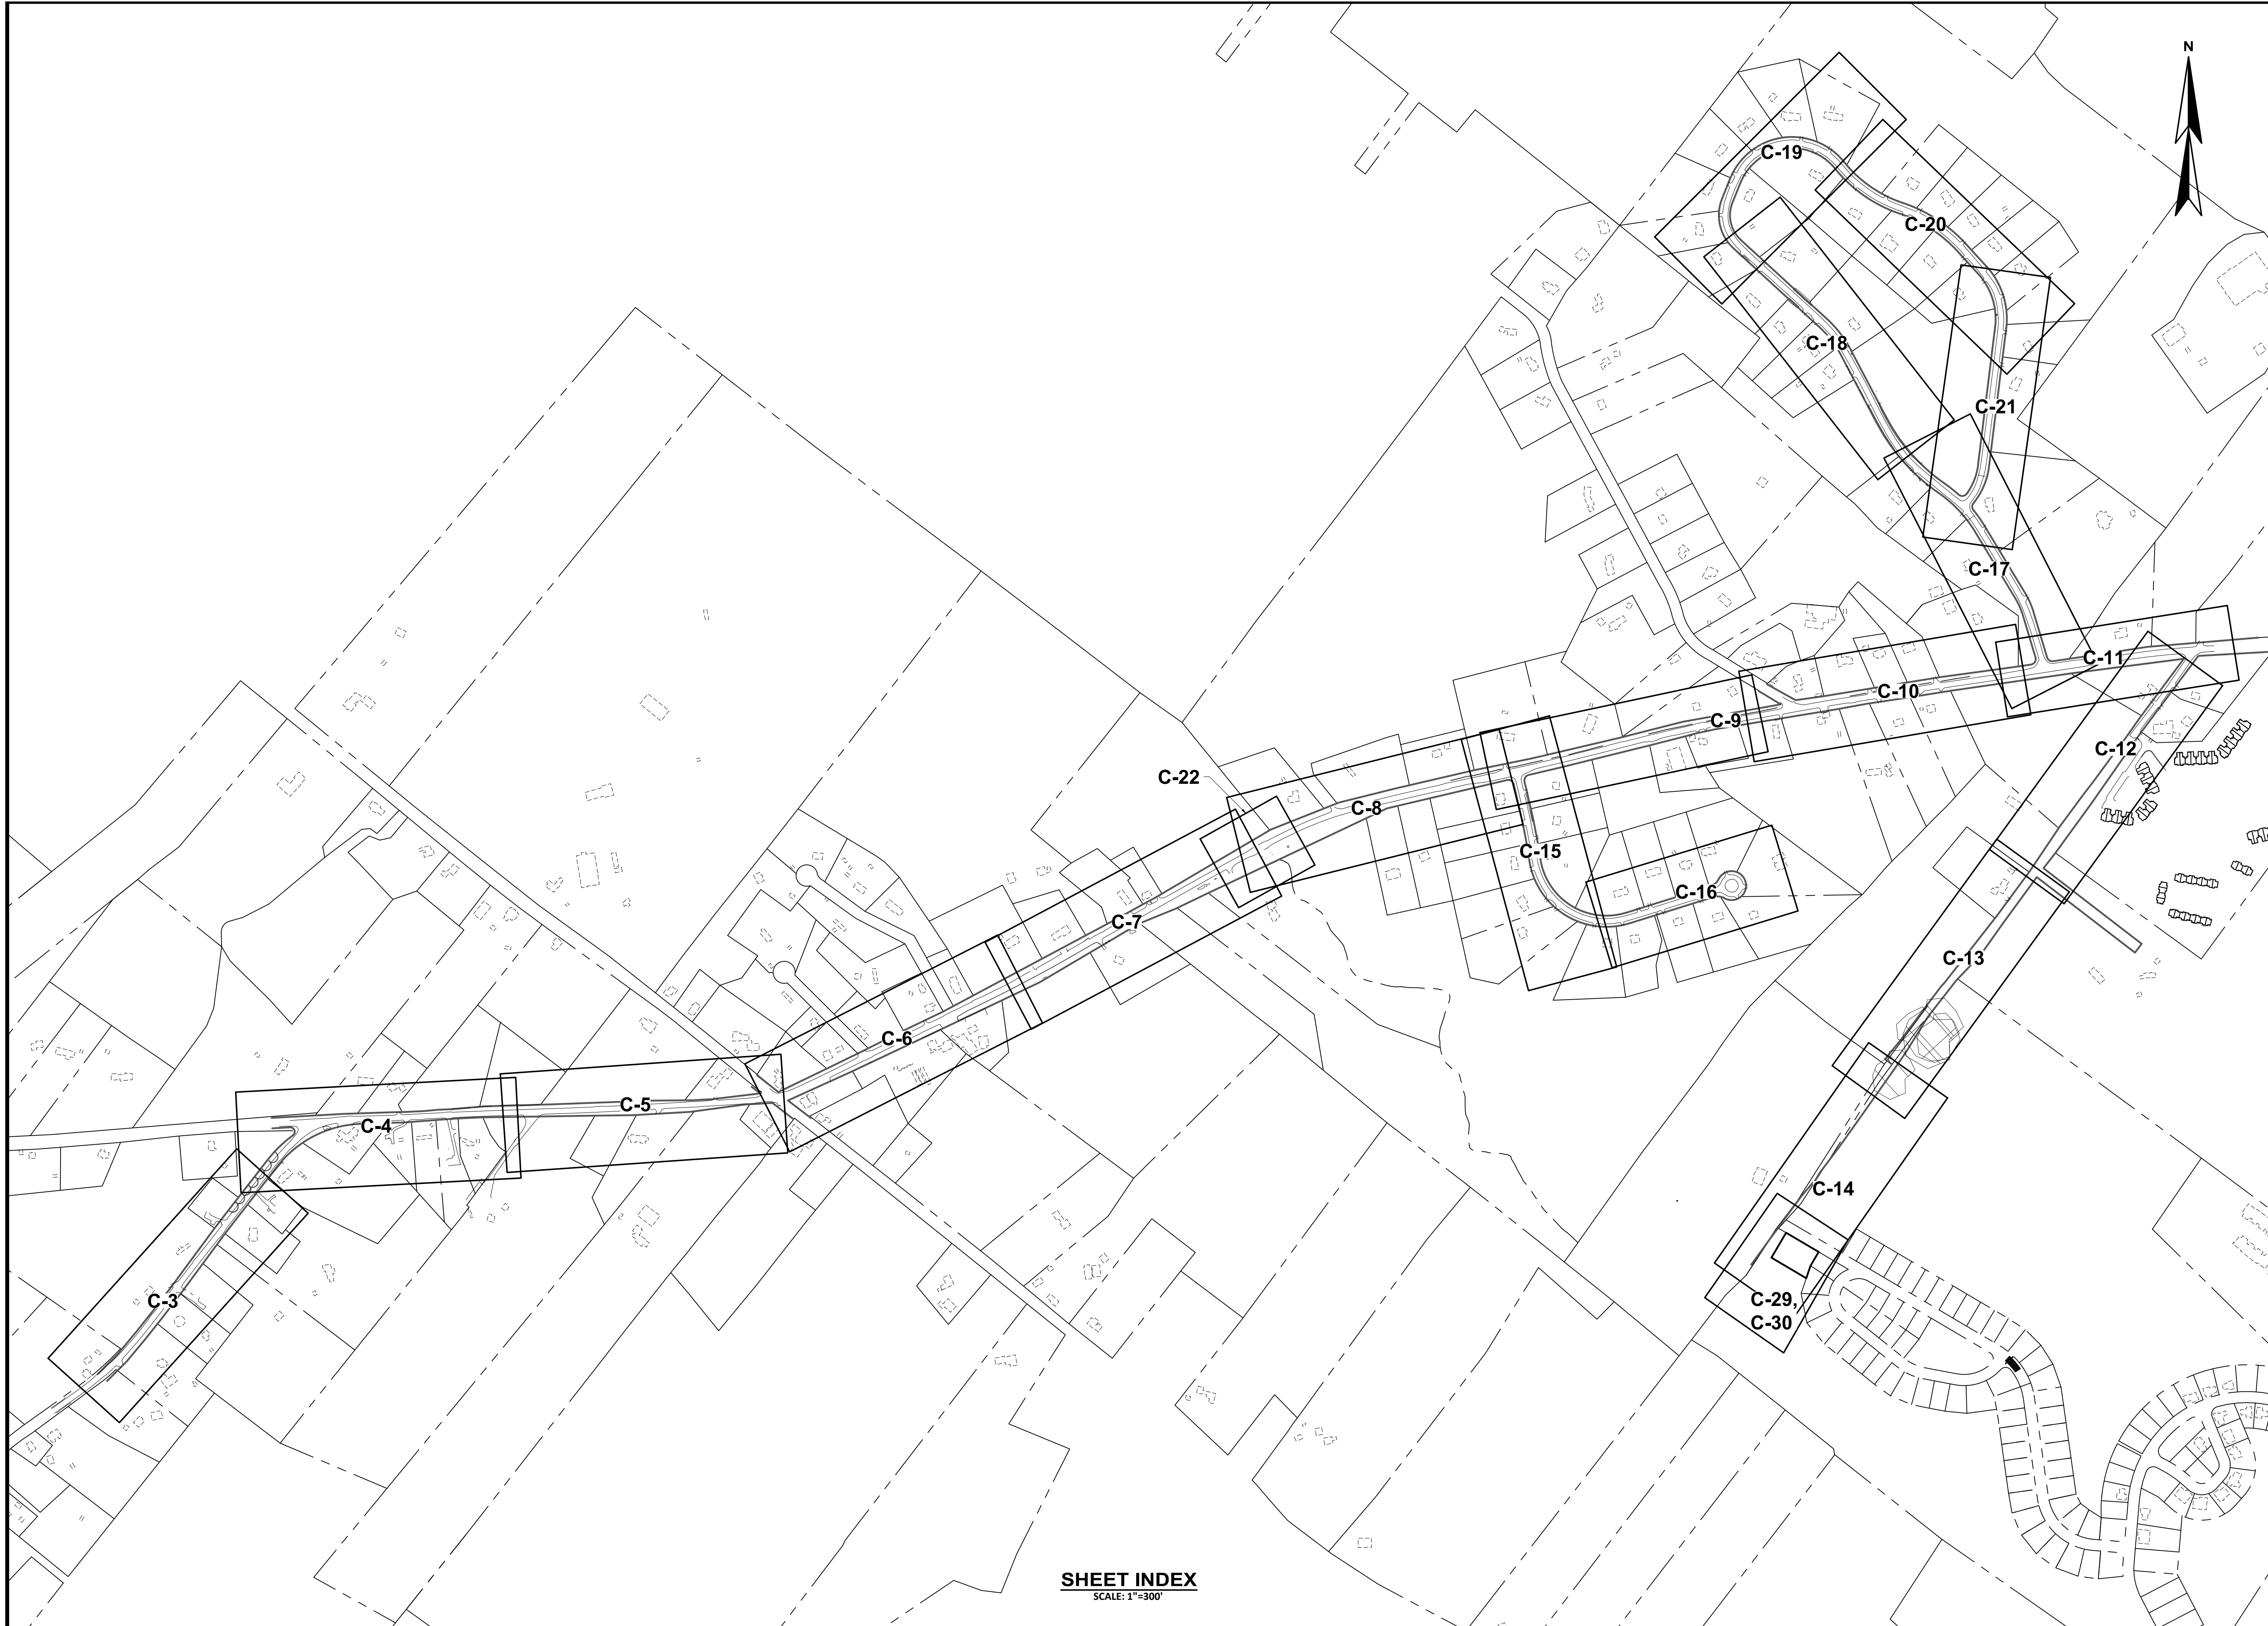

SHEET INDEX



SCALE: 1"=300'



CITY OF ROCHESTER, NEW HAMPSHIRE ROUTE 202A WATER MAIN EXTENSION & WATER STORAGE TANK ROCHESTER, NEW HAMPSHIRE		WRIGHT-PIERCE Engineering a Better Environment 888.621.8156 www.wright-pierce.com		CONFORMED REFERENCE DRAWINGS NOVEMBER 2021: THE CONFORMED REFERENCE DOCUMENTS HAVE BEEN REVISIONED TO INCORPORATE CLARIFICATIONS AND/OR REVISIONS TO THE PROJECT ADDENDUM IN ORDER TO CLARIFY AND ACCURATELY REFLECT THESE CLARIFICATIONS/CHANGES FOR CONVENIENCE AND REFERENCE. THE EXECUTED CONTRACT DOCUMENTS, INCLUDING THE ISSUED FOR BID DRAWINGS AND SPECIFICATIONS, AND ANY SUBSEQUENT ADDENDUM, SHALL BE THE BASIS FOR ALL ACCEPTED WORK UNDER THIS CONTRACT.		NO.		SUBMISSIONS/REVISIONS		APPD DATE
						CONTRACT DRAWINGS		D.THI	08-21	
DRAWING C-2		SHEET INDEX		DESIGNED BY: W. EDG		CAD CORP: W. EDG				
				CDD: W. EDG						
				CHECKED BY: D.LAR						
				DATE: 05-21						
				APPROVED BY: D.THI						
				DATE: 05-21						
				PROJECT NO: 14206B						
		</								

NOTE:

1. CONTRACTOR IS TO PERFORM SOIL SAMPLING FROM STA 100+00 TO STA 127+00 WITHIN 60 DAYS OF MOBILIZATION TO THE SITE. REFER TO SPECIFICATION SECTION 01010B.

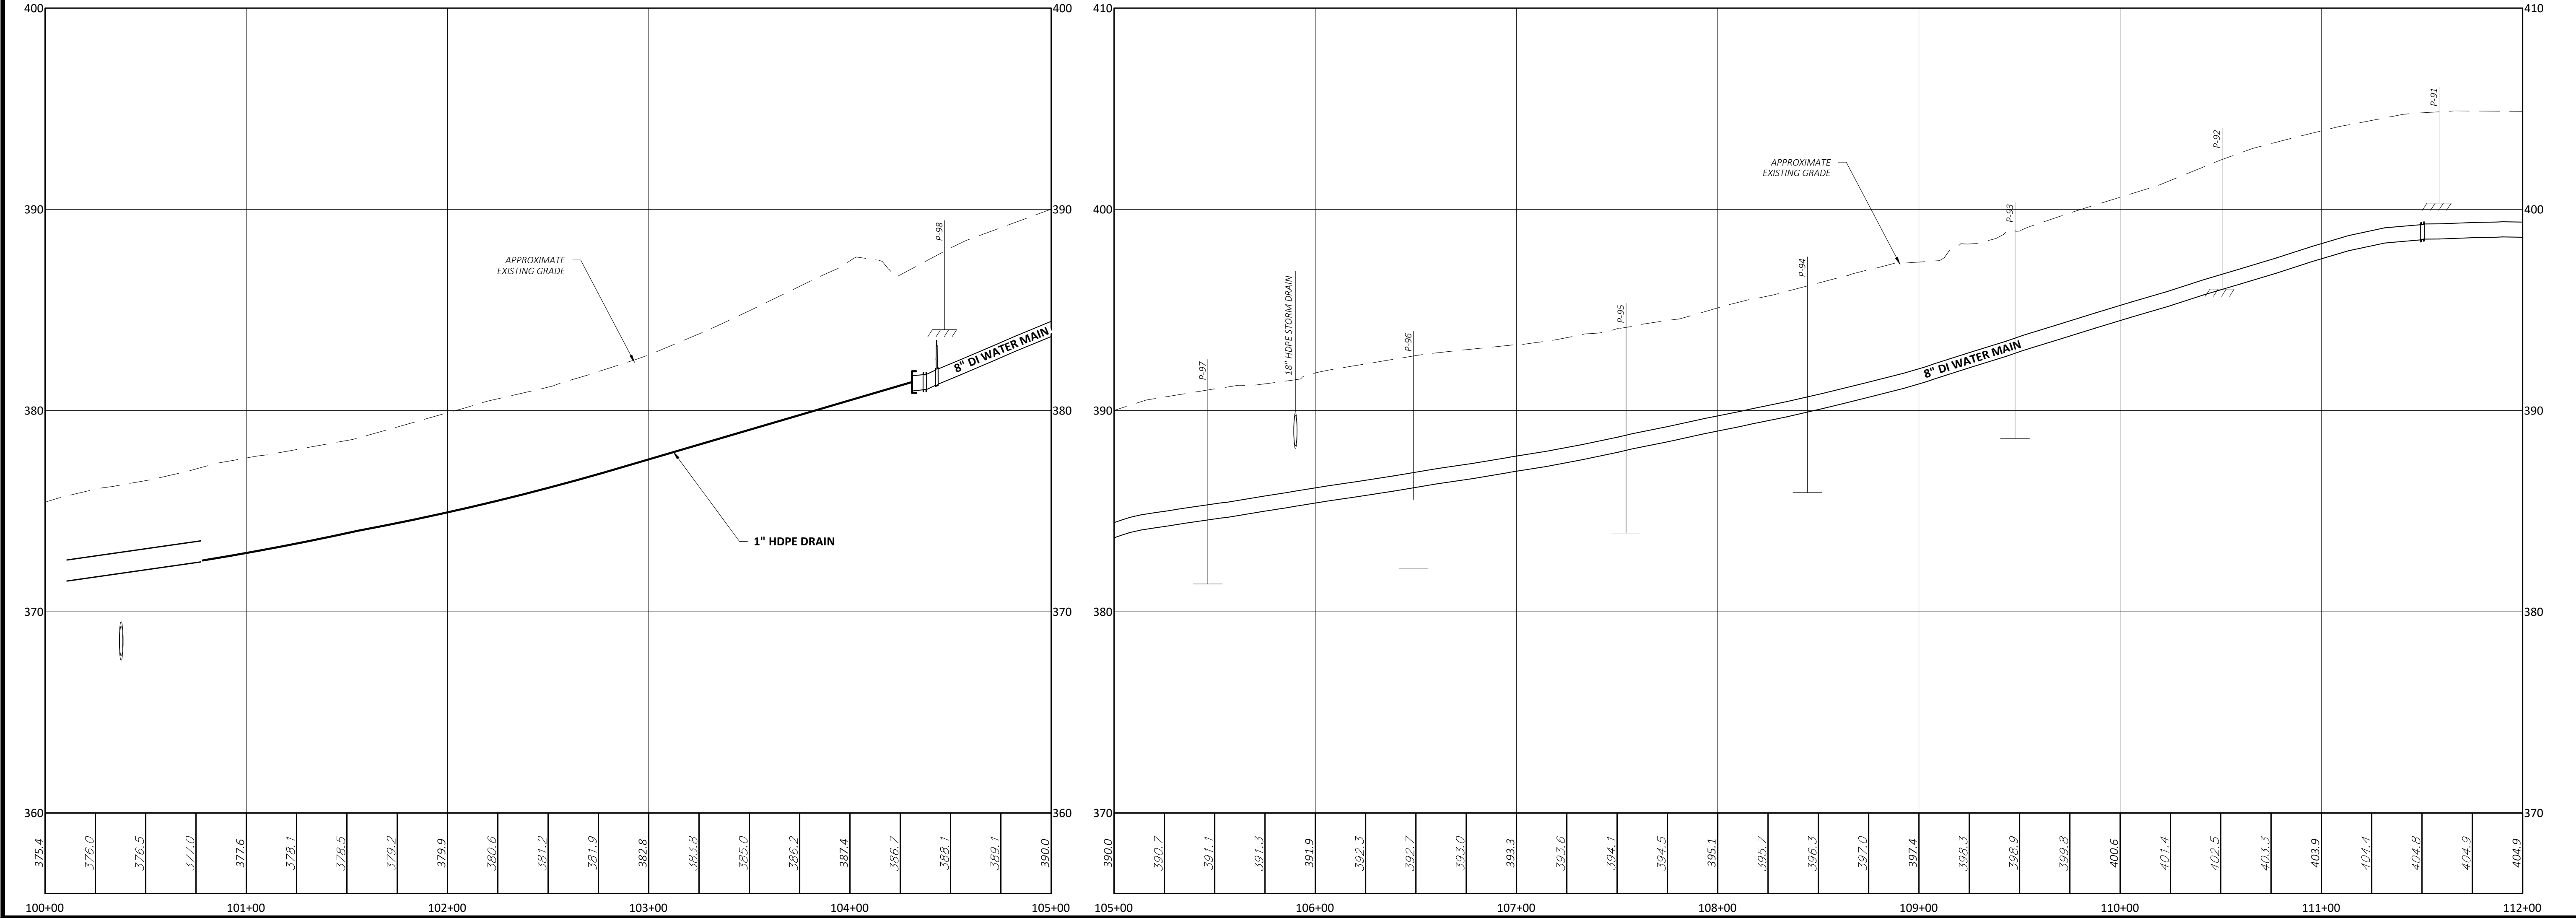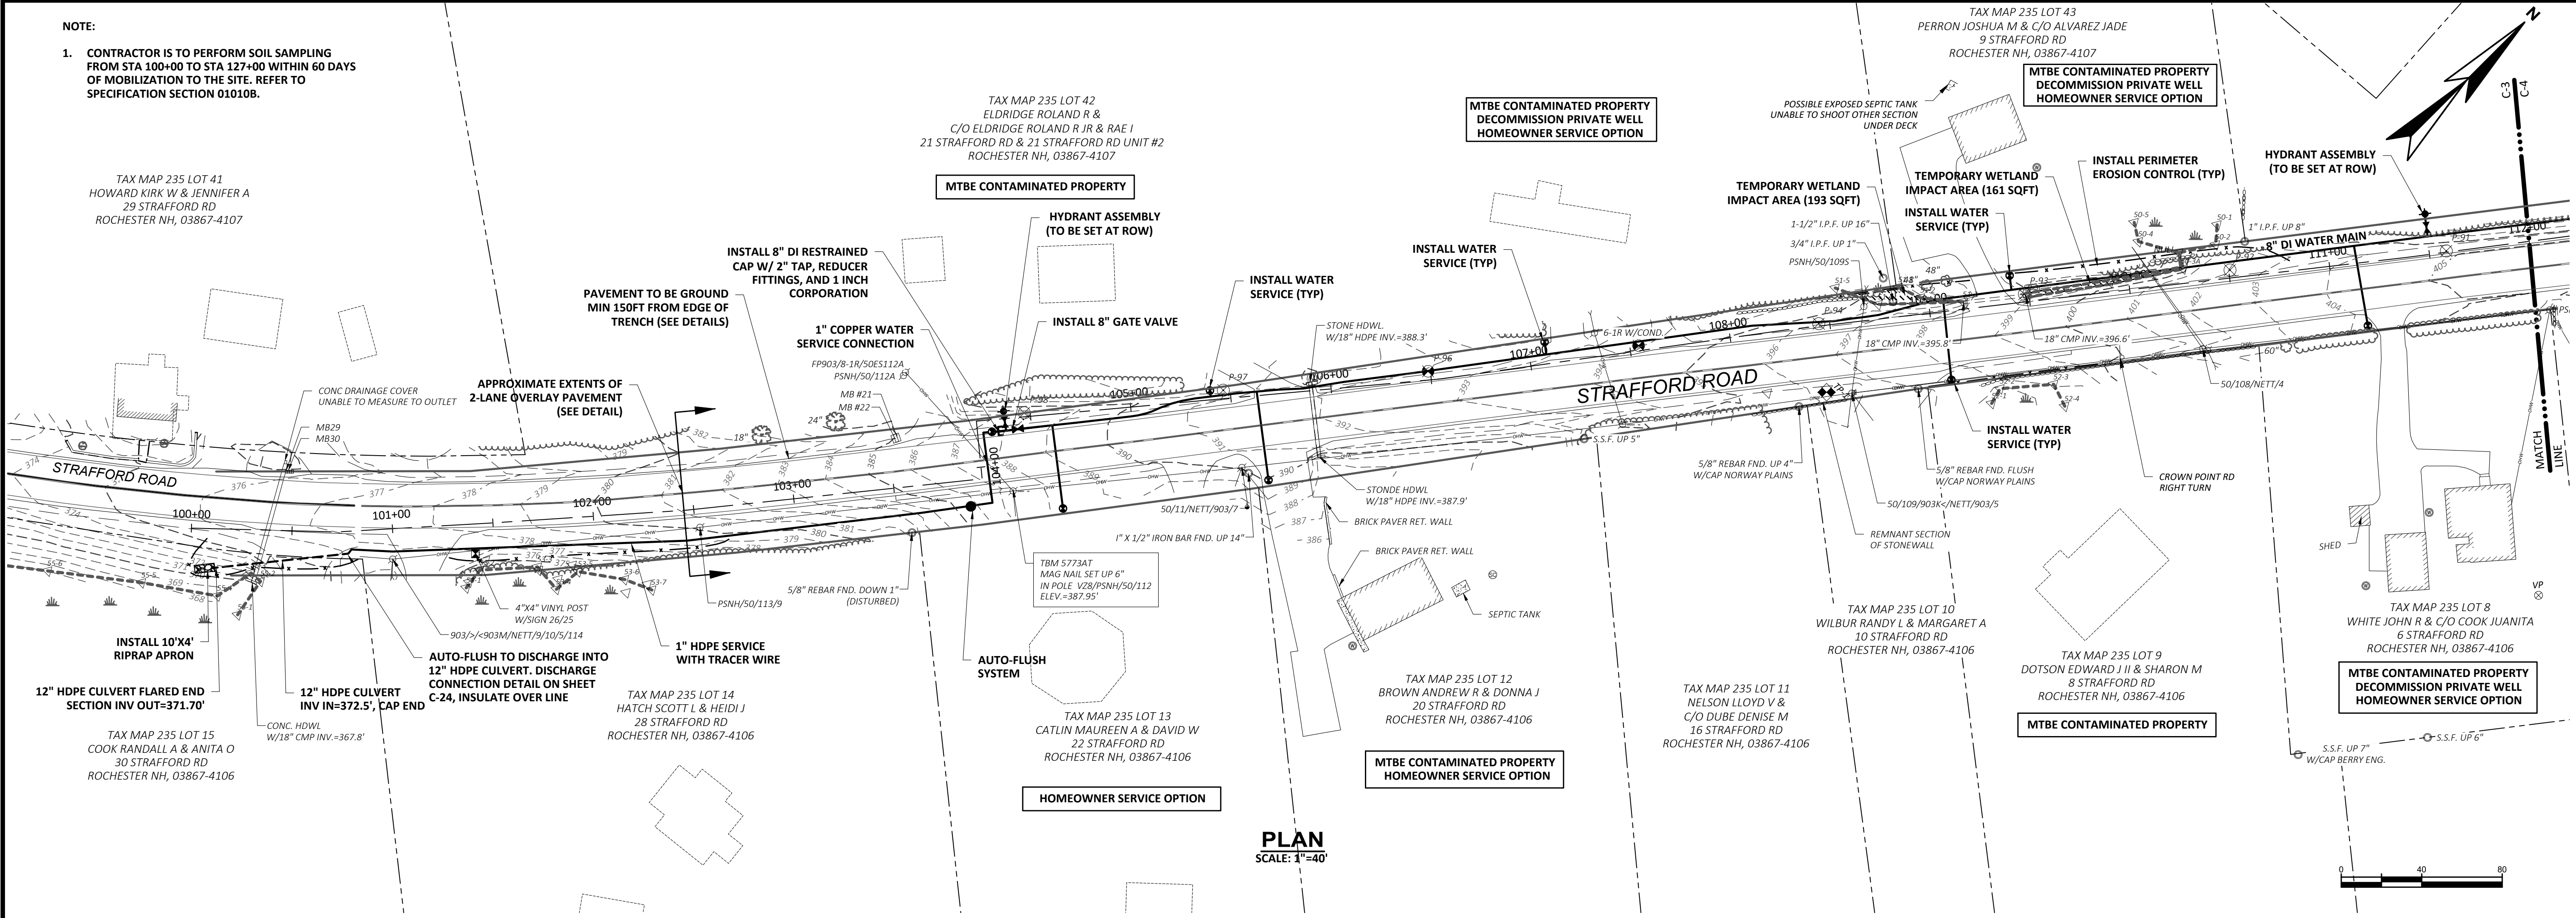

CONFORMED REFERENCE CHANGES NOVEMBER 2021. THE CONFORMED REFERENCE CHANGES HAVE BEEN REVIEWED TO INCORPORATE CLARIFICATIONS AND/OR DRAWING AND SPECIFICATION CHANGES FROM THE PROJECT DESIGNER IN ORDER TO CLARIFY AND ACCURATELY REFLECT THE INTENT OF THE DESIGN. THE EXISTING CONTRACT DOCUMENTS, INCLUDING THE BASIS OF DESIGN FOR BID DRAWINGS AND SPECIFICATIONS, AND ANY SUBSEQUENT ADDENDUMS SHALL BE THE BASIS FOR ALL ACCEPTED WORK UNDER THIS CONTRACT.

NO	DATE	DESCRIPTION
1	11/9/2021	ISSUED FOR BIDDING

DESIGNED BY: A.MAR
C.D. CORP. W.EDG
C.D. W.EDG
CHECKED BY: D.LAR
DATE: 05-21
APPROVED BY: D.THI
DATE: 05-21
PROJECT NO.: 14206B

WRIGHT-PIERCE
Engineering a Better Environment
888.621.8156 | www.wright-pierce.com



CITY OF ROCHESTER, NEW HAMPSHIRE
ROUTE 202A WATER MAIN EXTENSION &
WATER STORAGE TANK
ROCHESTER, NEW HAMPSHIRE

PLAN AND PROFILE 1
STRAFFORD ROAD - CROWN POINT ROAD (ROUTE 202A)
STA. 100+00 TO STA. 112+00

DRAWING
C-3

NOTE:

1. CONTRACTOR IS TO PERFORM SOIL SAMPLING FROM STA 100+00 TO STA 127+00 WITHIN 60 DAYS OF MOBILIZATION TO THE SITE. REFER TO SPECIFICATION SECTION 01010B.

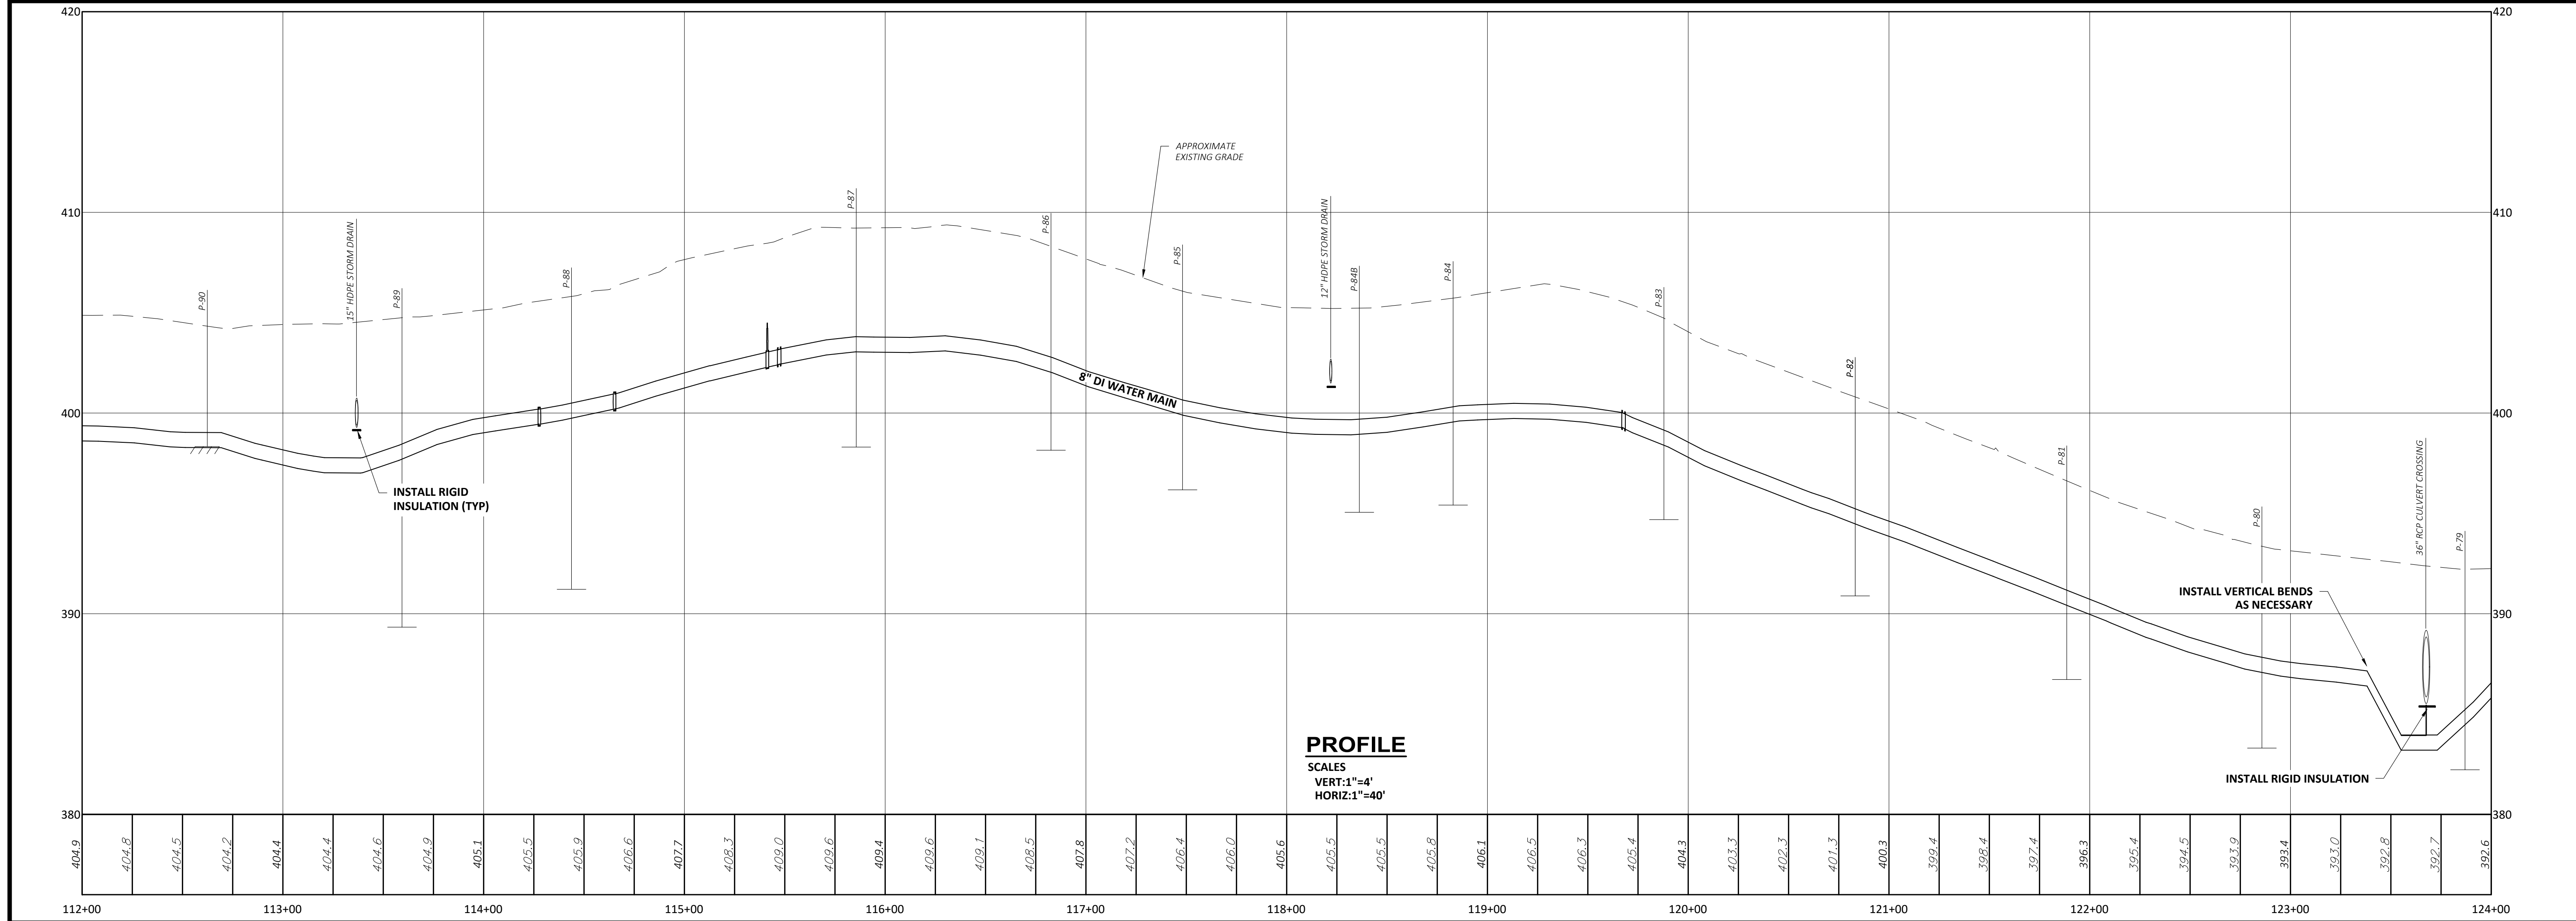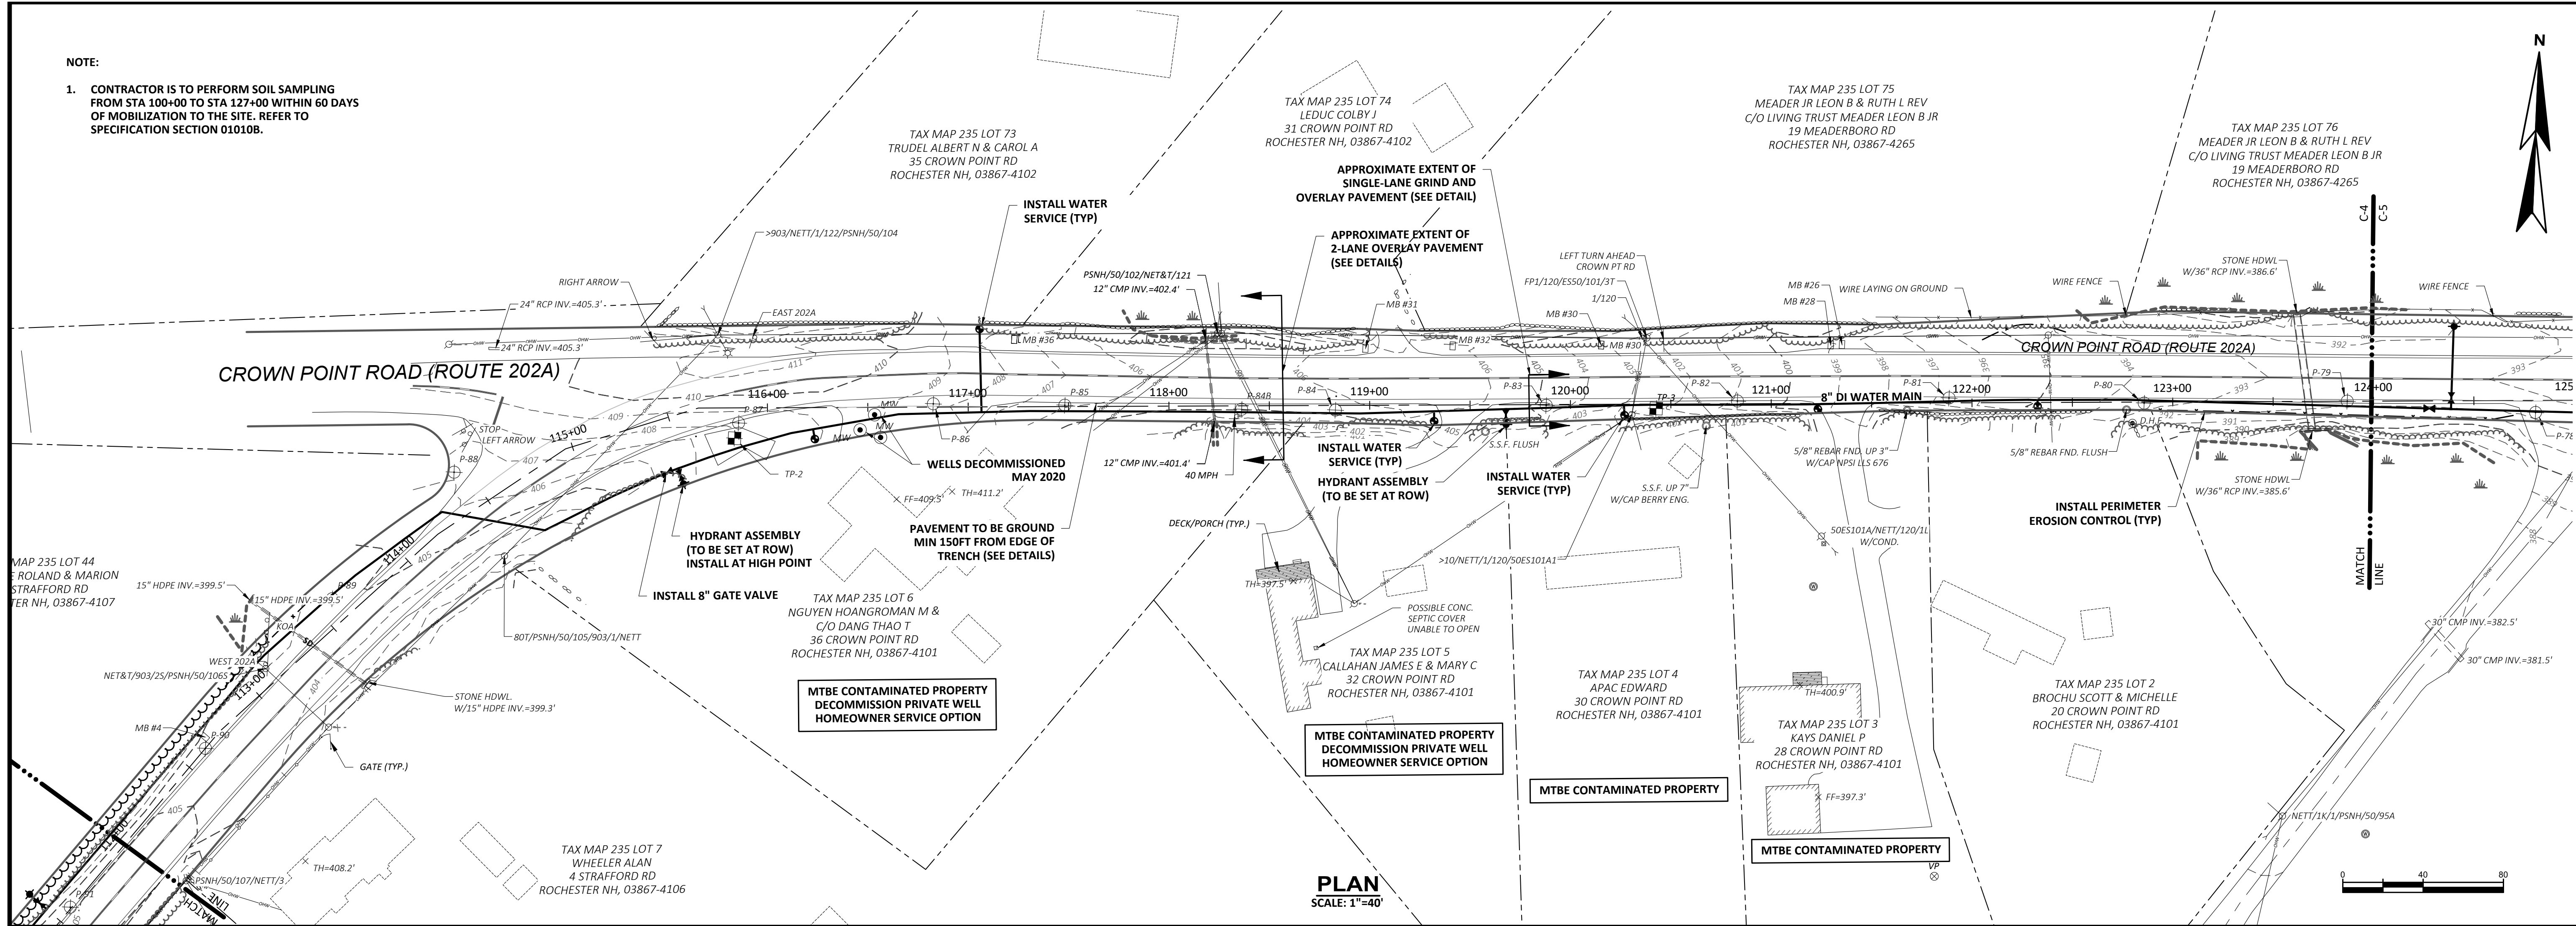


CITY OF ROCHESTER, NEW HAMPSHIRE ROUTE 202A WATER MAIN EXTENSION & WATER STORAGE TANK ROCHESTER, NEW HAMPSHIRE PLAN AND PROFILE II CROWN POINT ROAD (ROUTE 202A) STA. 112+00 TO STA. 124+00		WRIGHT-PIERCE <i>Engineering a Better Environment</i> 888.621.8156 www.wright-pierce.com		CONFORMED REFERENCE DRAWINGS: NOVEMBER 2021. THE CONFORMED REFERENCE DOCUMENTS HAVE BEEN REVISED TO INCORPORATE CAMBARIATIONS, AND/OR DRAWING AND SPECIFICATION CHANGES FROM THE PROJECT. ADDITIONAL ORDER TO CLEANLY AND ACCURATELY REFLECT THESE CAMBARIATIONS/CHANGES FOR CONVENIENCE AND REFERENCE. THE EXECUTED CONTRACT DOCUMENTS, INCLUDING THE ISSUED FOR BID DRAWINGS AND SPECIFICATIONS, AND ANY SUBSEQUENT ADDENDUM SHALL BE THE BASIS FOR ALL ACCEPTED WORK UNDER THIS CONTRACT.		DRAWING	
						C-4	


DESIGNED BY: A.MAR		NO	SUBMISSIONS/REVISIONS		APPD	DATE
CADD: W.EDG			CONTRACT DRAWINGS		D.THI	08-21
CHECKED BY: D.LAR		Δ				
DATE: 05-21		Δ				
APPROVED BY: D.THI		Δ				
DATE: 05-21		Δ				
PROJECT NO.: 14206B		Δ				

NOTE:

1. CONTRACTOR IS TO PERFORM SOIL SAMPLING FROM STA 100+00 TO STA 127+00 WITHIN 60 DAYS OF MOBILIZATION TO THE SITE. REFER TO SPECIFICATION SECTION 010108.

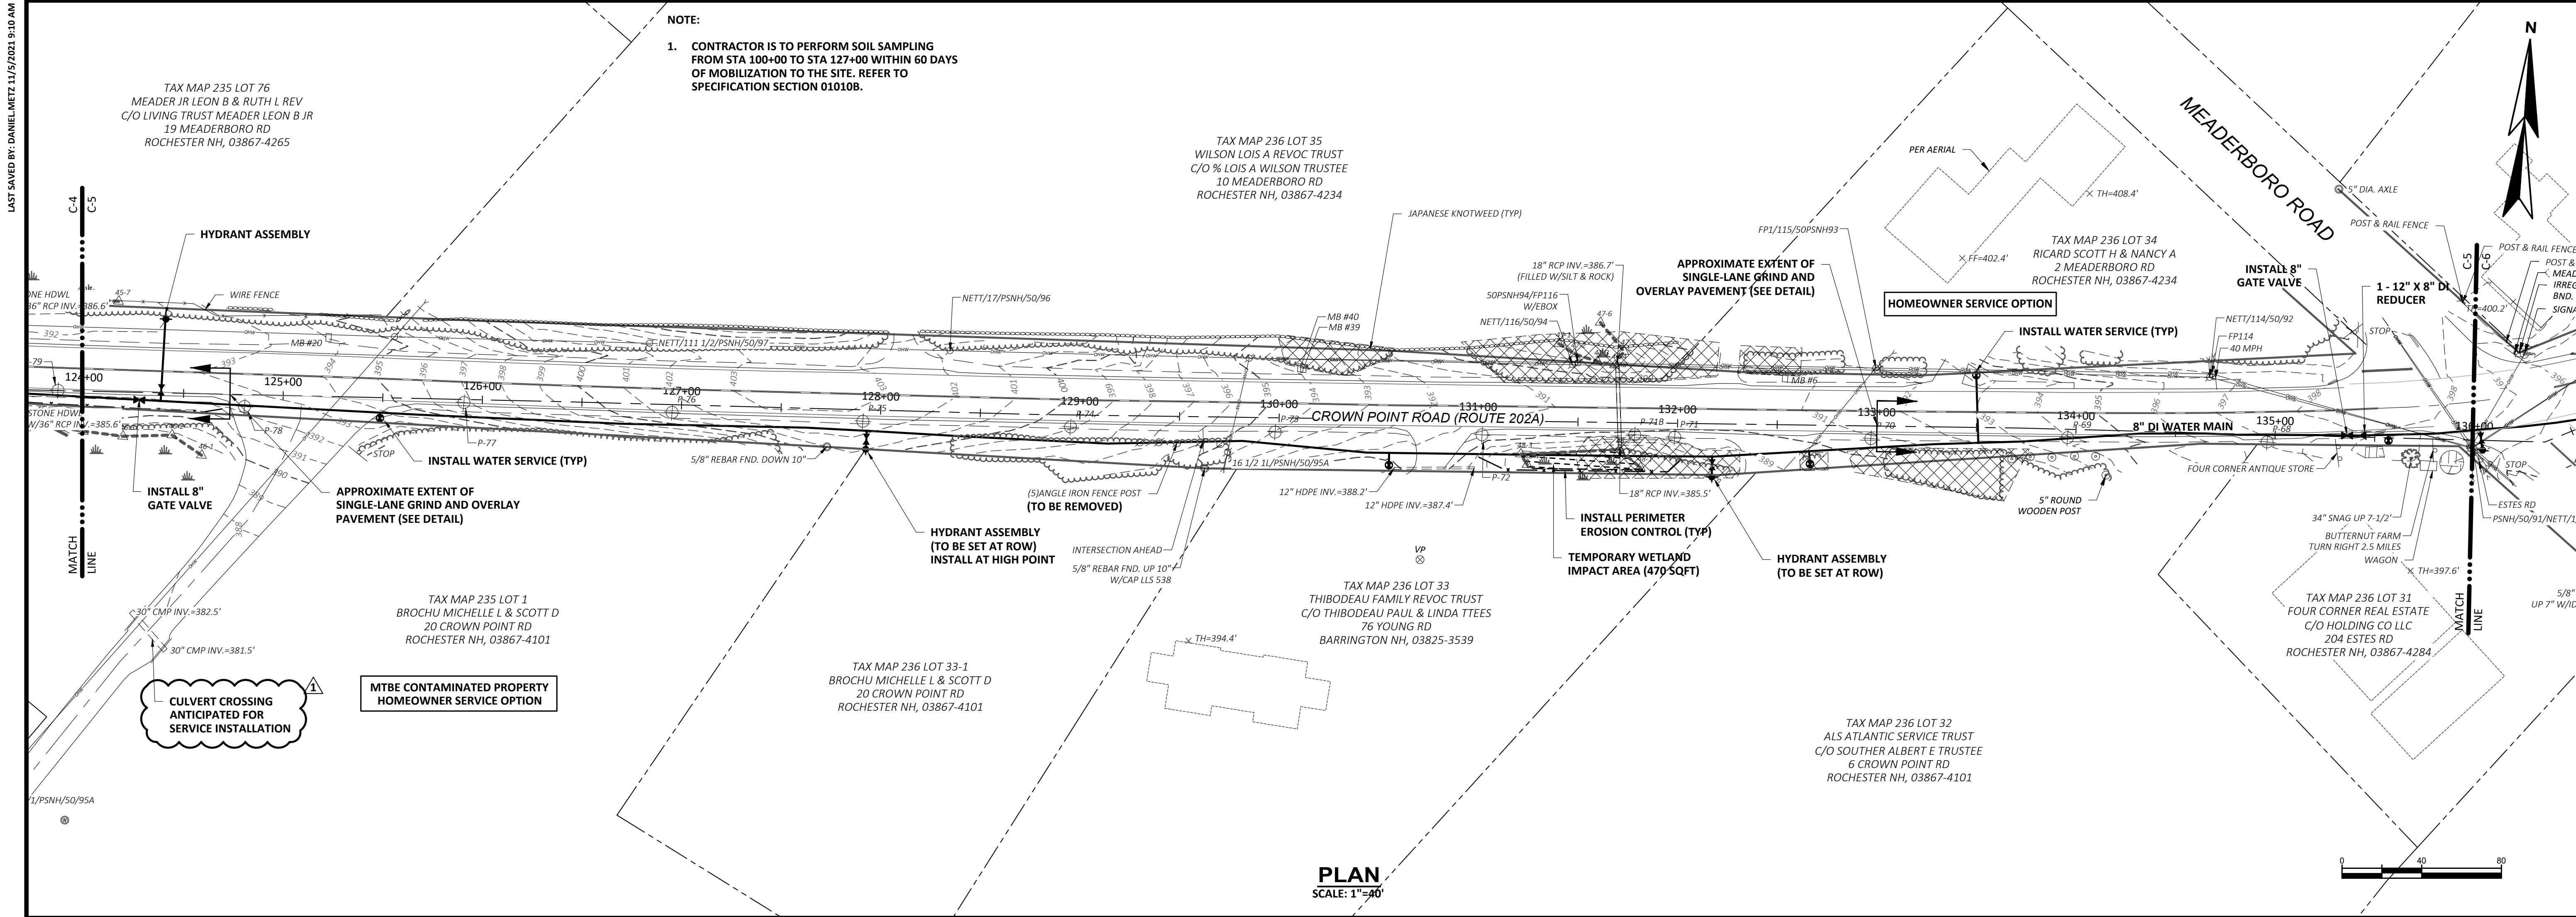

PLAN
SCALE: 1"=40'


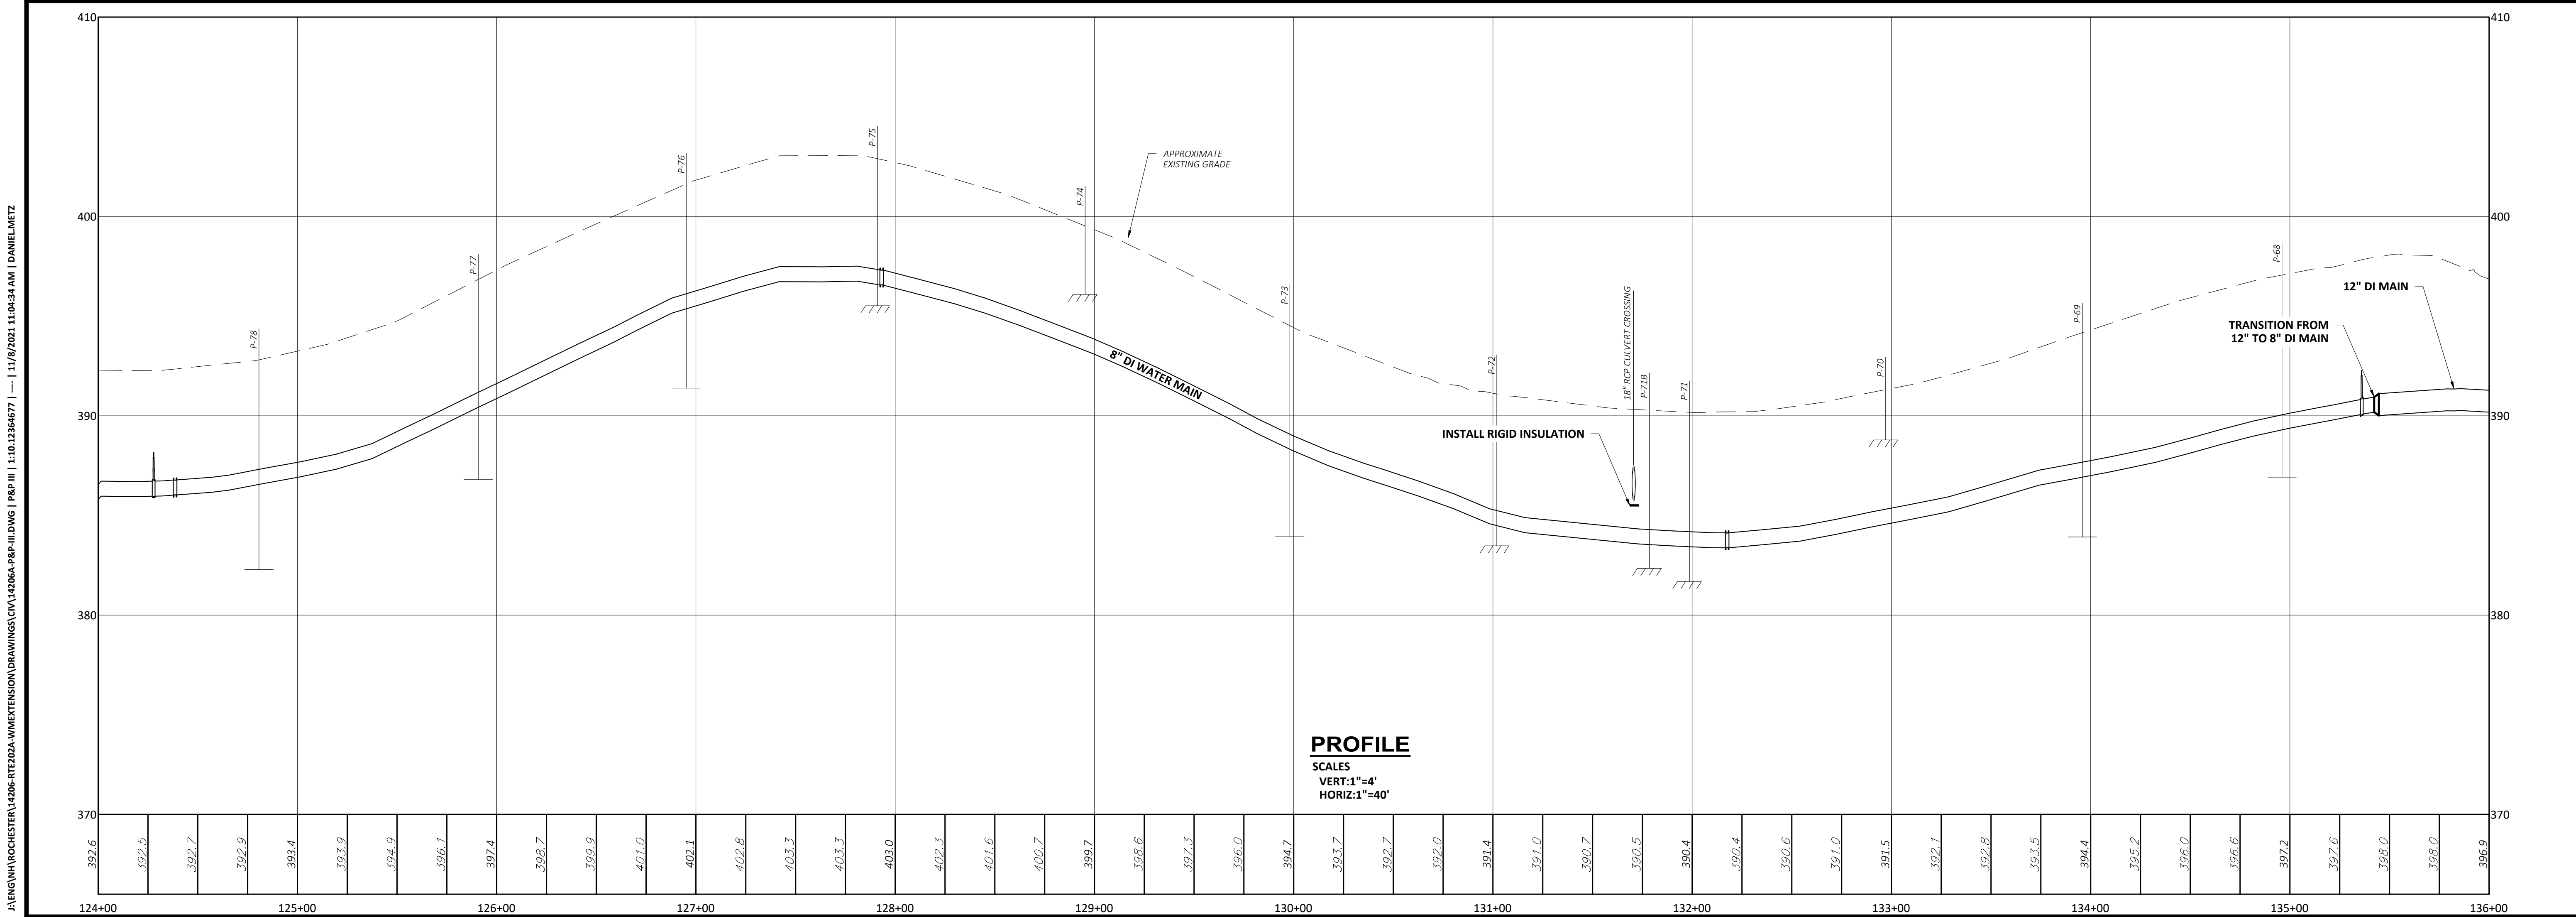


PROFILE
SCALES
VERT: 1"=4'
HORIZ: 1"=40'

CONTRACT DRAWINGS		SUBMISSIONS/REVISIONS		DESIGNED BY: A.MAR		CAD CORP.: W.EDG		CAD: W.EDG		CHECKED BY: D.LAR		DATE: 05-21		APPROVED BY: D.THI		DATE: 05-21		PROJECT NO: 14206B	
NO	DESCRIPTION	NO	DESCRIPTION	APPD	DATE	APPD	DATE	APPD	DATE	APPD	DATE	APPD	DATE	APPD	DATE	APPD	DATE	APPD	DATE
1	ADDENDUM 1																		
CITY OF ROCHESTER, NEW HAMPSHIRE ROUTE 202A WATER MAIN EXTENSION & WATER STORAGE TANK ROCHESTER, NEW HAMPSHIRE PLAN AND PROFILE III CROWN POINT ROAD (ROUTE 202A) - WALNUTE STREET STA. 124+00 TO STA. 136+00 DRAWING C-5																			

CONFORMED REFERENCE DRAWINGS: 14206- RTE202A- WMEXTENSION\DRAWINGS\CON\14206A-RP-H.DWG | P&P | 11/18/2021 11:04:34 AM | DANIEL METZ

WRIGHT-PIERCE
Engineering a Better Environment
888.621.8156 | www.wright-pierce.com

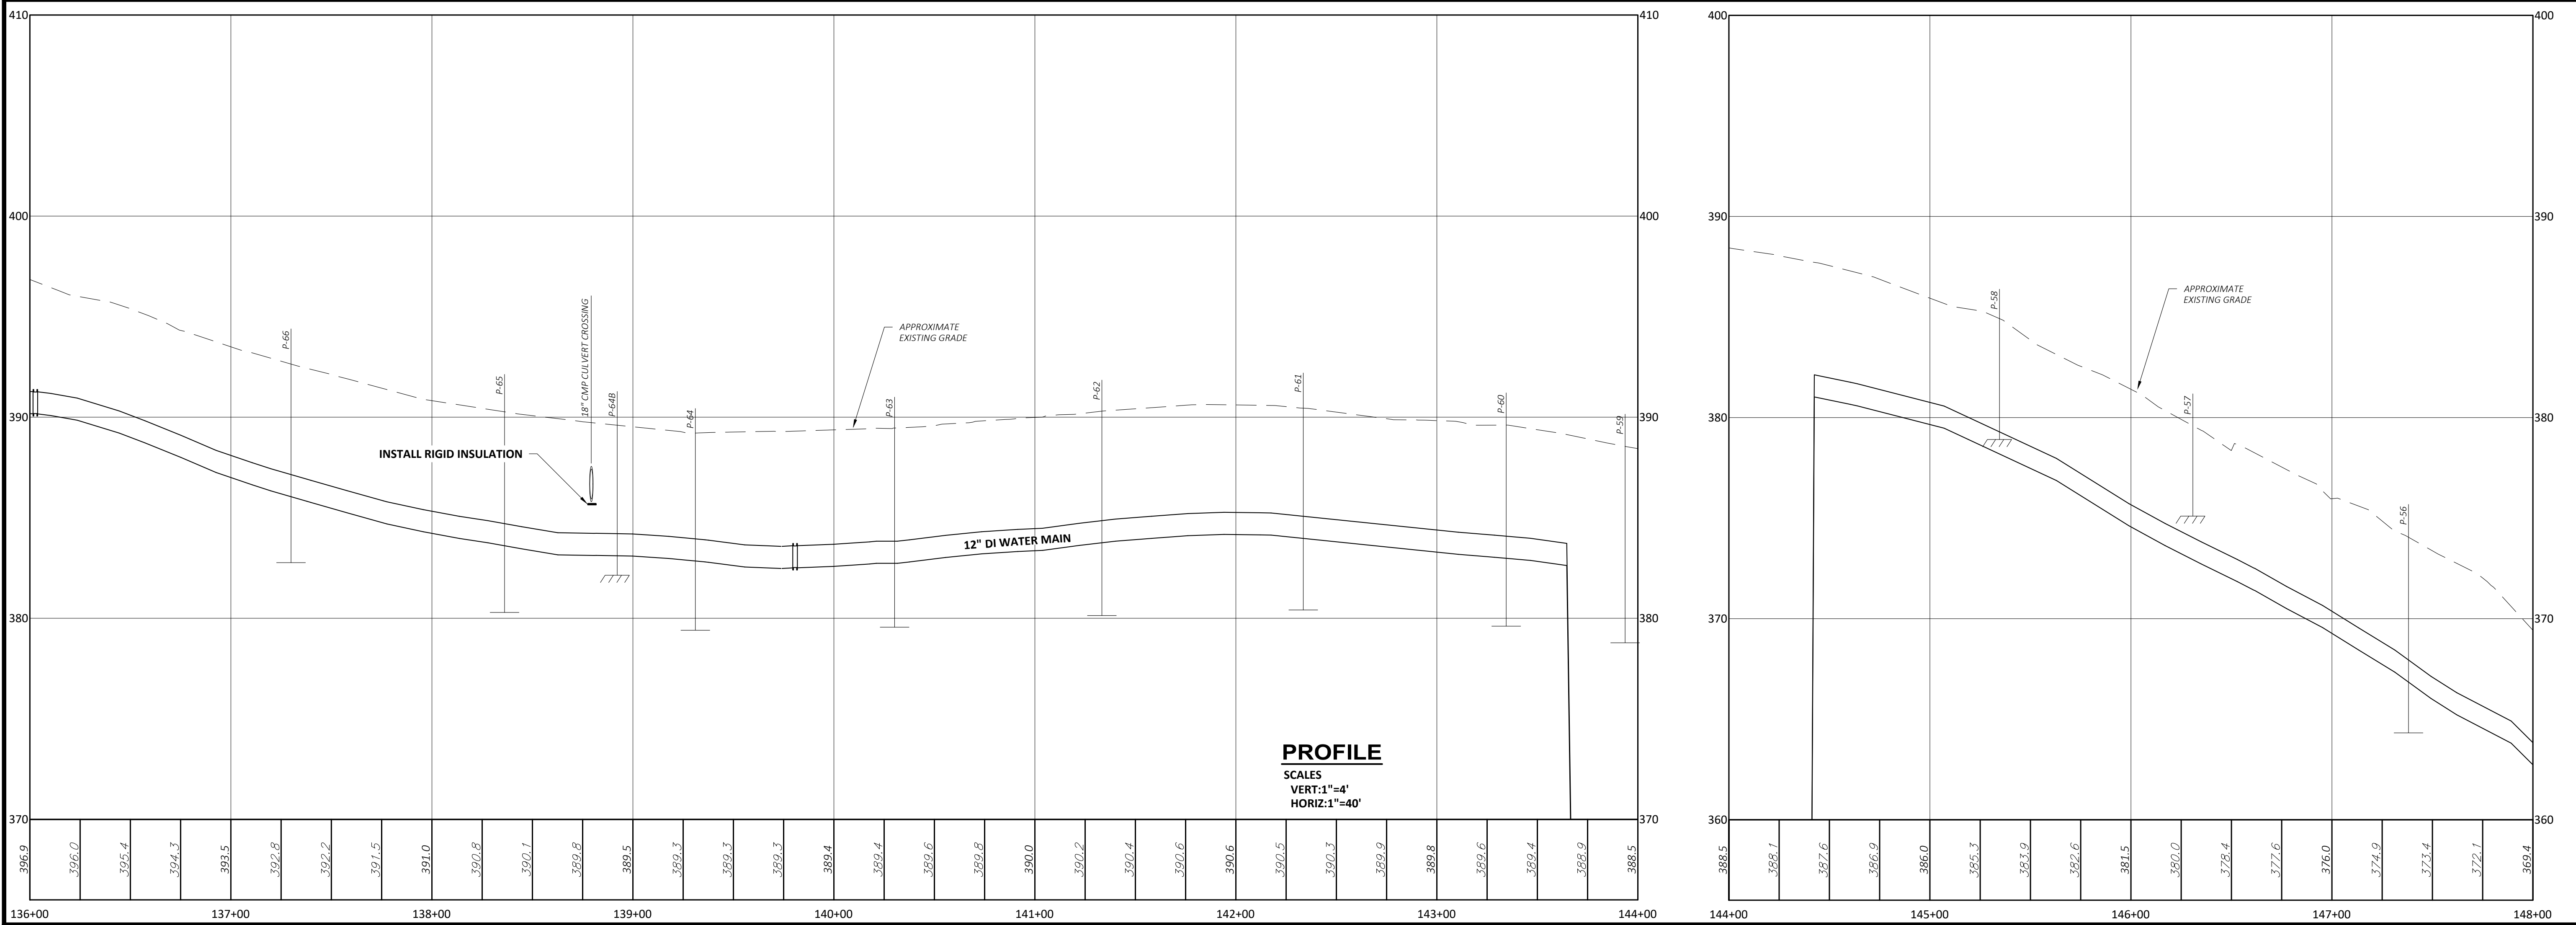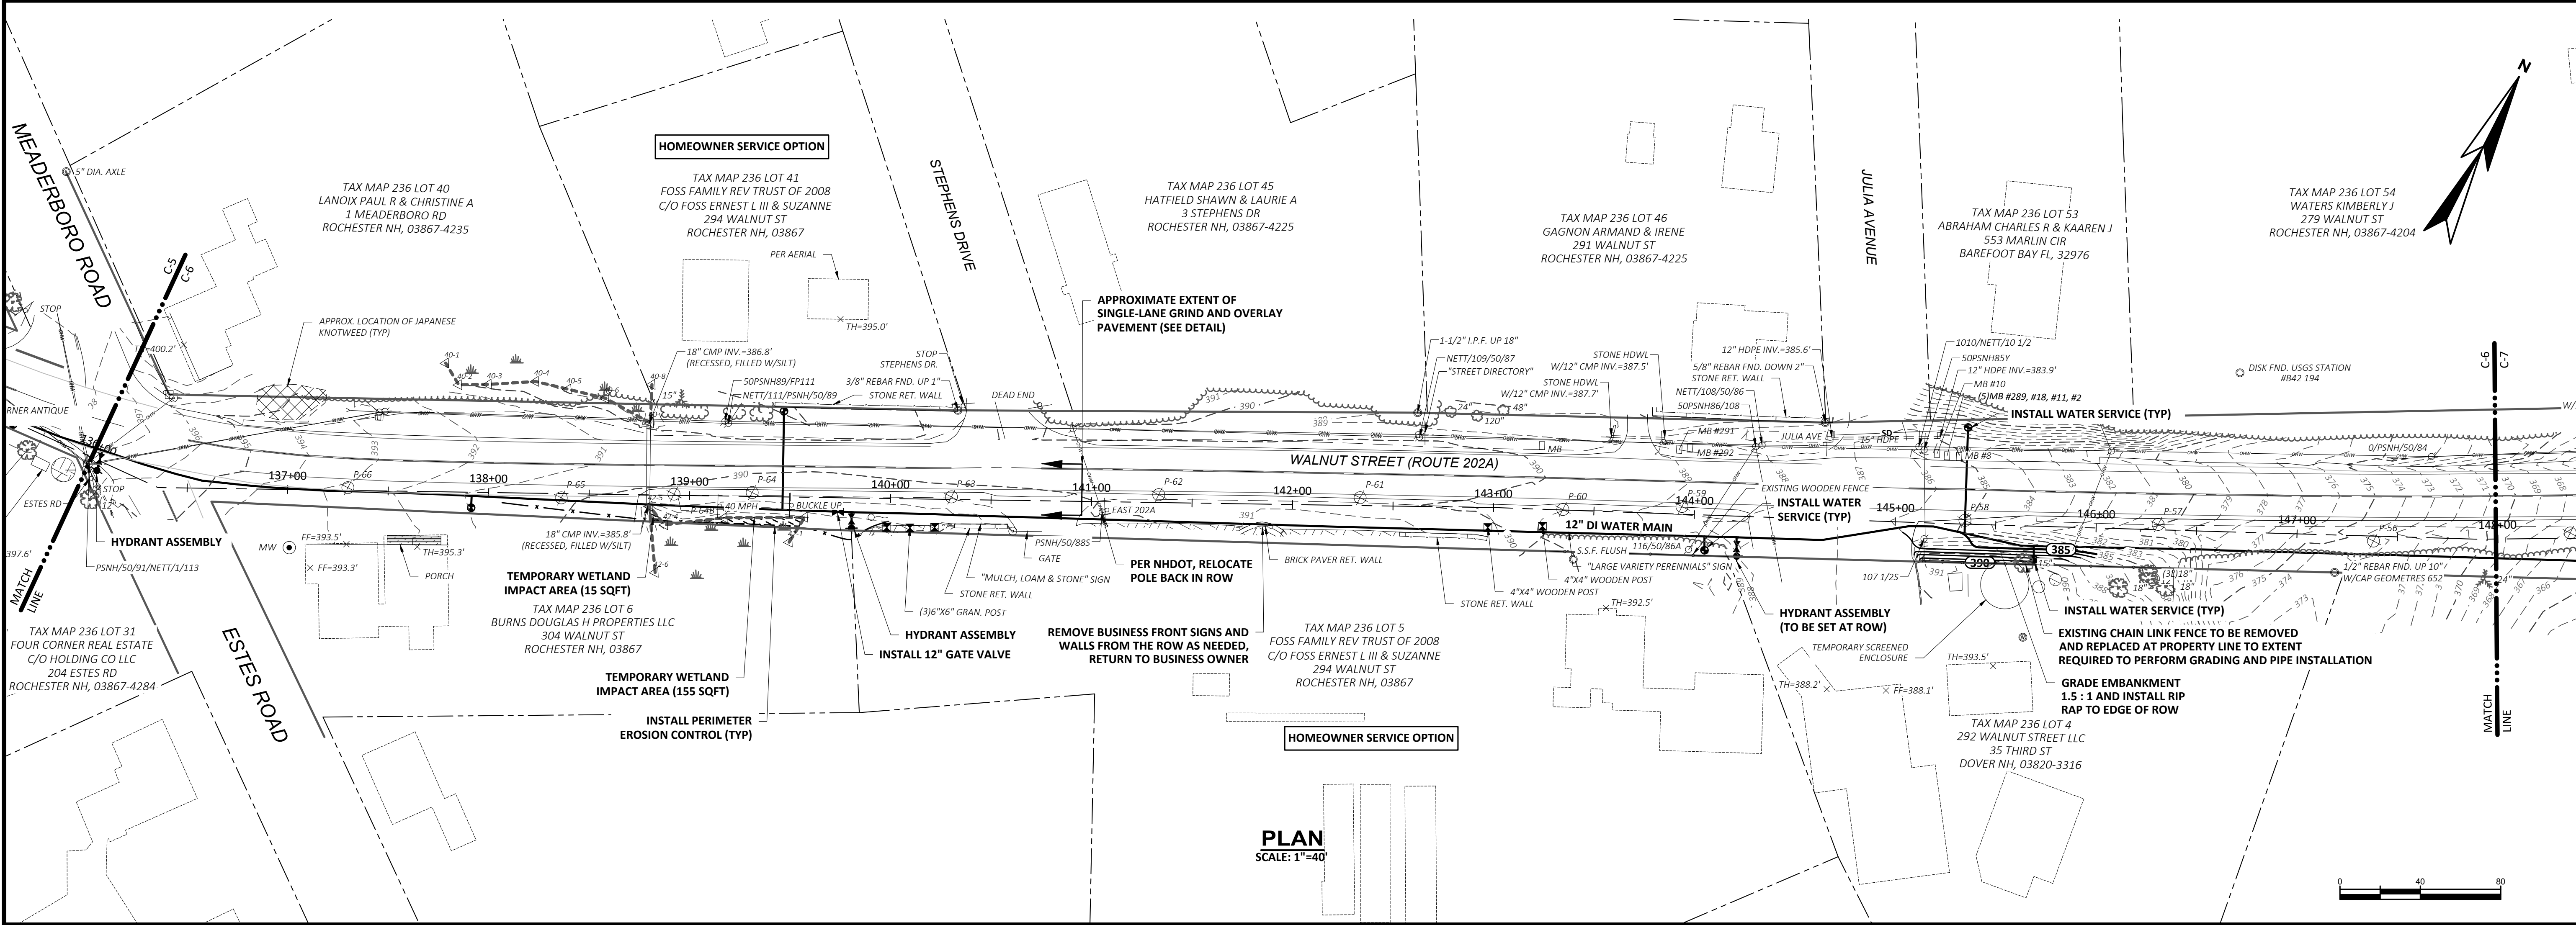

SUBMISSIONS/REVISIONS		CONTRACT DRAWINGS	
NO	DATE	NO	DATE
1	08-21	1	08-21
2	08-21	2	08-21
3	08-21	3	08-21
4	08-21	4	08-21
5	08-21	5	08-21
6	08-21	6	08-21
7	08-21	7	08-21
8	08-21	8	08-21
9	08-21	9	08-21
10	08-21	10	08-21



DESIGNED BY: A.MAR		CHECKED BY: D.LAR	
CAD CORP: W.EDG	CAD: W.EDG	DATE: 05-21	DATE: 05-21
PROJECT NO: 14206B		PROJECT NO: 14206B	

CITY OF ROCHESTER, NEW HAMPSHIRE
ROUTE 202A WATER MAIN EXTENSION & WATER STORAGE TANK
ROCHESTER, NEW HAMPSHIRE


PLAN AND PROFILE IV
CROWN POINT ROAD (ROUTE 202A)
STA. 136+00 TO STA. 148+00



WRIGHT-PIERCE
Engineering a Better Environment
888.621.8156 | www.wright-pierce.com



DRAWING
C-6

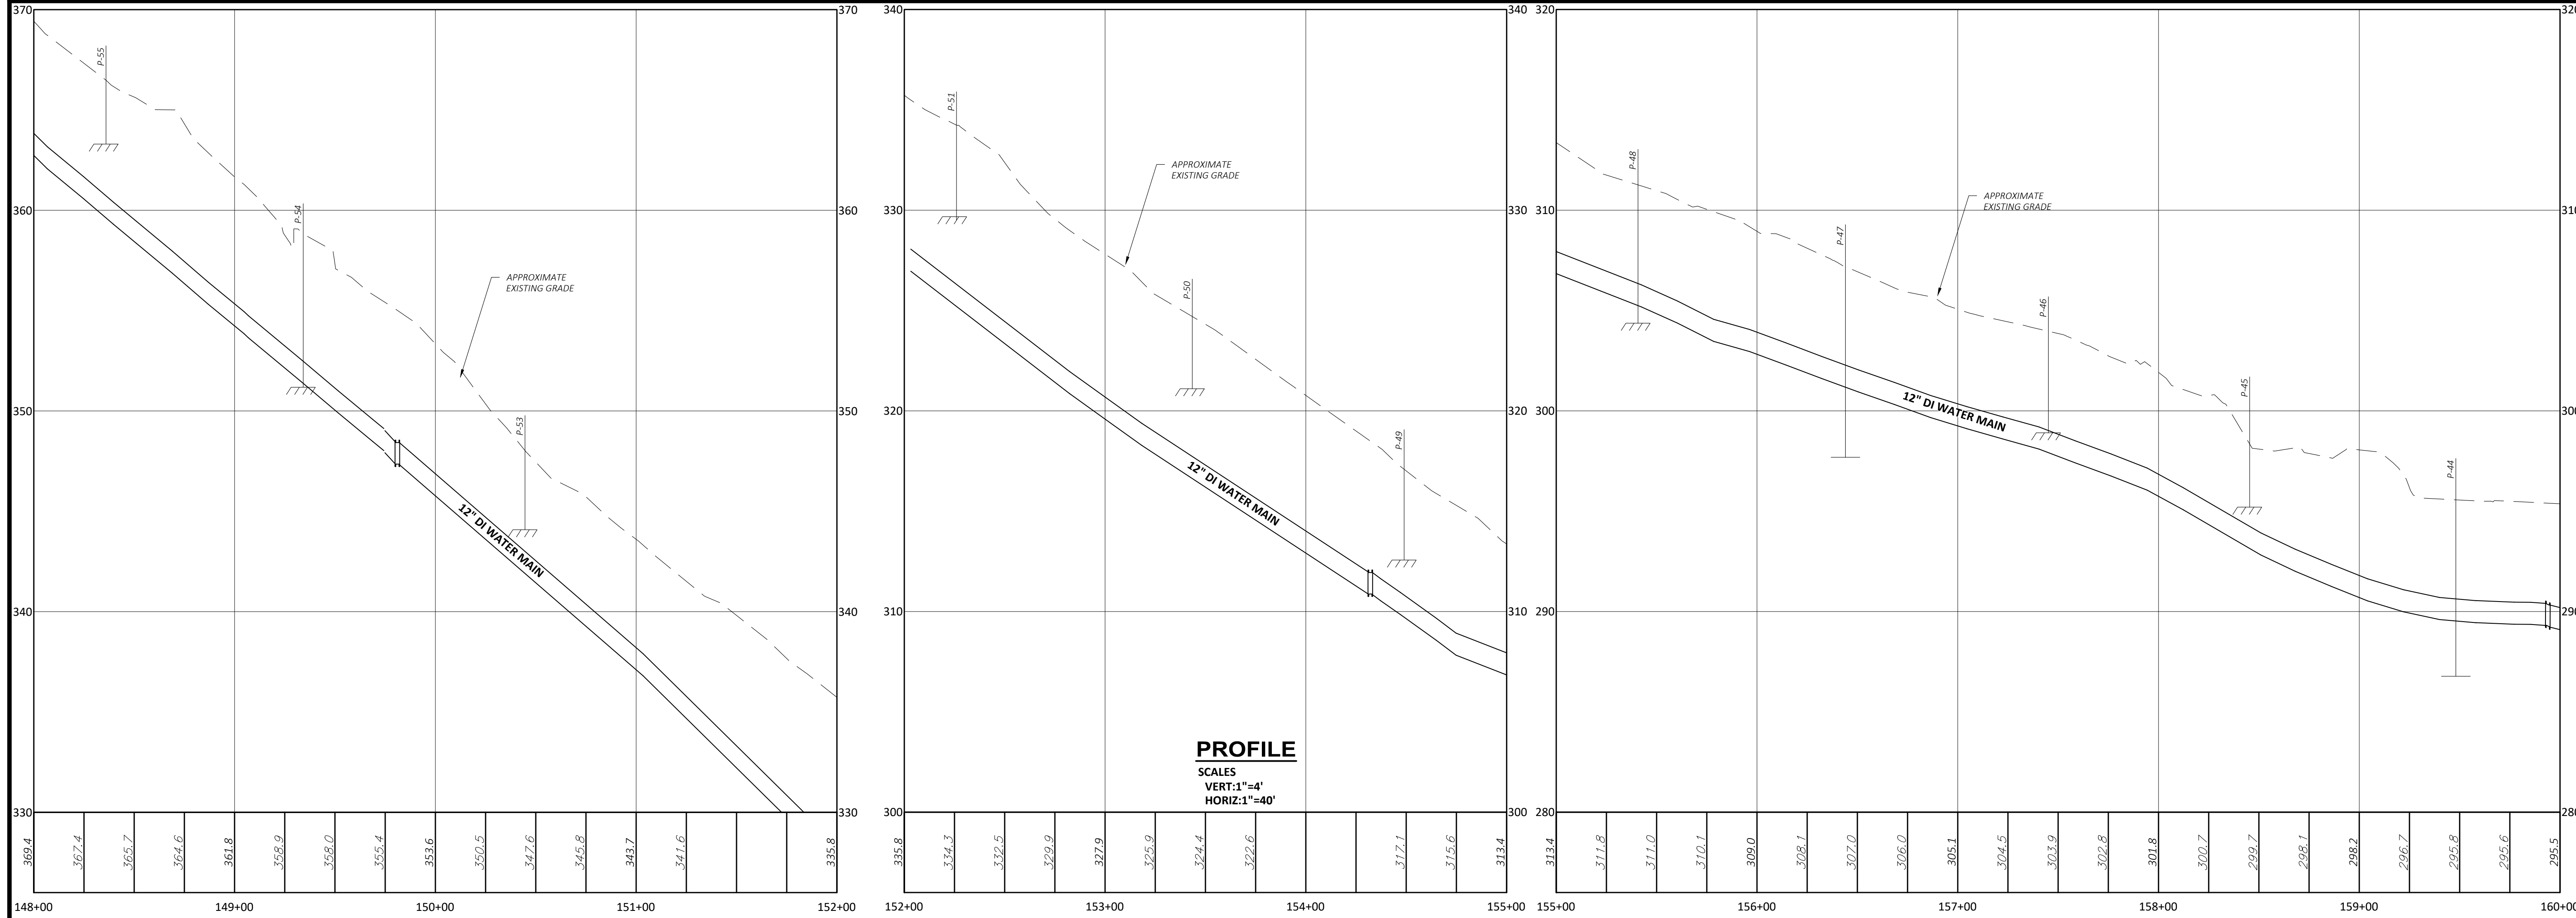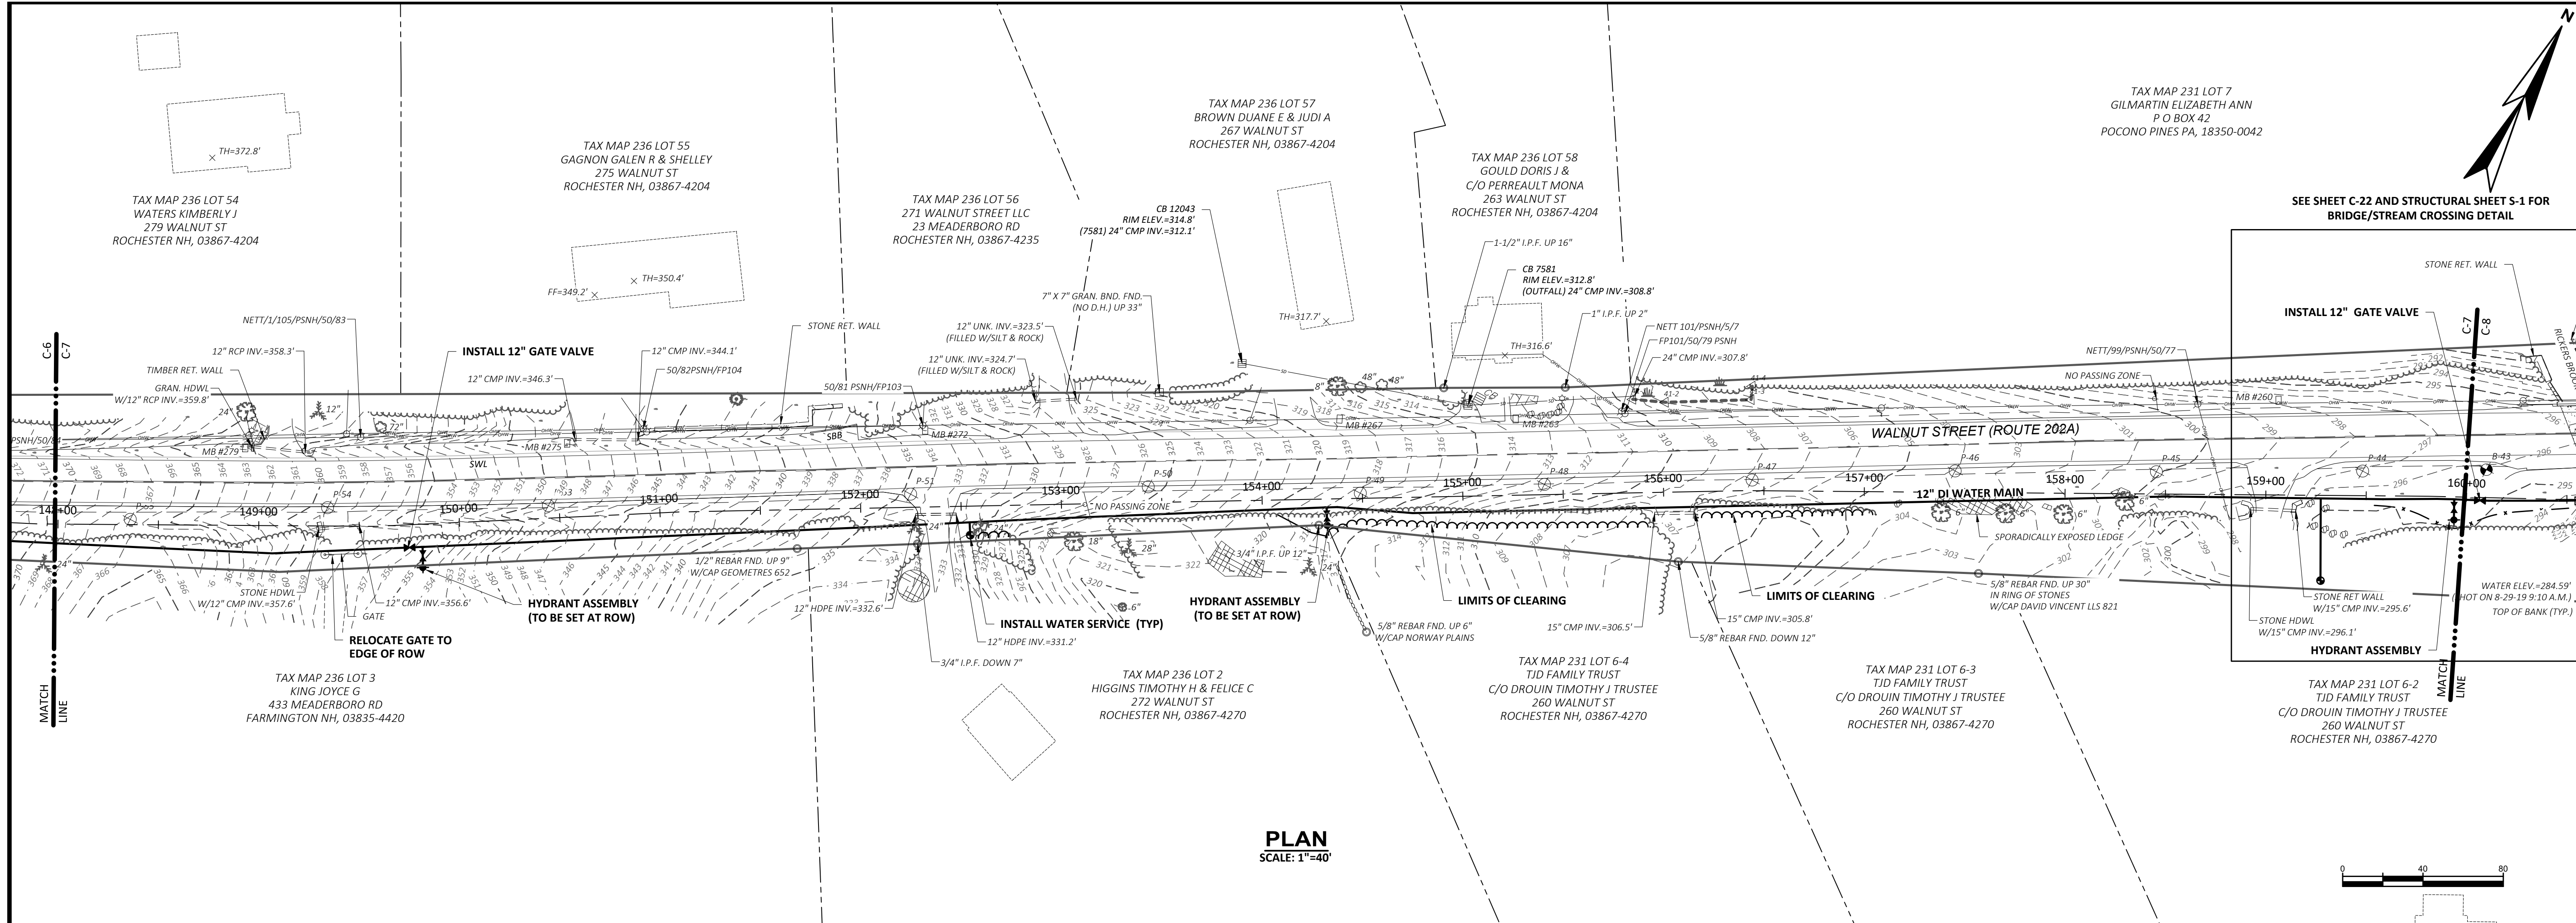

CONFORMED REFERENCE DRAWINGS NOVEMBER 2021: THE CONFORMED REFERENCE DOCUMENTS HAVE BEEN REVISED TO INCORPORATE CLARIFICATIONS AND/OR DRAWING AND SPECIFICATION CHANGES FROM THE PROJECT ADDENDUM IN ORDER TO CLARIFY AND ACCURATELY REFLECT THESE CLARIFICATIONS/CHANGES FOR CONFORMANCE AND REFERENCE. THE EXECUTED CONTRACT DOCUMENTS, INCLUDING THE ISSUED FOR BID DRAWINGS AND SPECIFICATIONS, AND ANY SUBSEQUENT ADDENDA SHALL BE THE BASIS FOR ALL ACCEPTED WORK UNDER THIS CONTRACT.					
CITY OF ROCHESTER, NEW HAMPSHIRE	 WRIGHT-PIERCE Engineering a Better Environment 888.621.8156 www.wright-pierce.com			DESIGNED BY: A.MAR CAD COORD.: WJ.EDG CAD: WJ.EDG CHECKED BY: D.LAR DATE: 05-21 APPROVED BY: D.THI DATE: 05-21 PROJECT NO.: 14Z06B	
ROUTE 202A WATER MAIN EXTENSION & WATER STORAGE TANK ROCHESTER, NEW HAMPSHIRE				NO CONTRACT DRAWINGS	
DRAWING C-7				PLAN AND PROFILE V WALNUT STREET (ROUTE 202A) STA. 148+00 TO STA. 160+00	
				SUBMISSIONS/REVISIONS	
				APP'D DATE	
				D.THI 08-21	

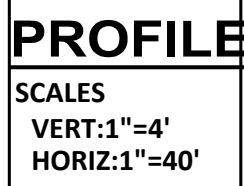[illegible]

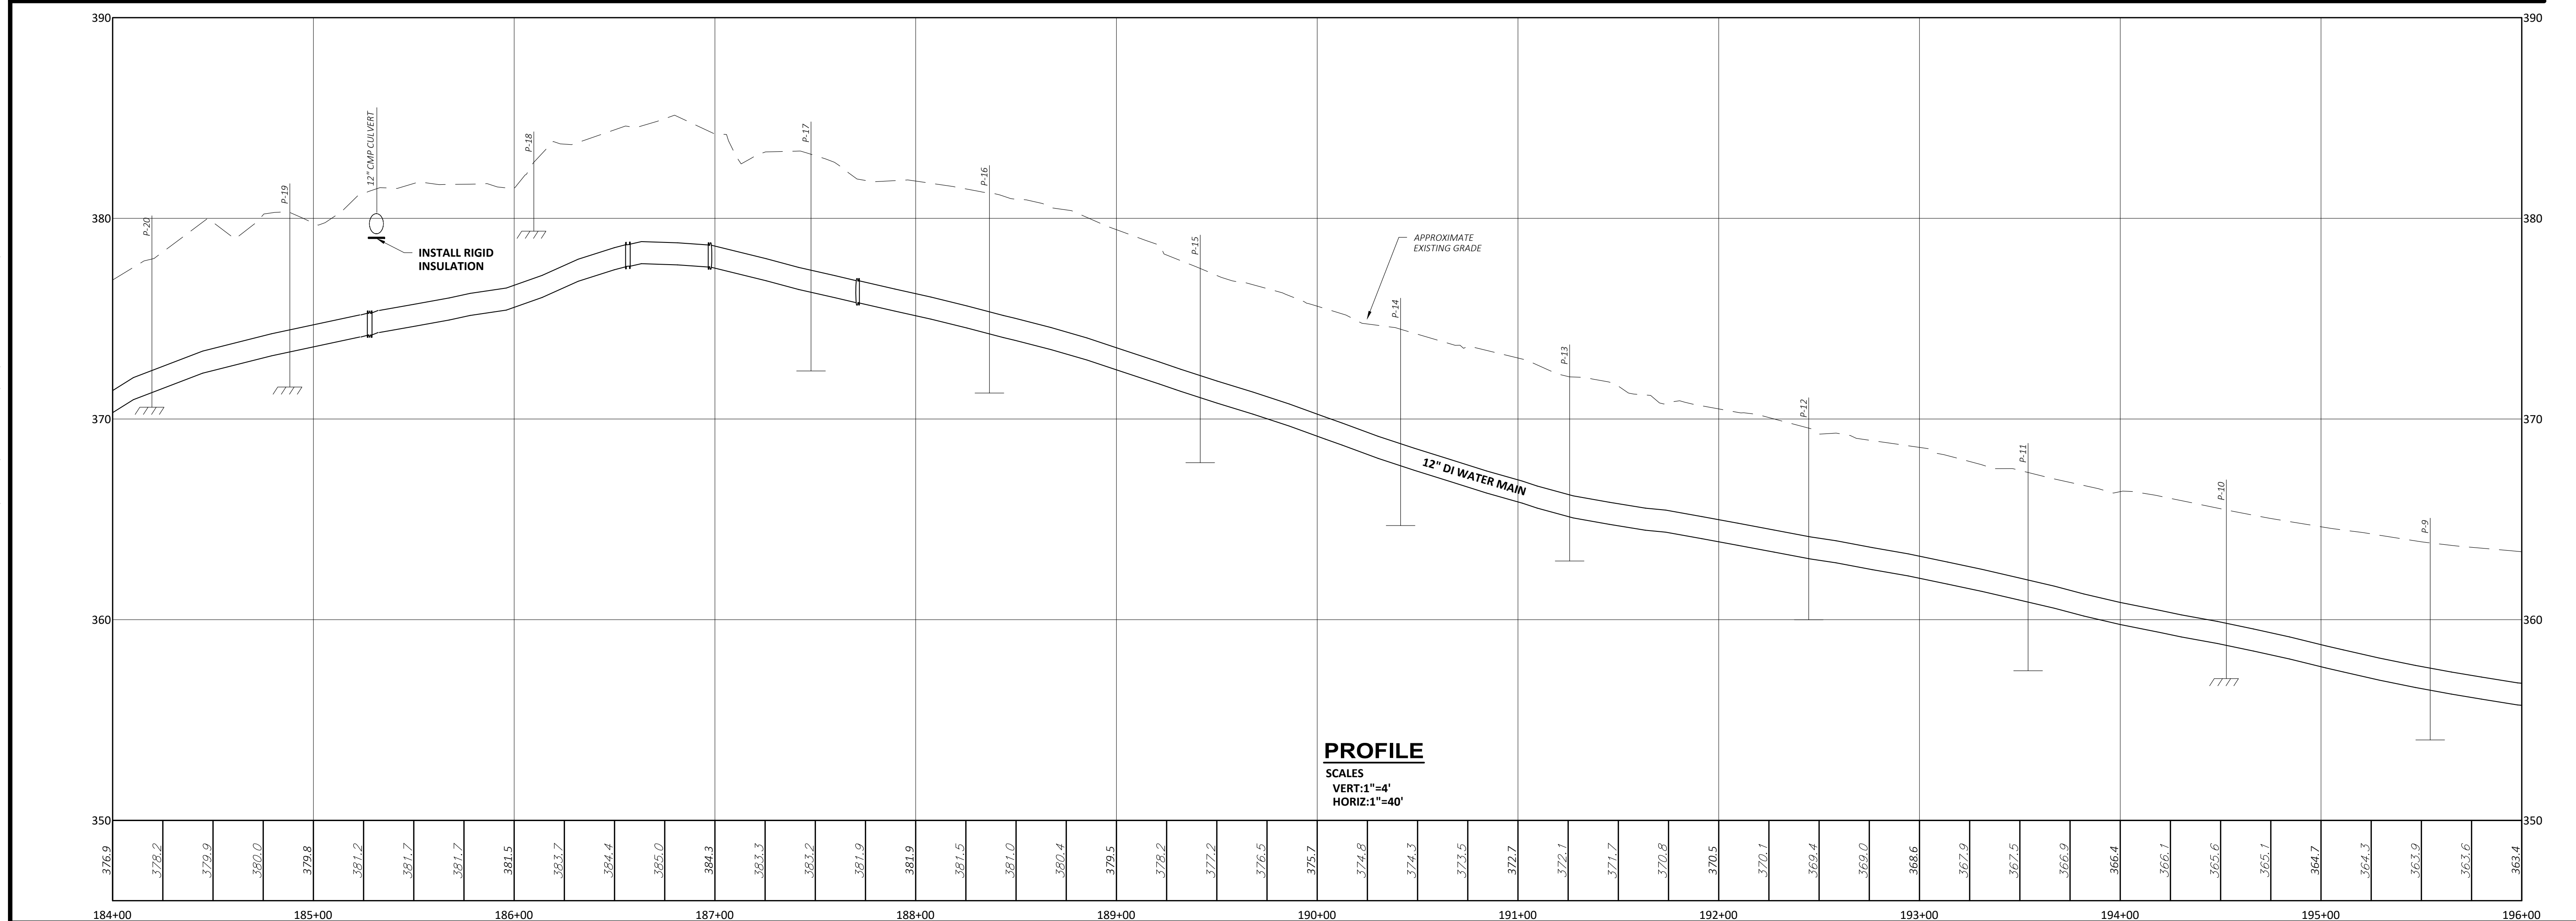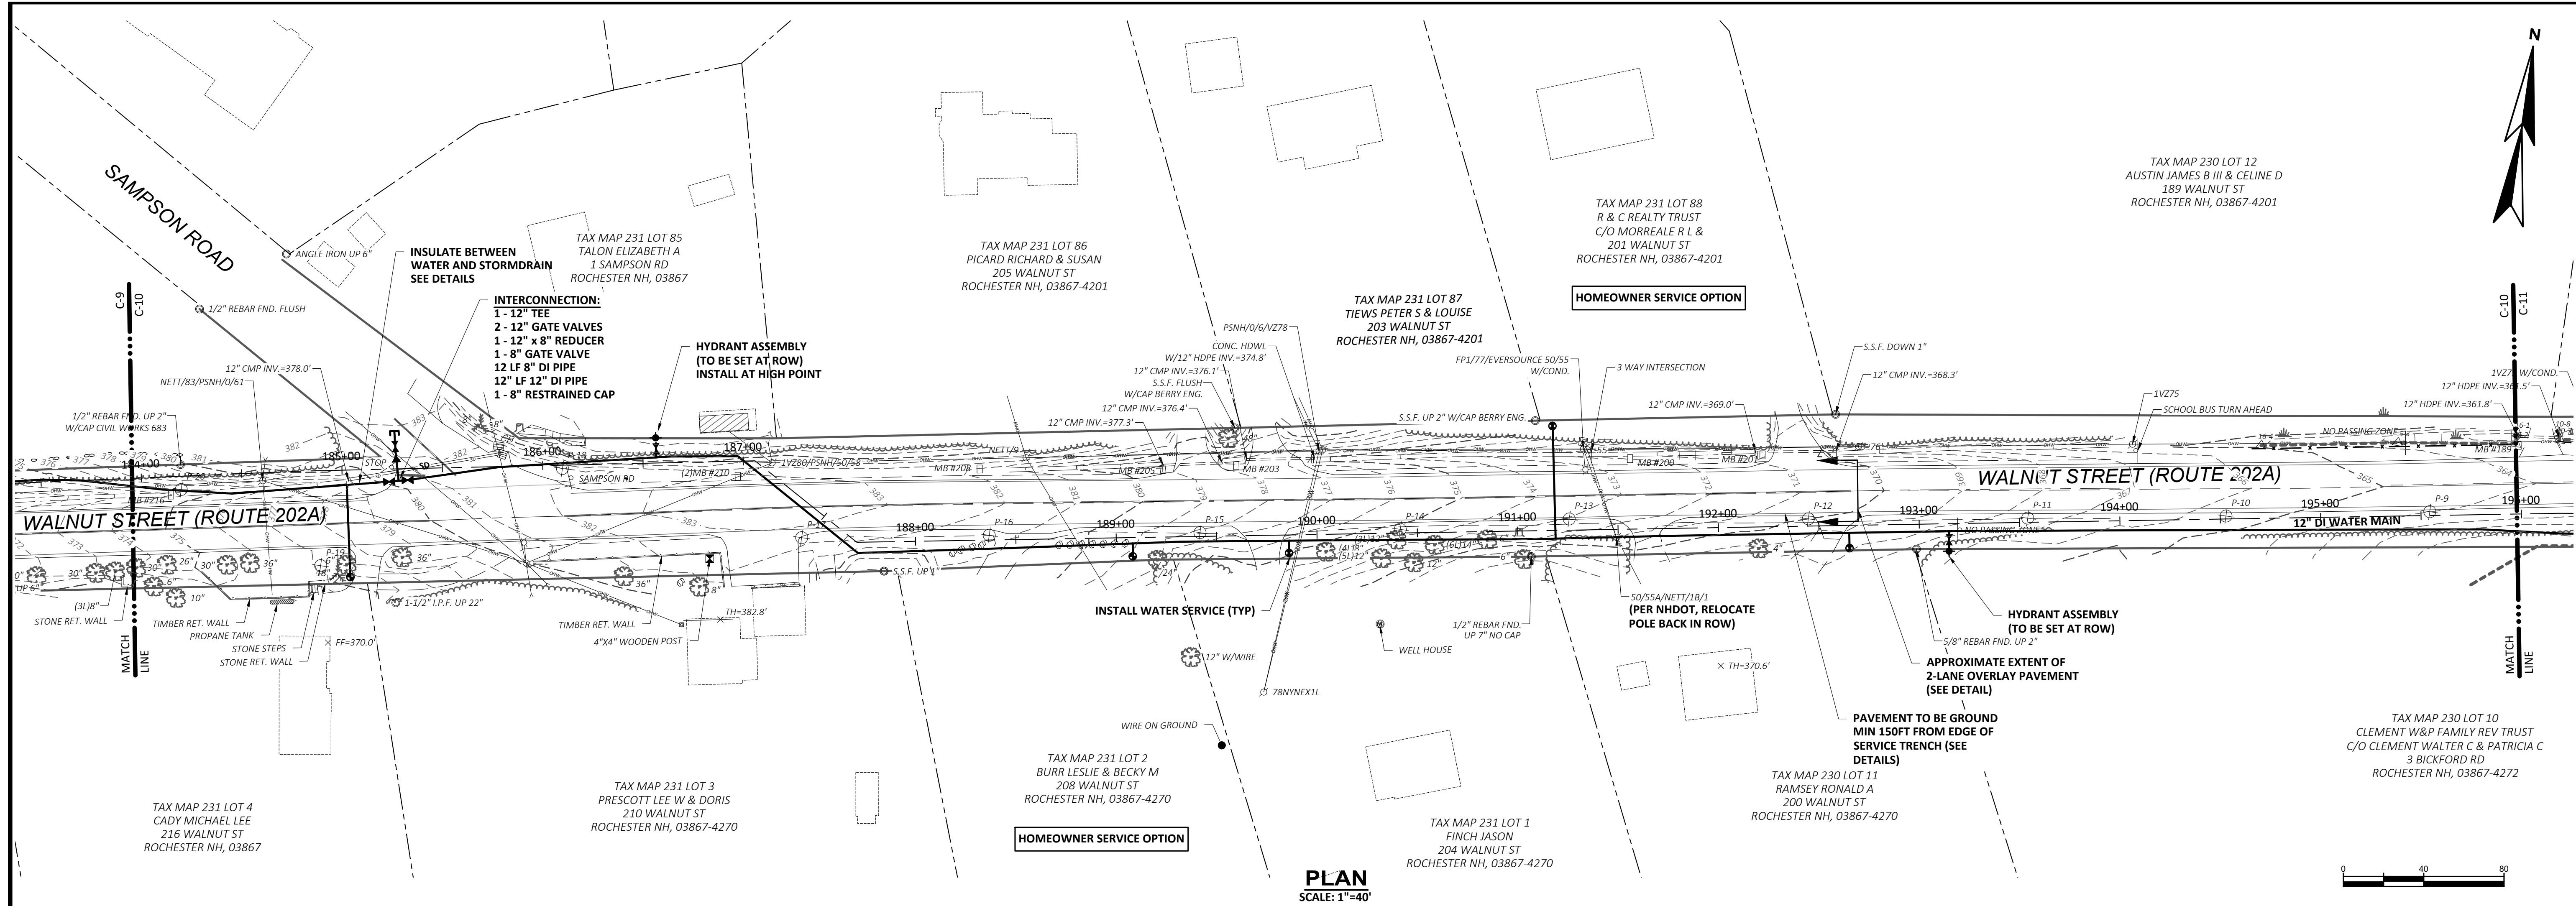[illegible]

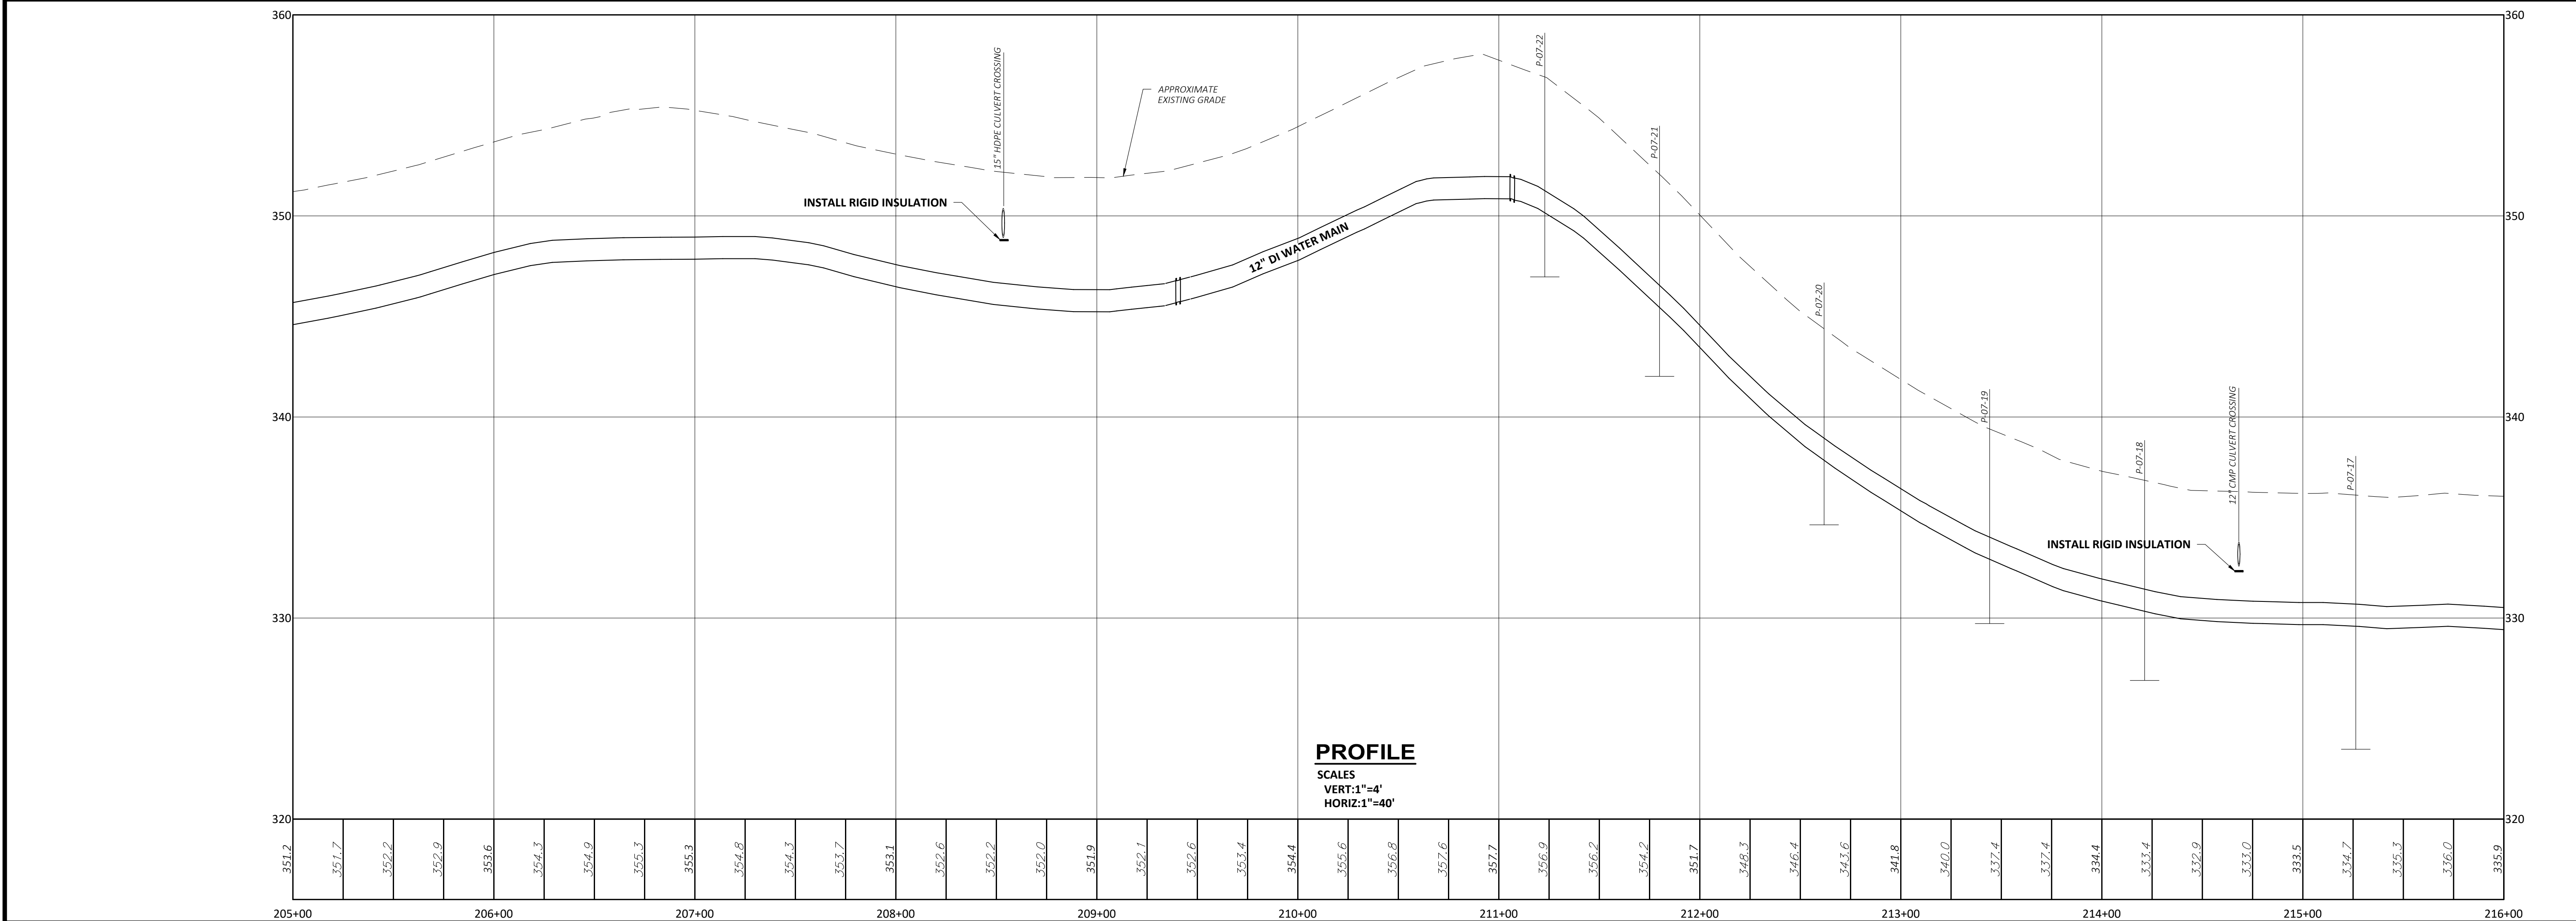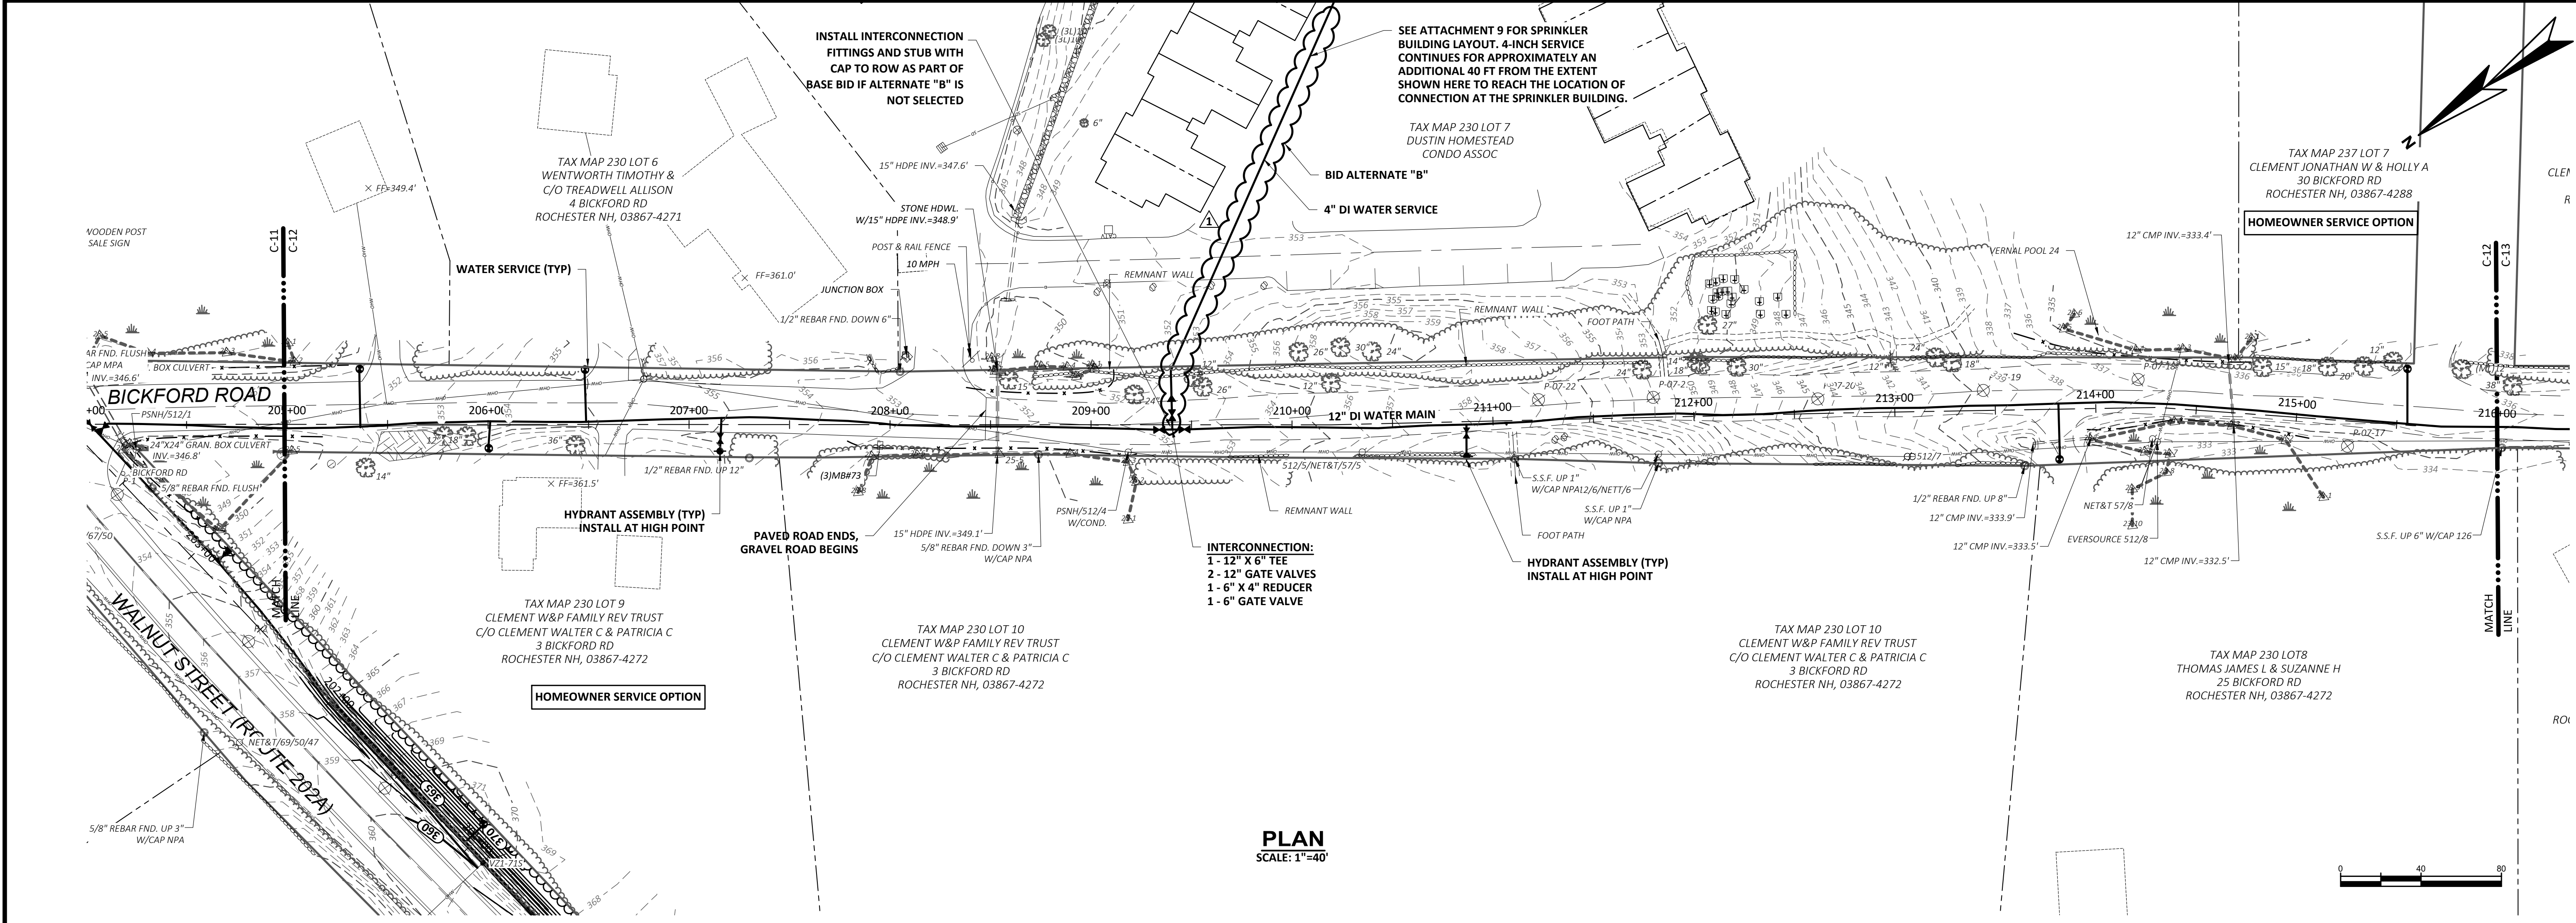



CONTRACT DRAWINGS		SUBMISSIONS/REVISIONS	
NO	DESCRIPTION	NO	DESCRIPTION
1	ADDENDUM 1	1	DESIGNED BY: A.MAR
2		2	CAD CORP.: W.EDG
3		3	CAD: W.EDG
4		4	CHECKED BY: D.LAR
5		5	DATE: 05-21
6		6	APPROVED BY: D.THI
7		7	DATE: 05-21
8		8	PROJECT NO.: 14206B

CITY OF ROCHESTER, NEW HAMPSHIRE
ROUTE 202A WATER MAIN EXTENSION & WATER STORAGE TANK
ROCHESTER, NEW HAMPSHIRE

DRAWING
C-12

WRIGHT-PIERCE
Engineering a Better Environment
888.621.8156 | www.wright-pierce.com

PLAN AND PROFILE X
BICKFORD ROAD
STA. 205+00 TO STA. 216+00

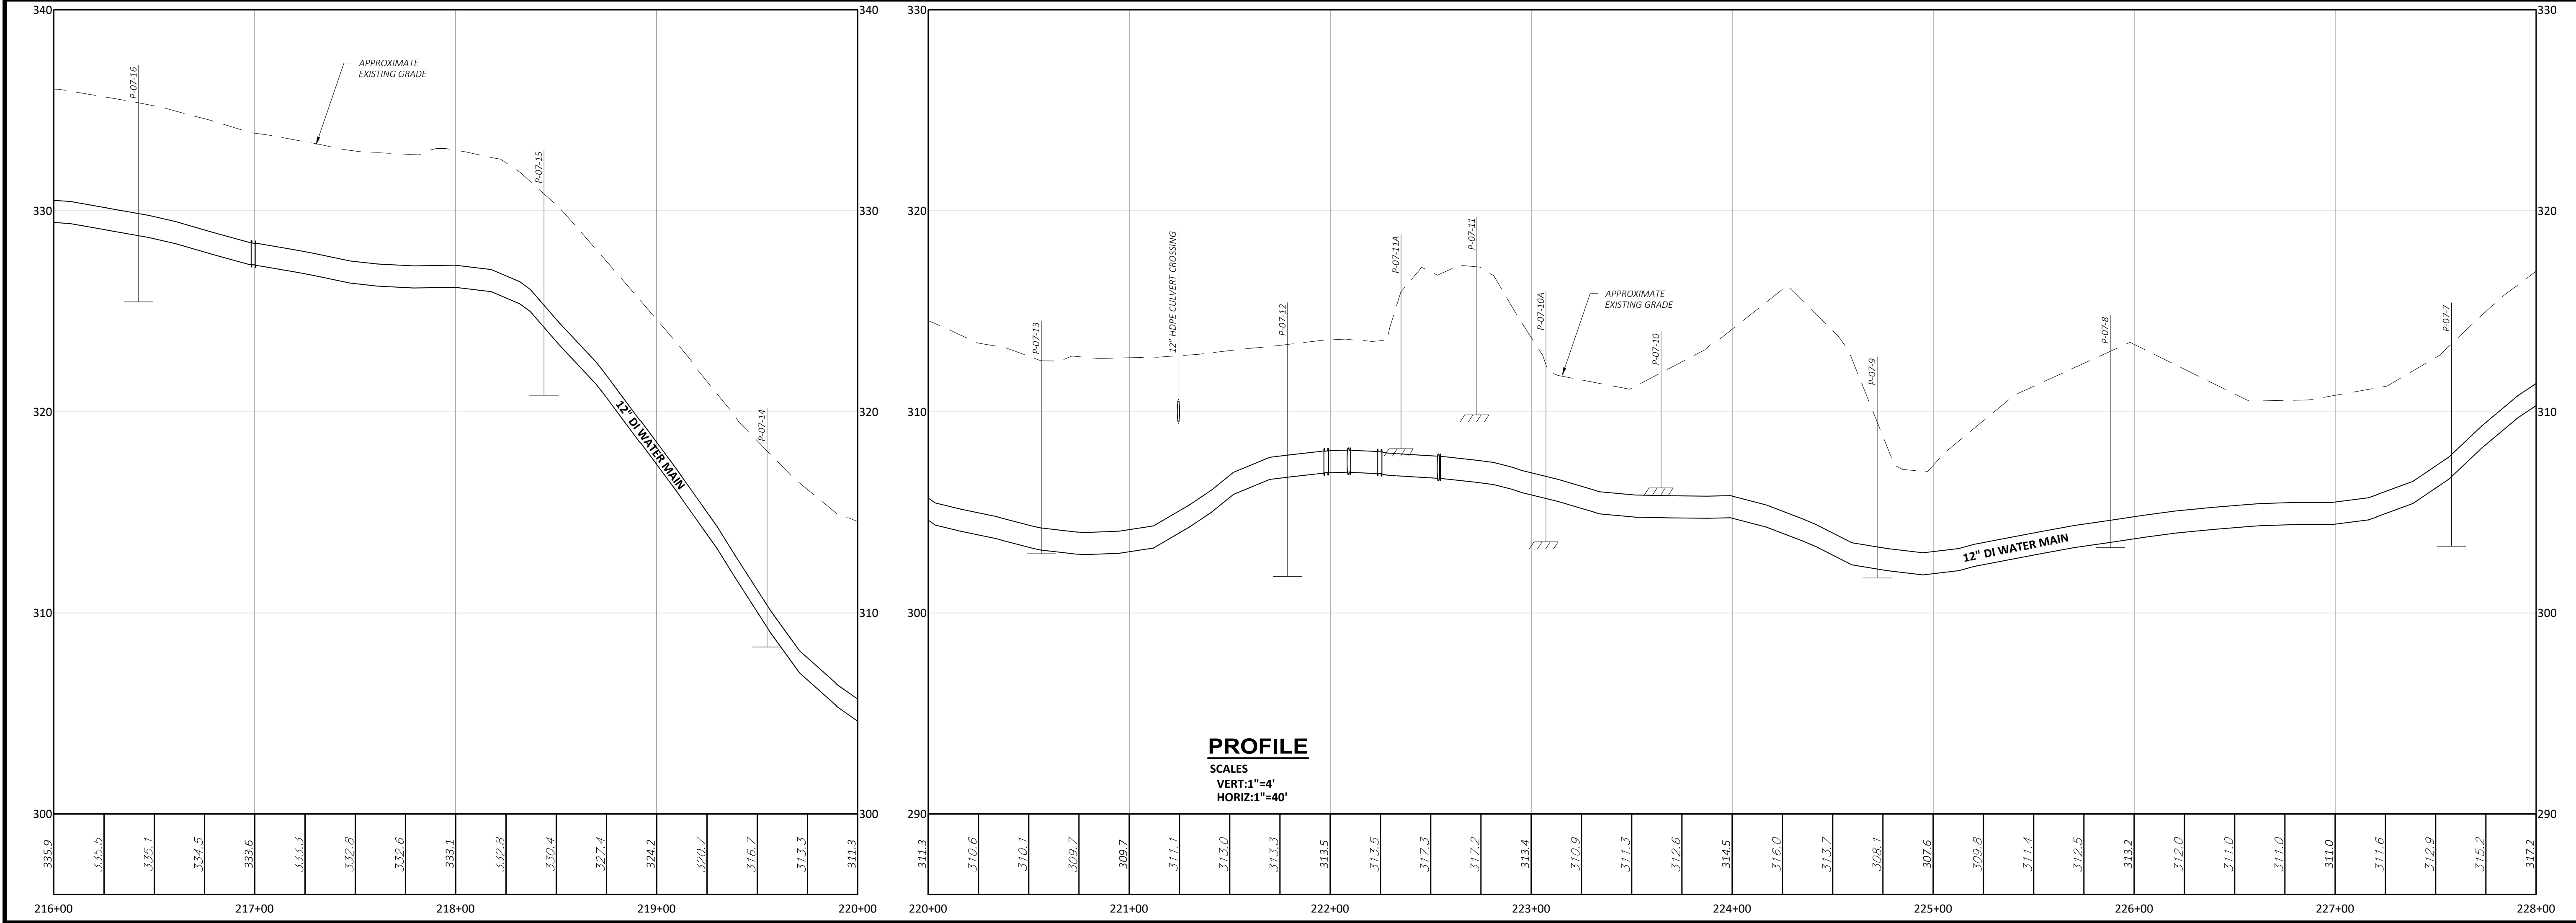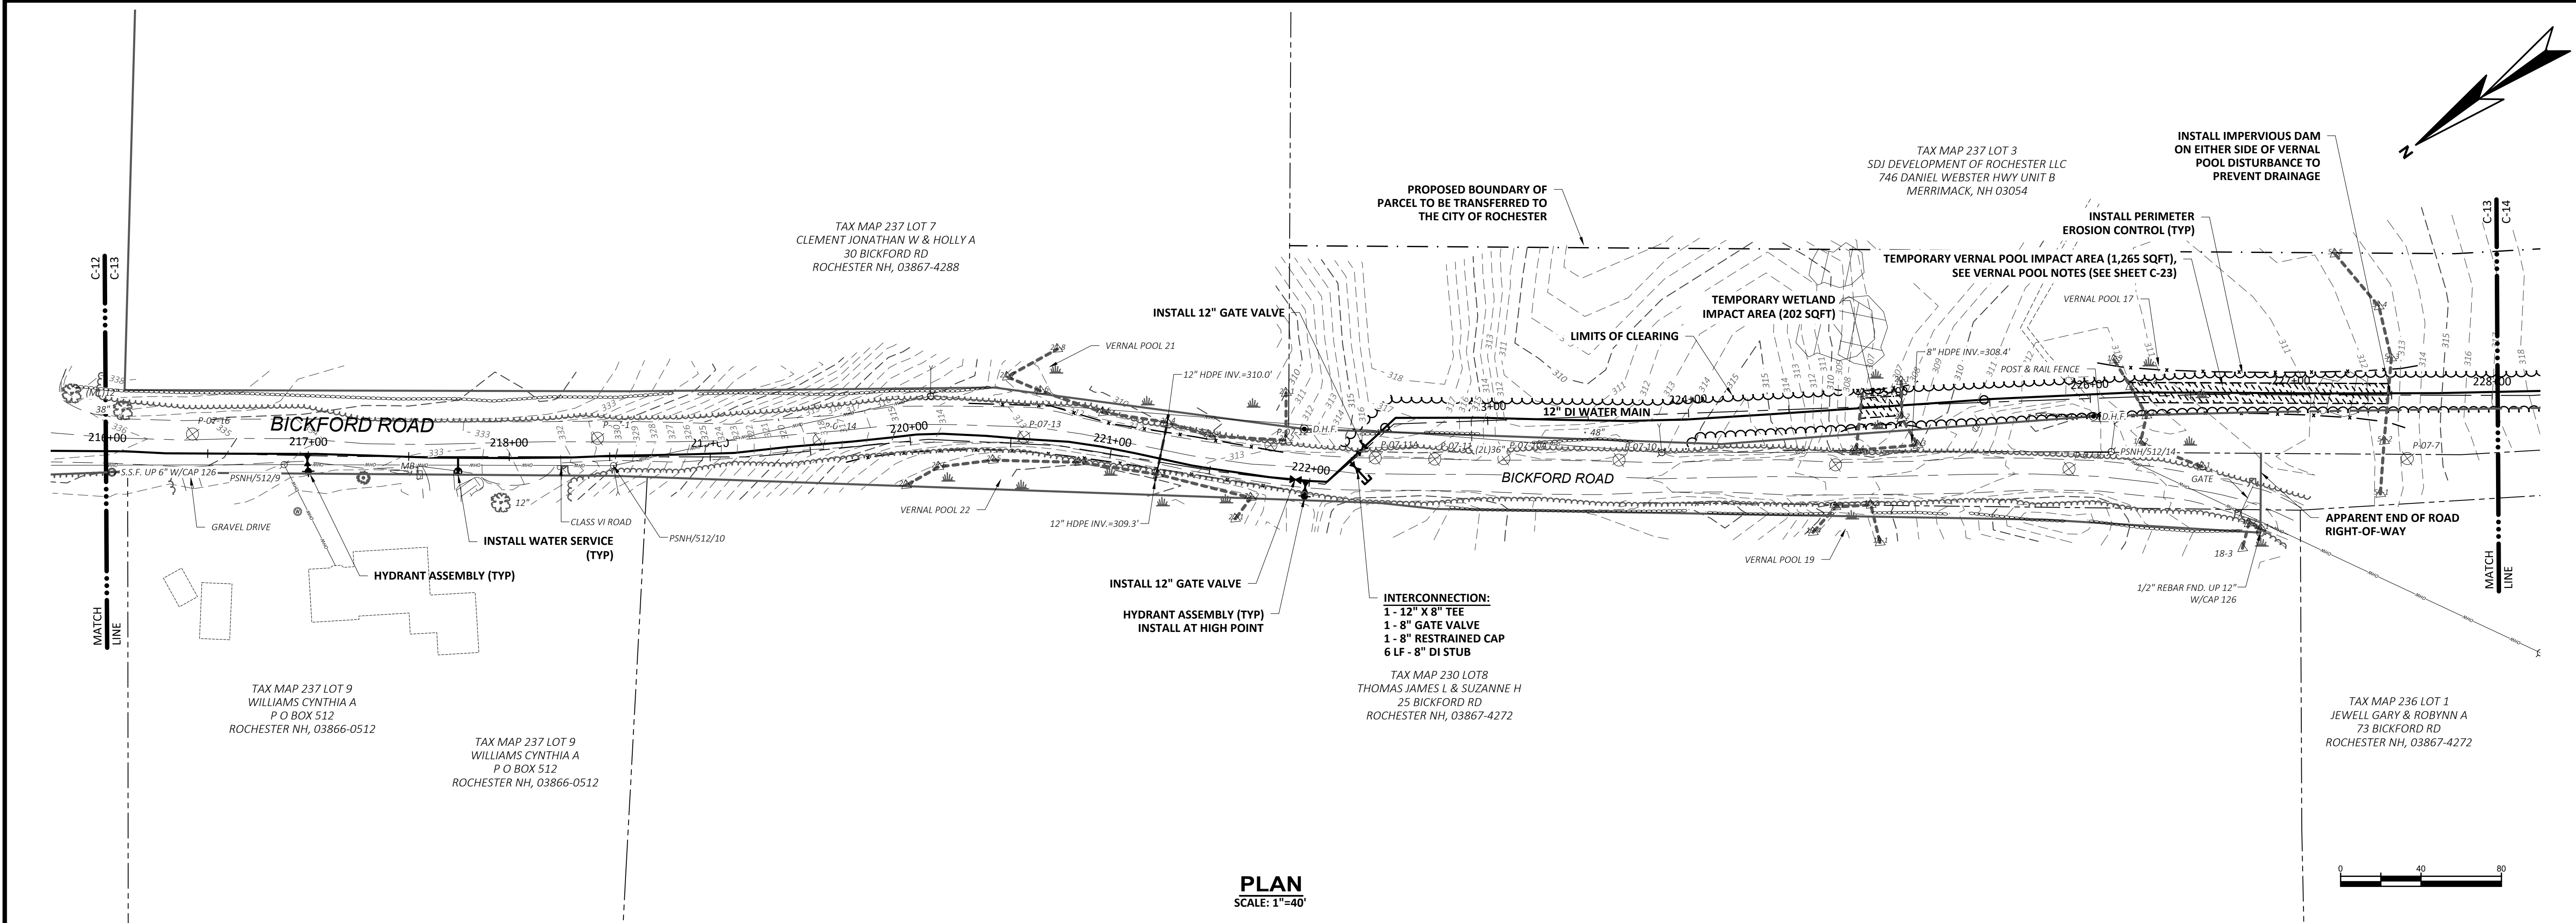





CONTRACT DRAWINGS		SUBMISSIONS/REVISIONS	
NO	DESCRIPTION	NO	DESCRIPTION
1	DESIGNED BY: A.MAR	1	DESIGNED BY: A.MAR
2	CAD CORP: W.EDG	2	CAD CORP: W.EDG
3	CAD: W.EDG	3	CAD: W.EDG
4	CHECKED BY: D.LAR	4	CHECKED BY: D.LAR
5	DATE: 05-21	5	DATE: 05-21
6	APPROVED BY: D.THI	6	APPROVED BY: D.THI
7	DATE: 05-21	7	DATE: 05-21
8	PROJECT NO: 14206B	8	PROJECT NO: 14206B

CITY OF ROCHESTER, NEW HAMPSHIRE
ROUTE 202A WATER MAIN EXTENSION & WATER STORAGE TANK
ROCHESTER, NEW HAMPSHIRE

DRAWING
C-13

WRIGHT-PIERCE
Engineering a Better Environment
888.621.8156 | www.wright-pierce.com

PLAN AND PROFILE XI
BICKFORD ROAD
STA. 216+00 TO STA. 228+00

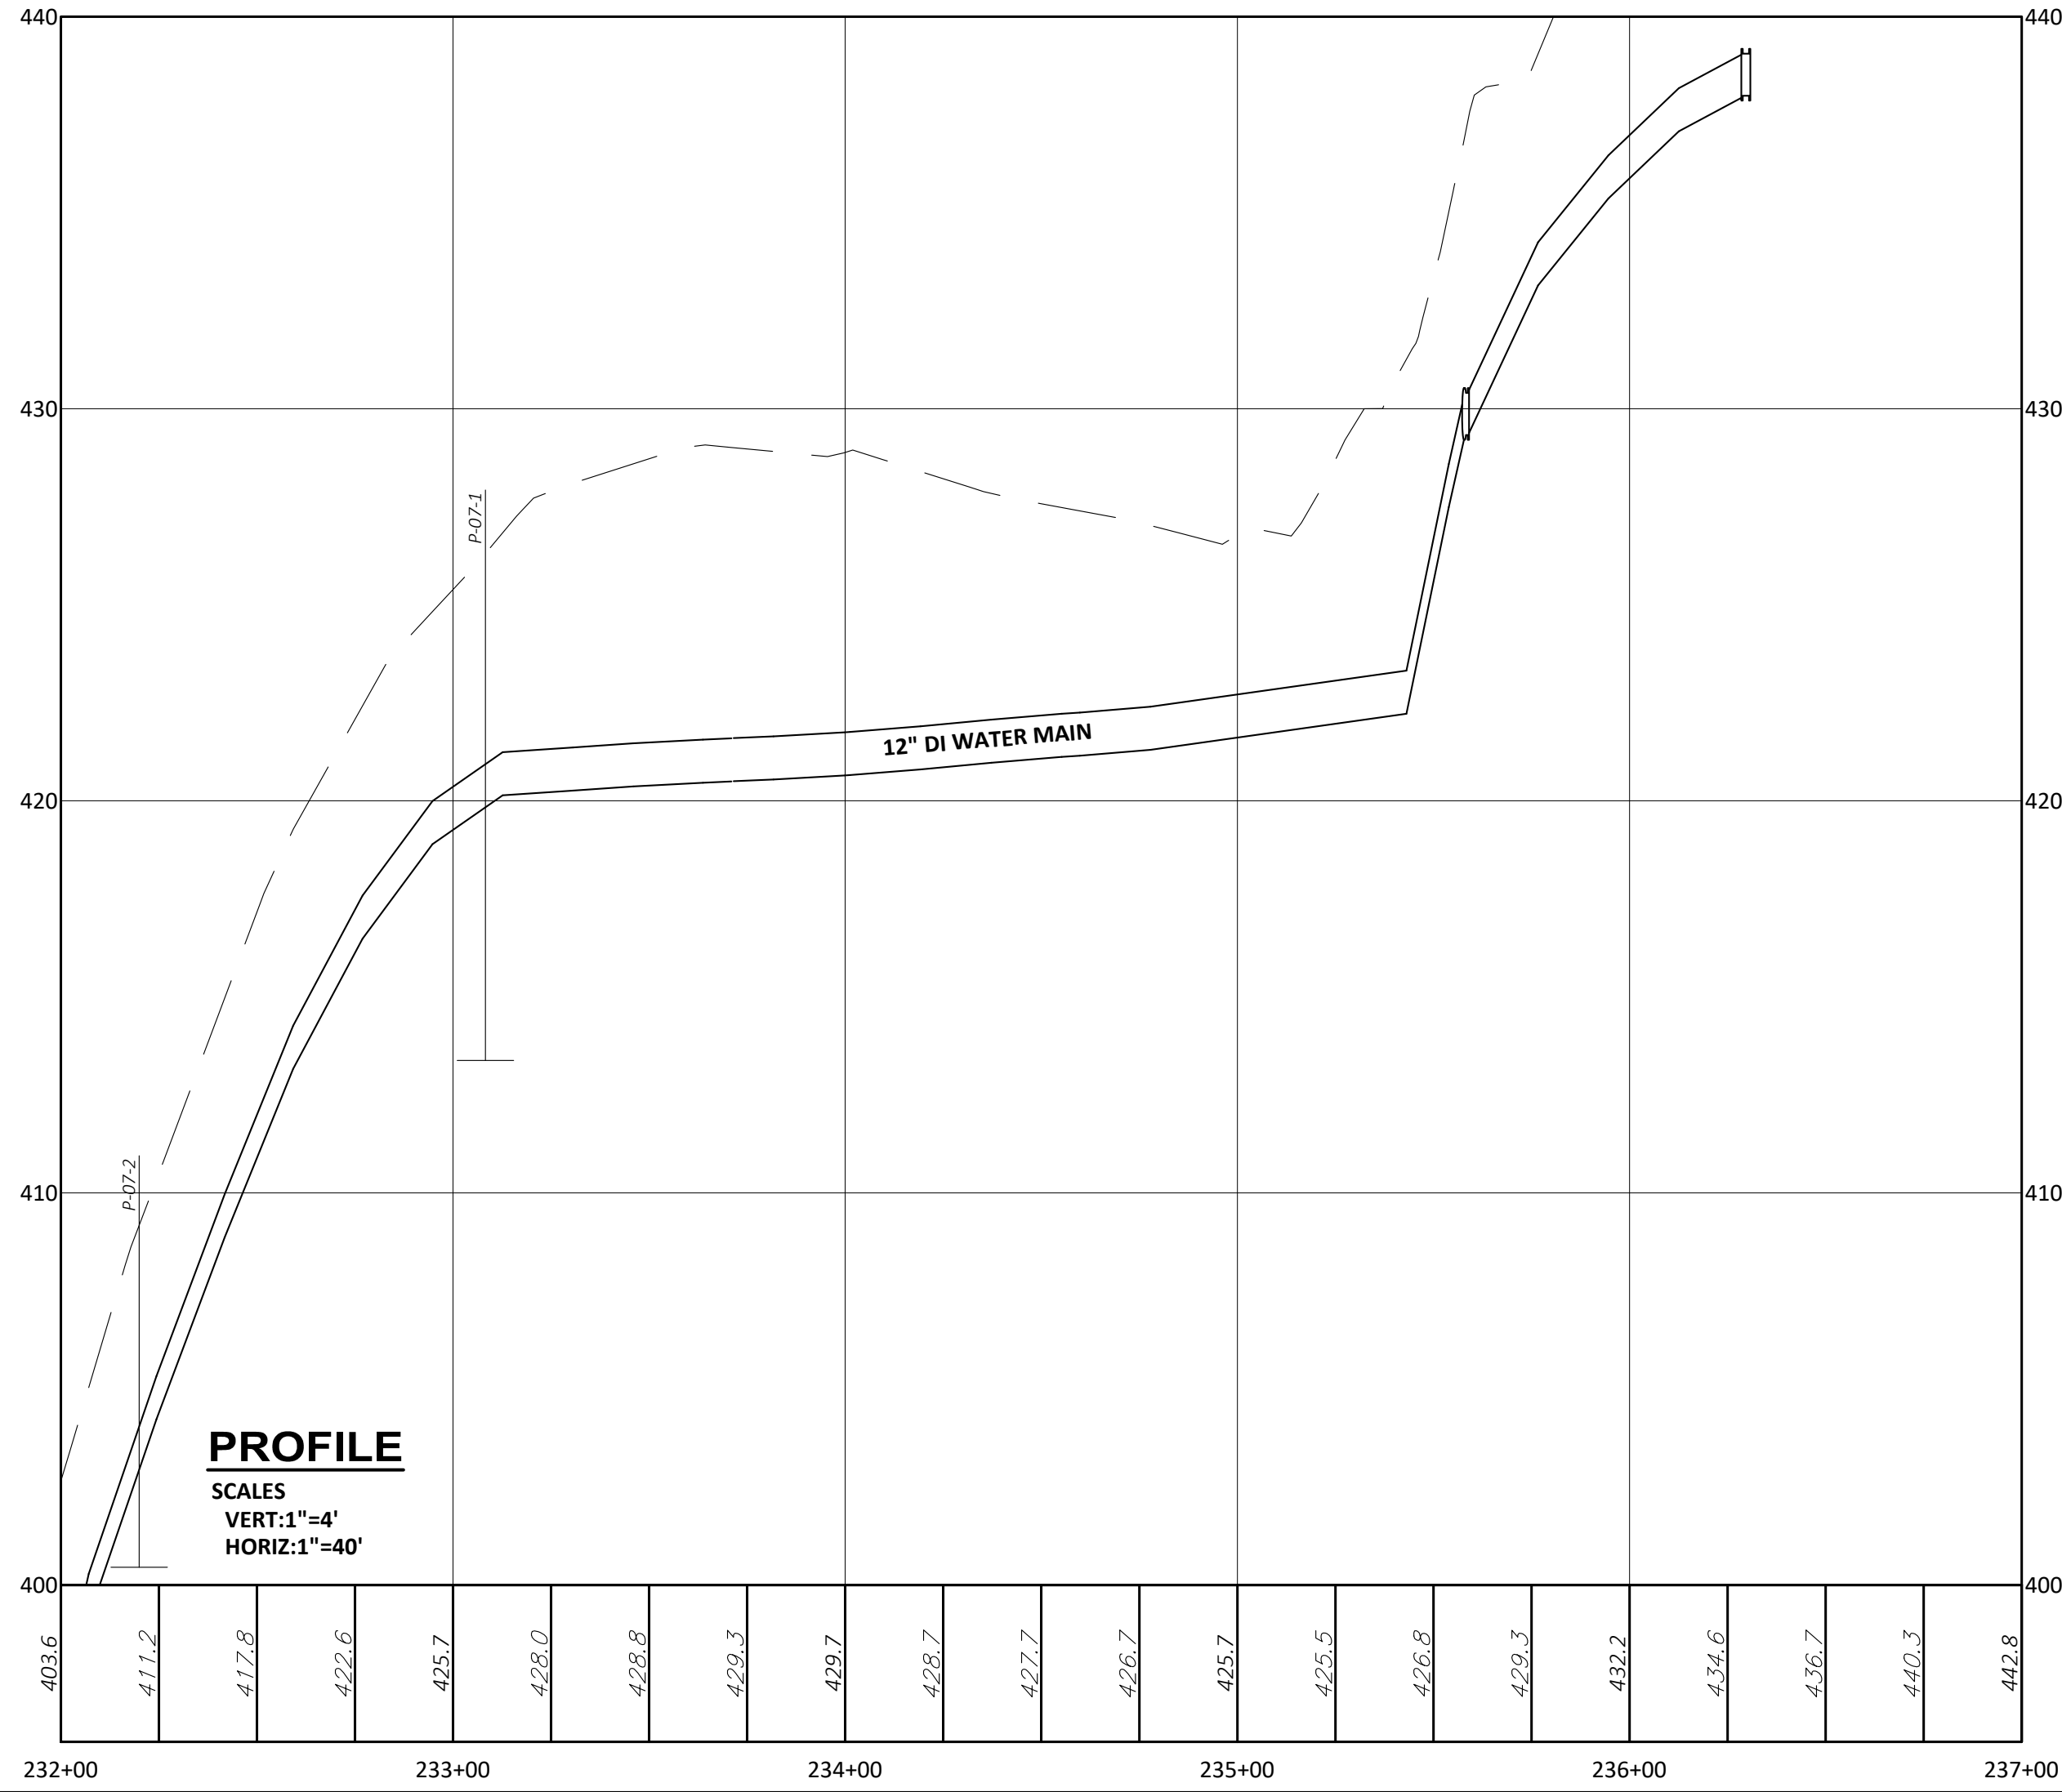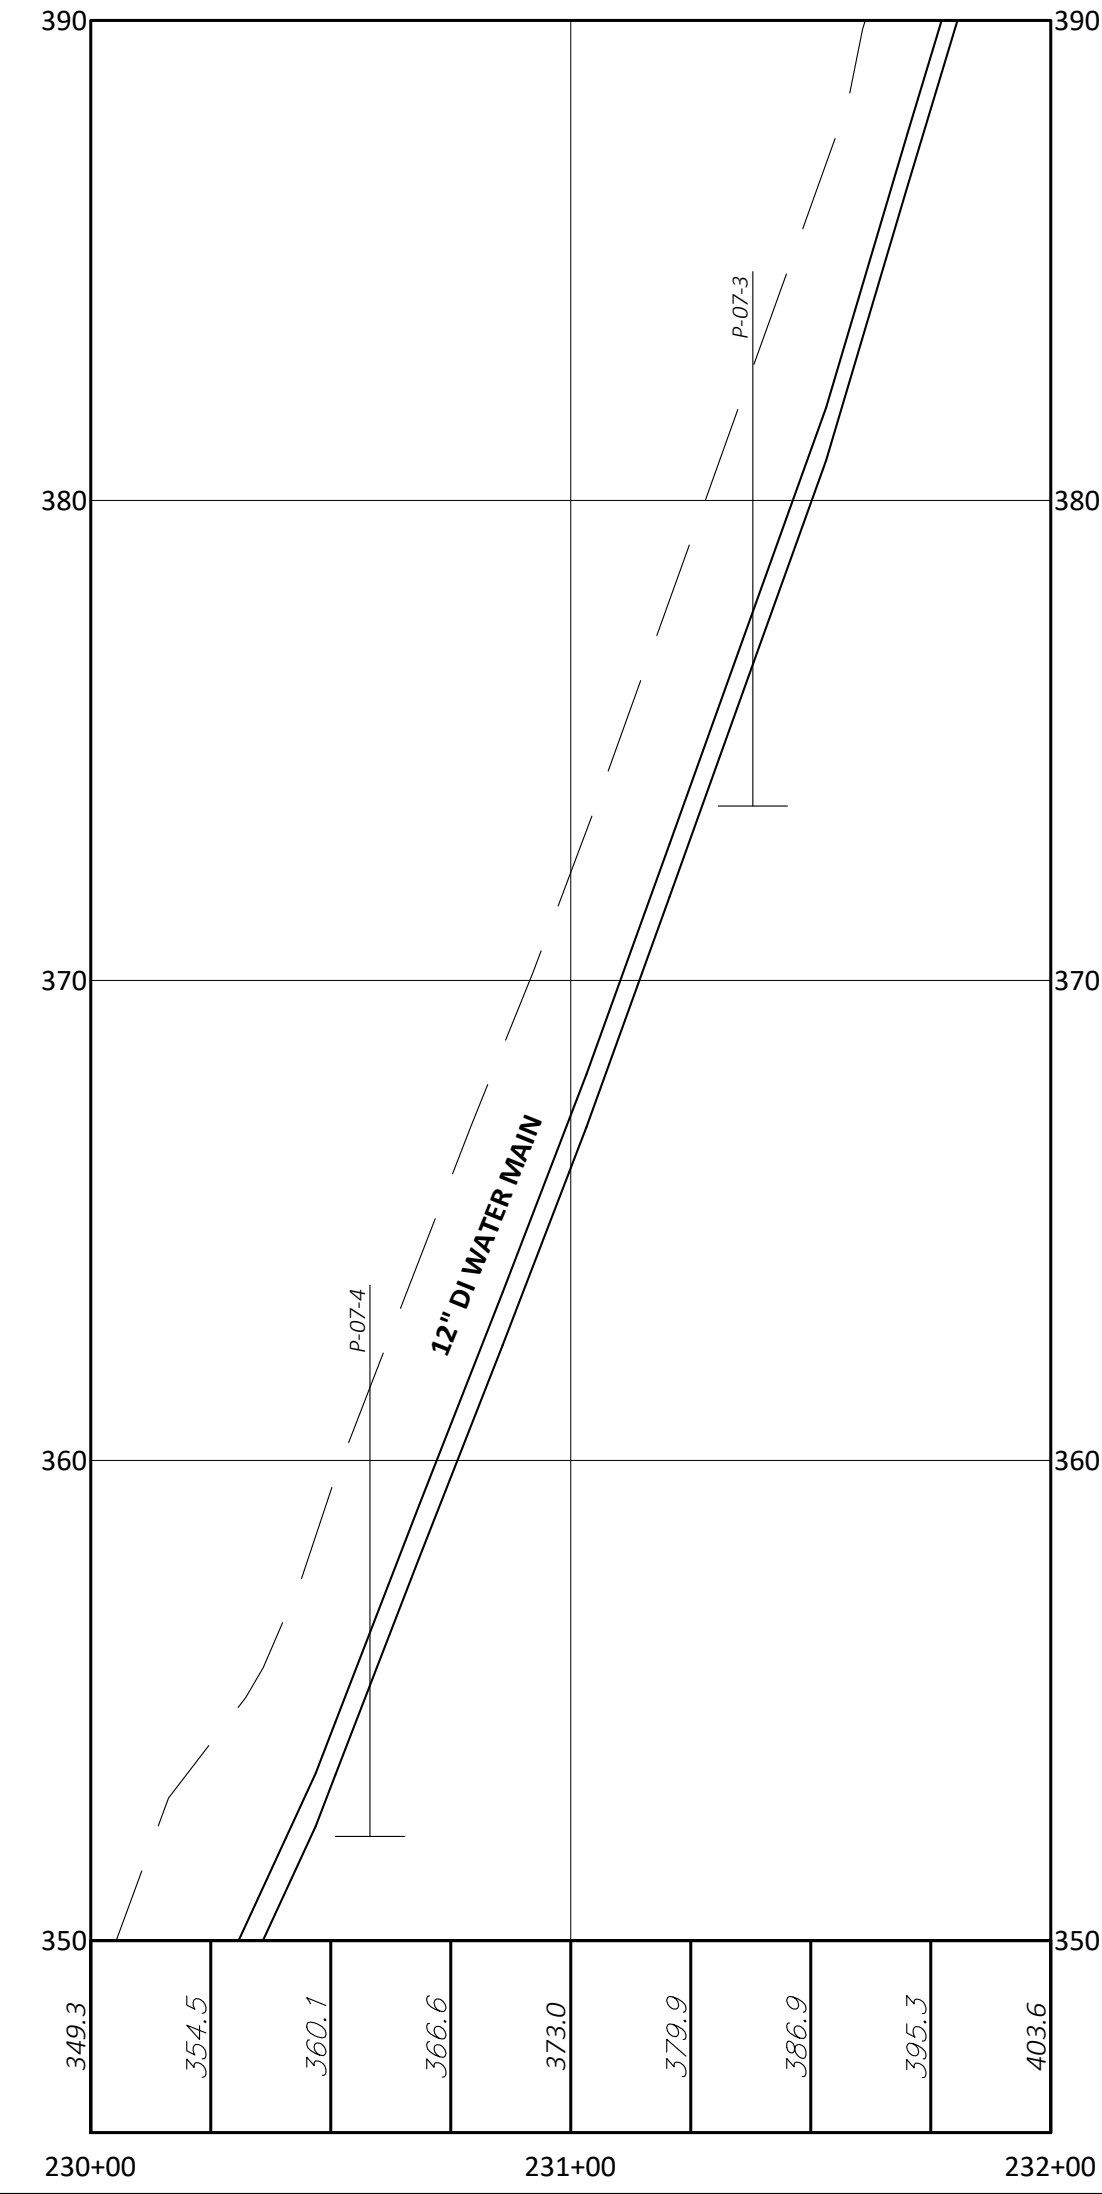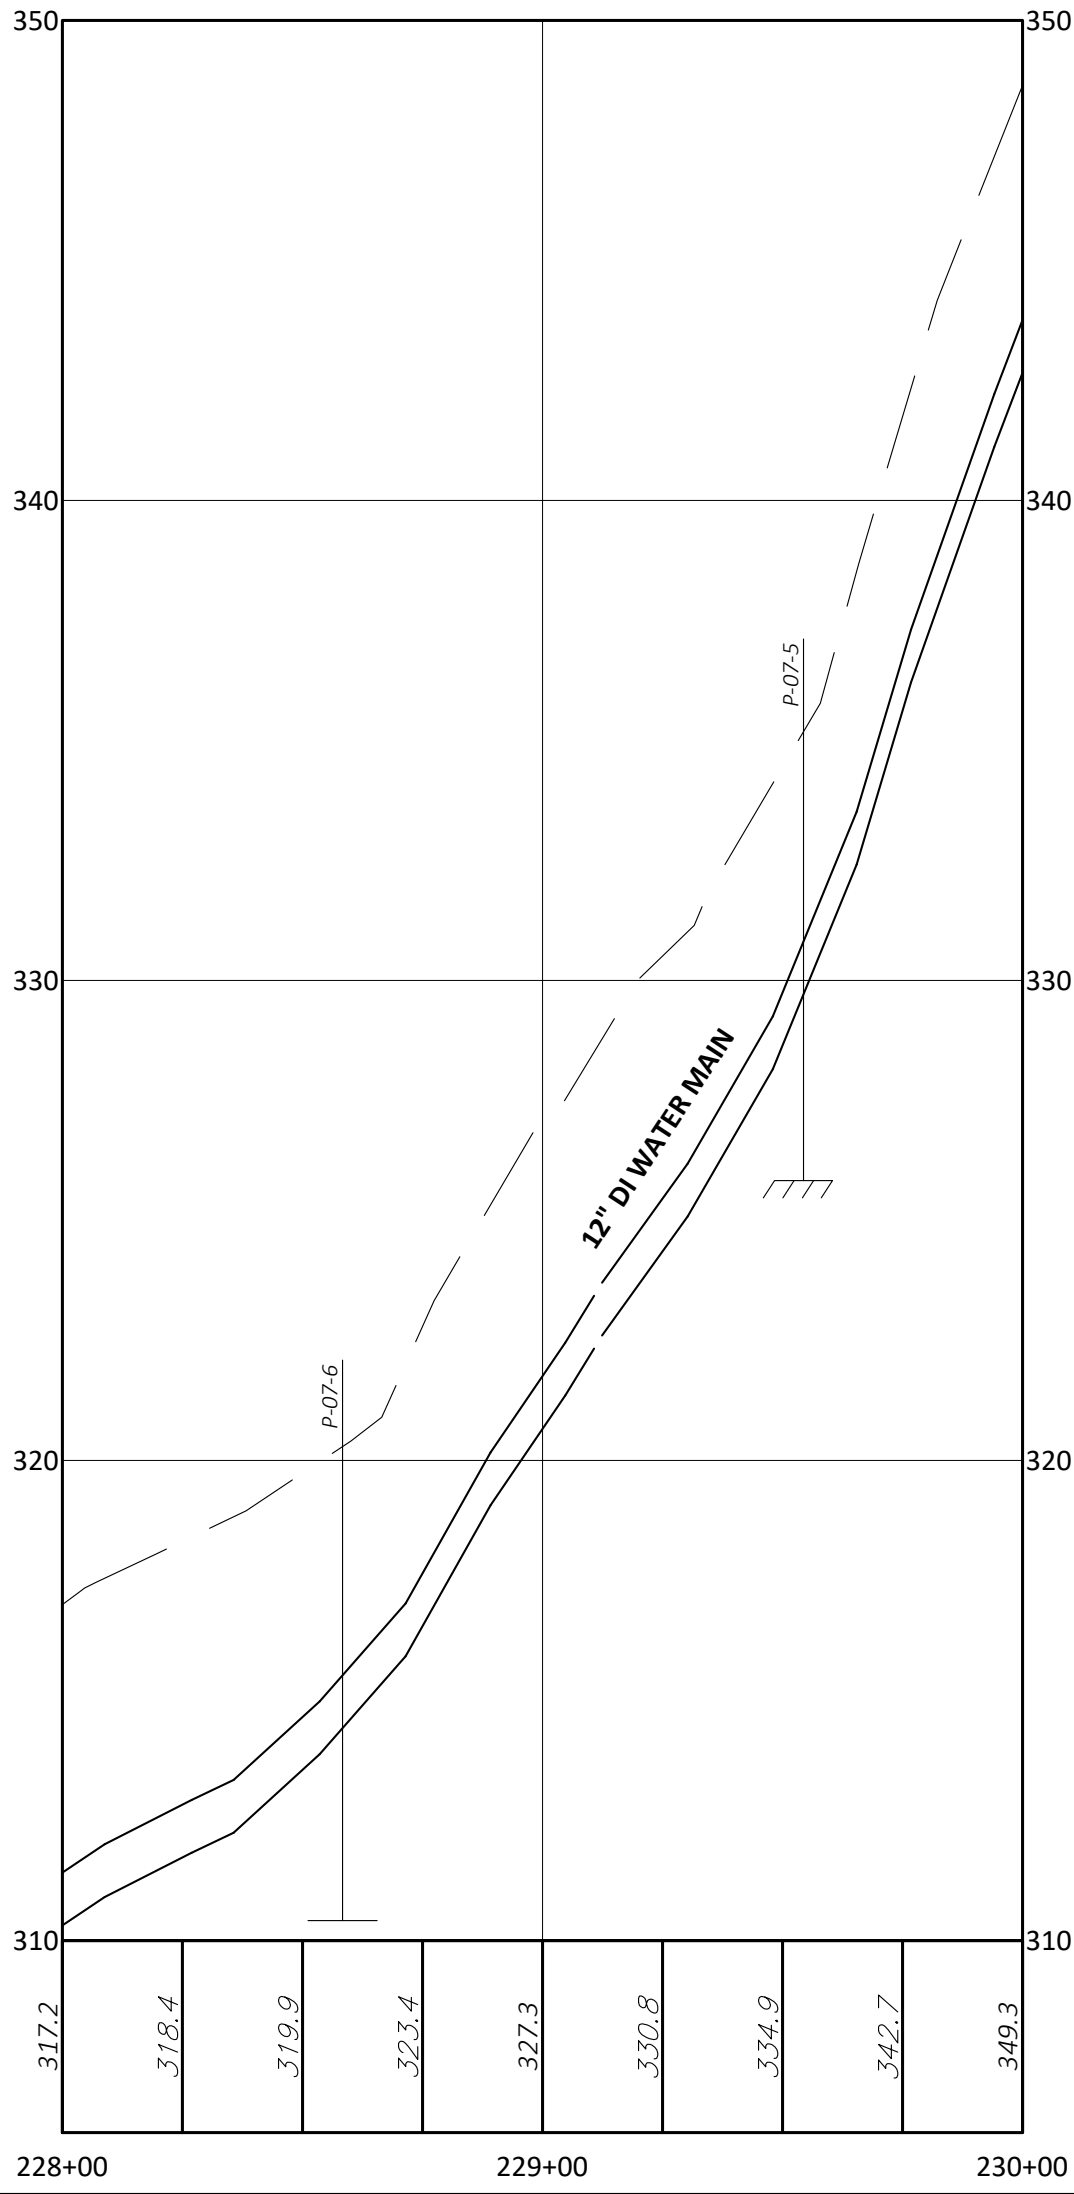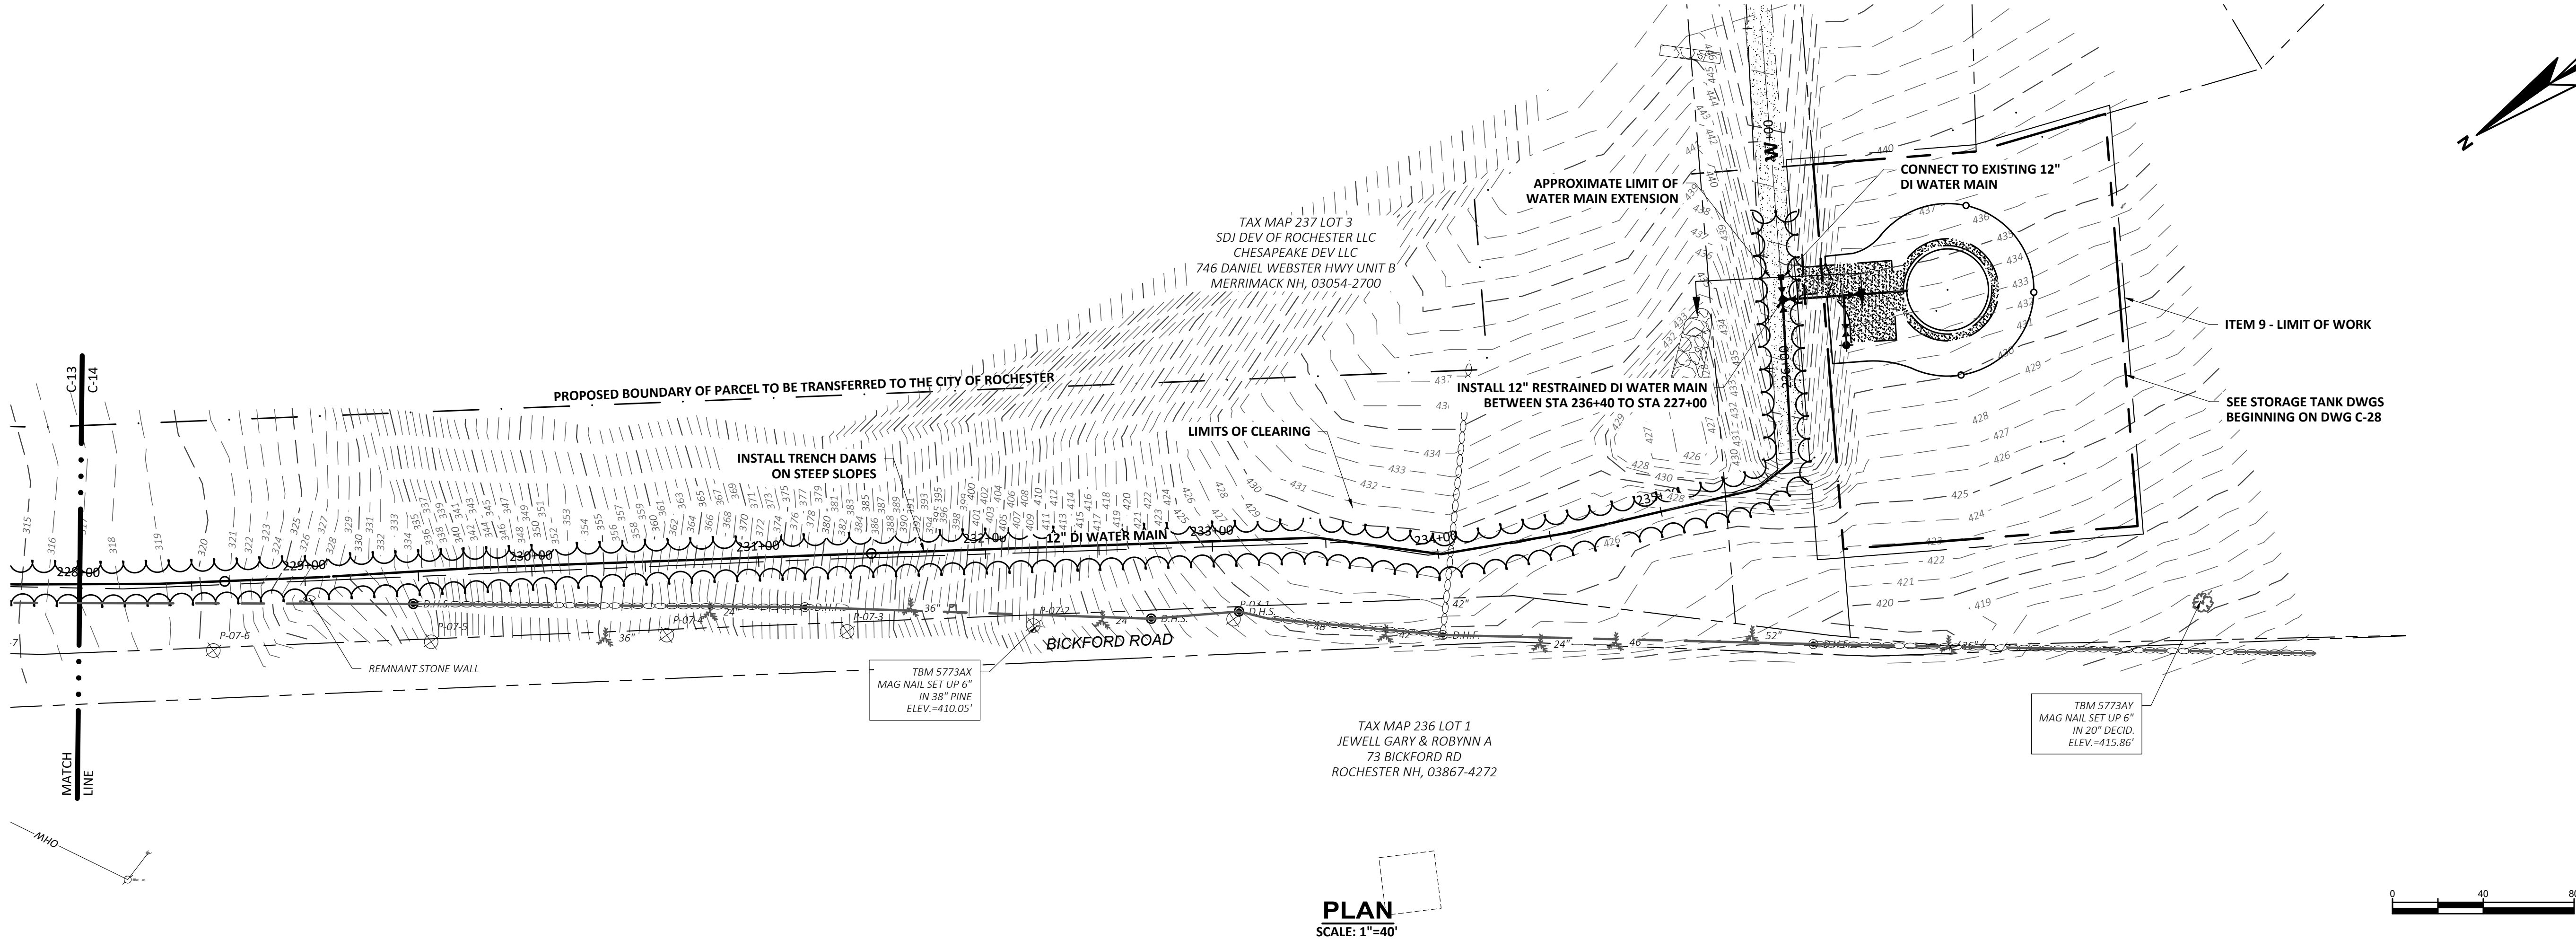

CITY OF ROCHESTER, NEW HAMPSHIRE

ROUTE 202A WATER MAIN EXTENSION & WATER STORAGE TANK

ROCHESTER, NEW HAMPSHIRE

PLAN AND PROFILE XII

BICKFORD ROAD TO HIGHFIELDS SUBDIVISION

STA. 228+00 TO STA. 236+40

DRAWING

C-14

WRIGHT-PIERCE

Engineering a Better Environment

888.621.8156 | www.wright-pierce.com

DESIGNED BY: A.MAR

CAD CORP.: W.EDG

CAD: W.EDG

CHECKED BY: D.LAR

DATE: 05-21

APPROVED BY: D.THI

DATE: 05-21

PROJECT NO.: 14206B

NO



CONTRACT DRAWINGS

SUBMISSIONS/REVISIONS

APP'D DATE

D.THI 08-21

CONFORMS REFERENCE CHANGES NOVEMBER 2021. THE CONTRACTOR DEFENDS DOCUMENTS HAVE BEEN REVIEWED TO INCORPORATE CLARIFICATIONS AND FOR DRAWING AND SPECIFICATION CHANGES FROM THE PROJECT DESIGNER IN ORDER TO CLARIFY AND ACCURATELY REFLECT THE CONTRACTOR'S CHANGES FOR CONFORMANCE AND REFERENCE. THE CONTRACTOR'S CHANGES FOR CONFORMANCE AND REFERENCE SHALL BE THE BASIS FOR ALL ACCEPTED WORK UNDER THE CONTRACT.

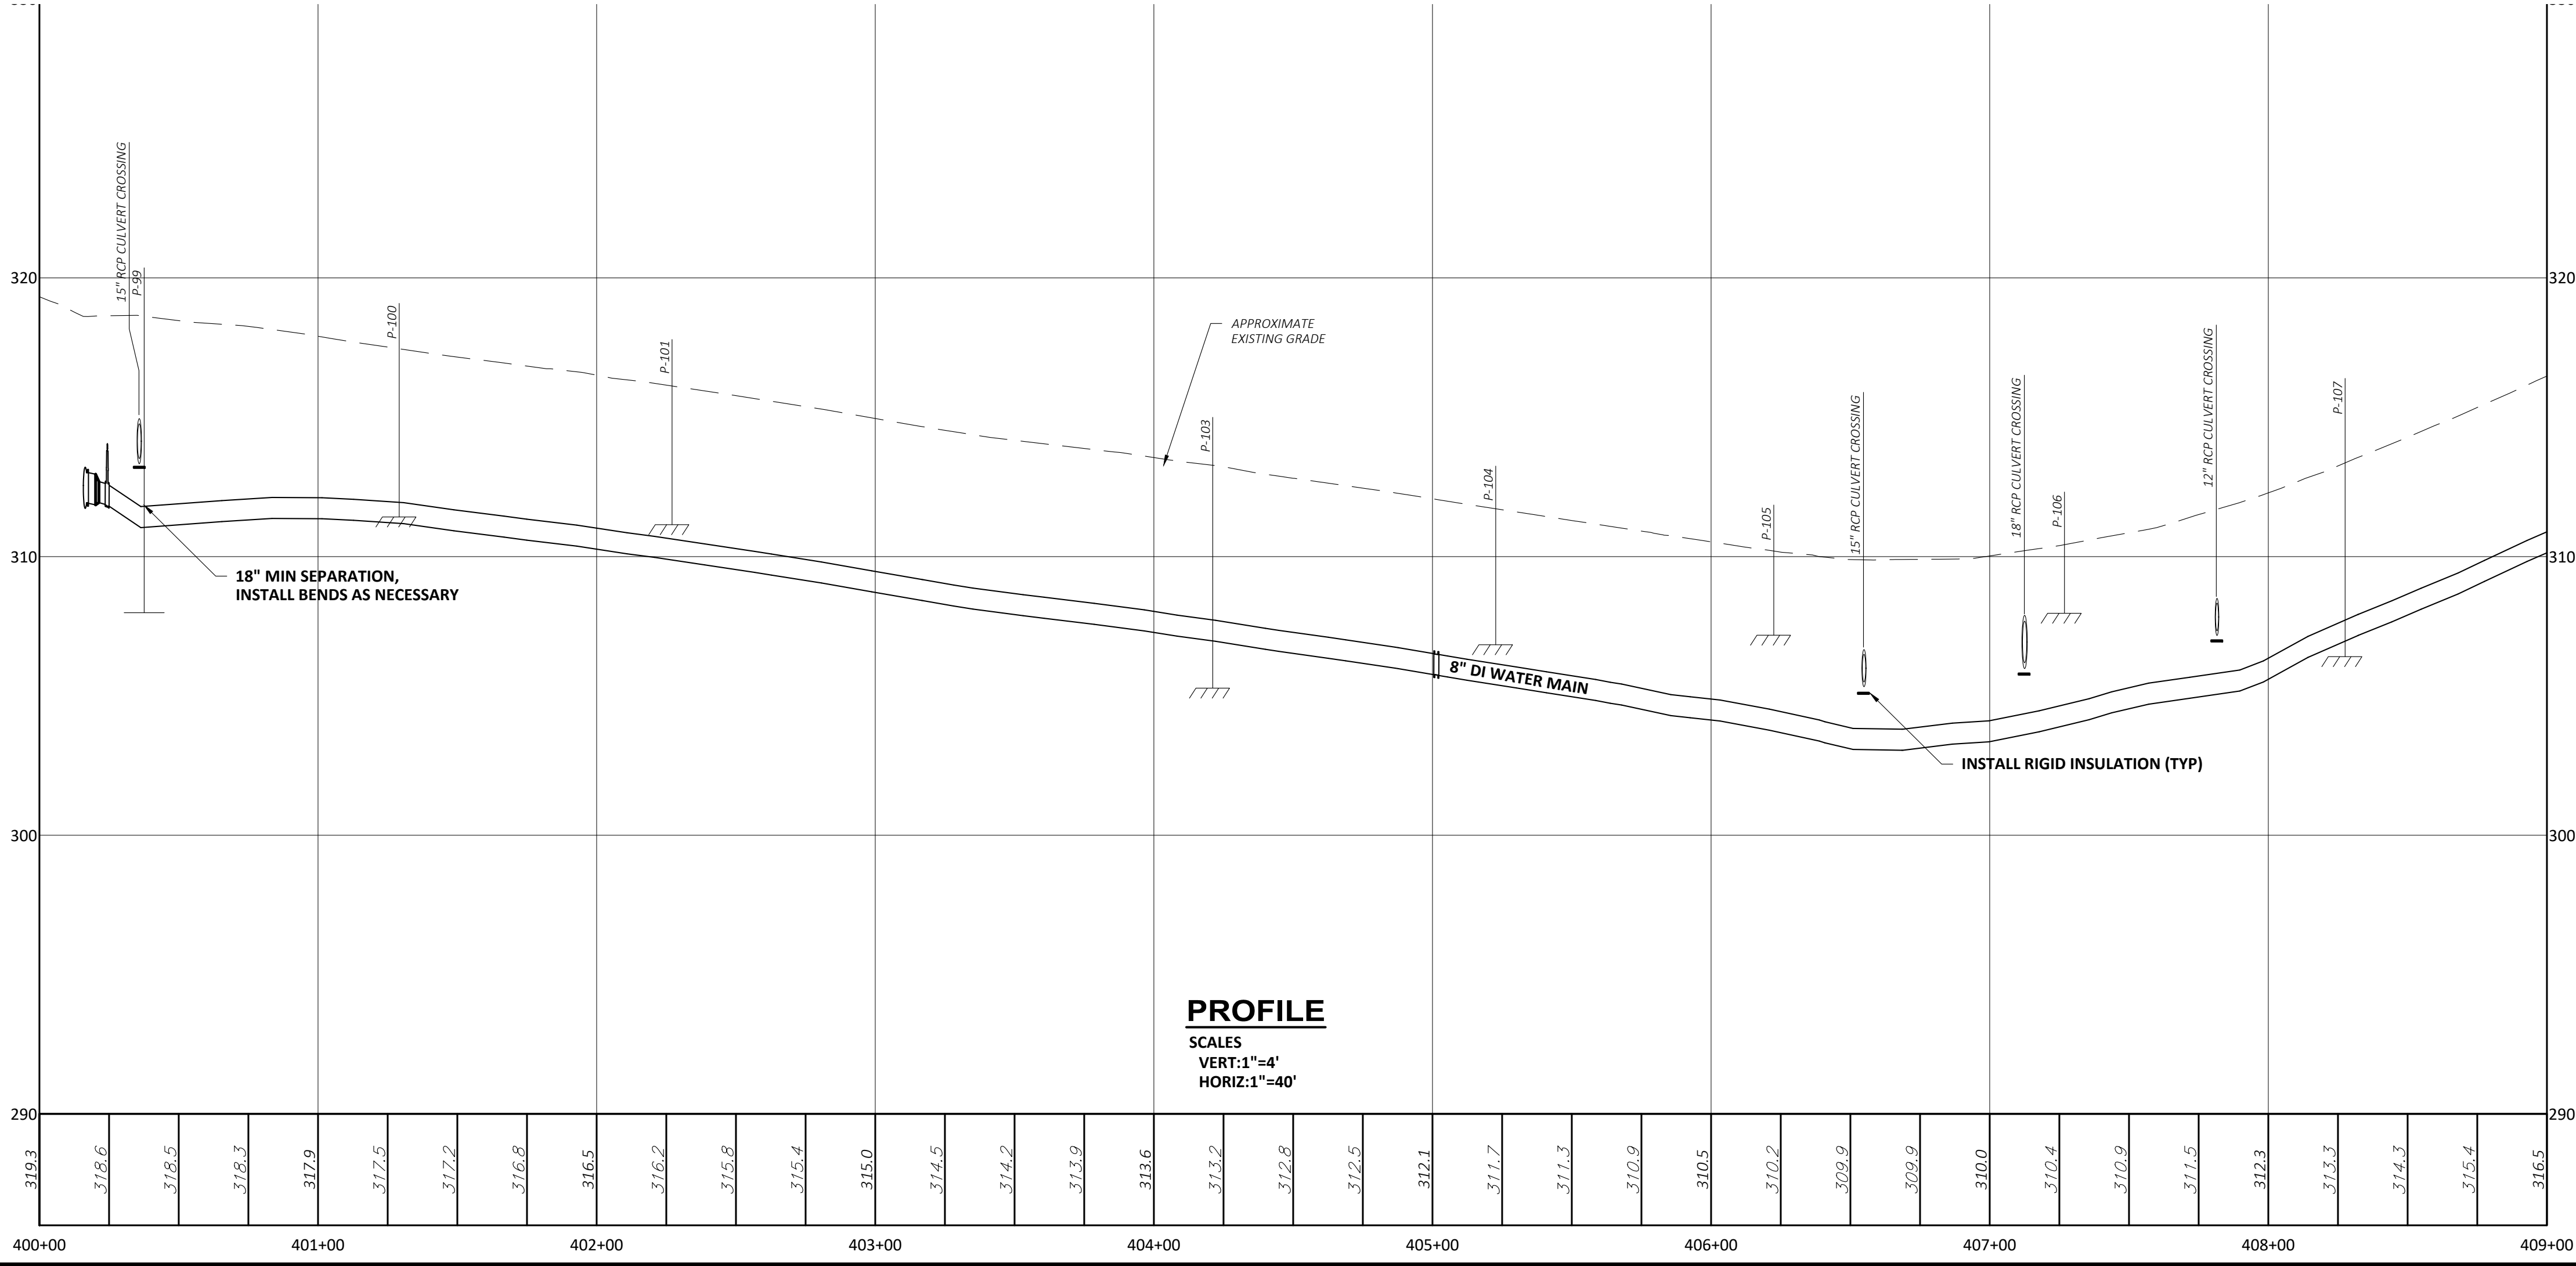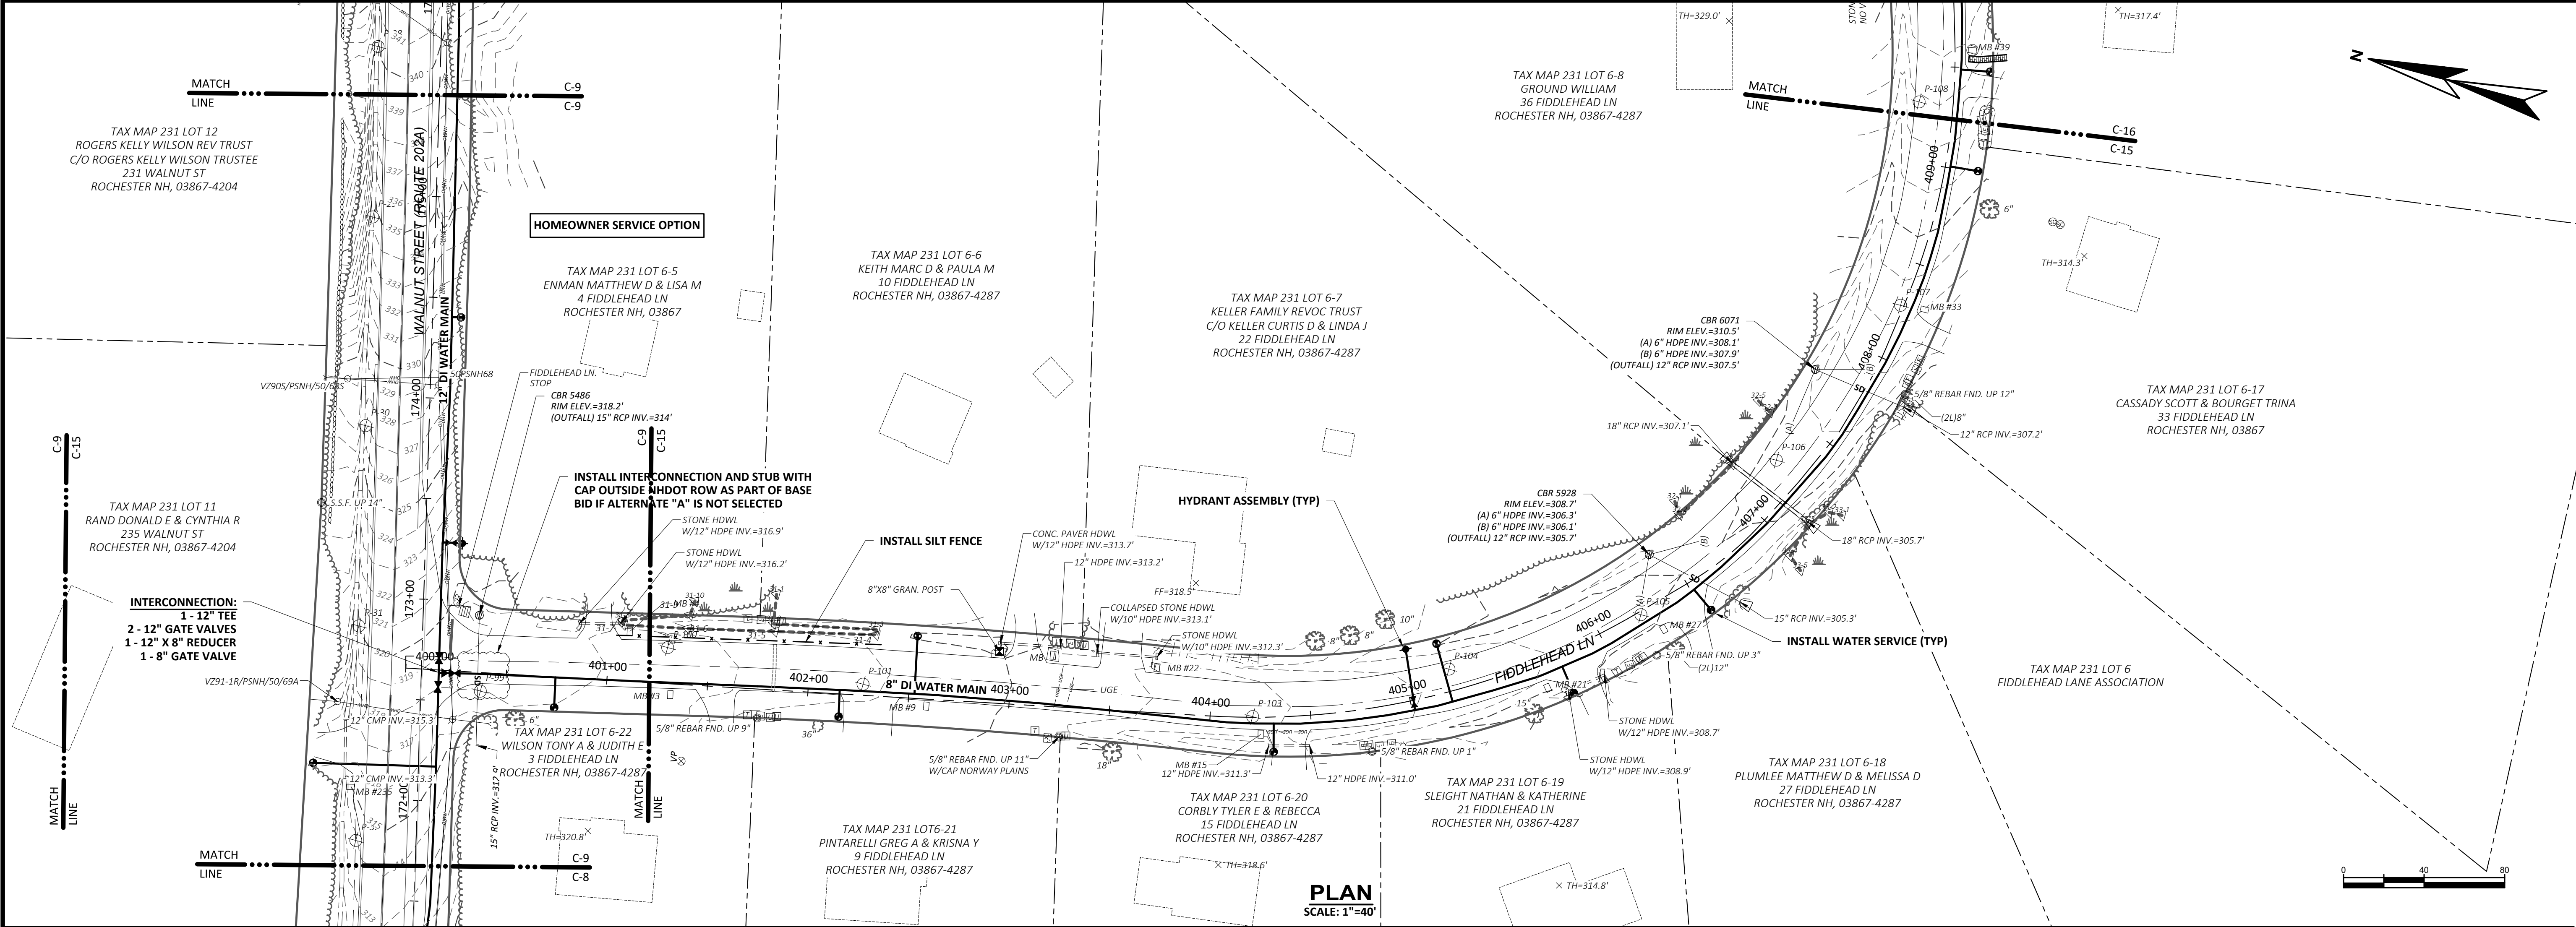



SUBMISSIONS/REVISIONS		CONTRACT DRAWINGS	
NO	DATE	NO	DATE
1	08-21	1	08-21
2	08-21	2	08-21
3	08-21	3	08-21
100	08-21	100	08-21

CITY OF ROCHESTER, NEW HAMPSHIRE
ROUTE 202A WATER MAIN EXTENSION & WATER STORAGE TANK
ROCHESTER, NEW HAMPSHIRE

PLAN AND PROFILE XIII
FIDDLEHEAD LANE - BID ALTERNATE A
STA. 400+00 TO STA. 409+00

WRIGHT-PIERCE
Engineering a Better Environment
888.621.8156 | www.wright-pierce.com

DRAWING
C-15

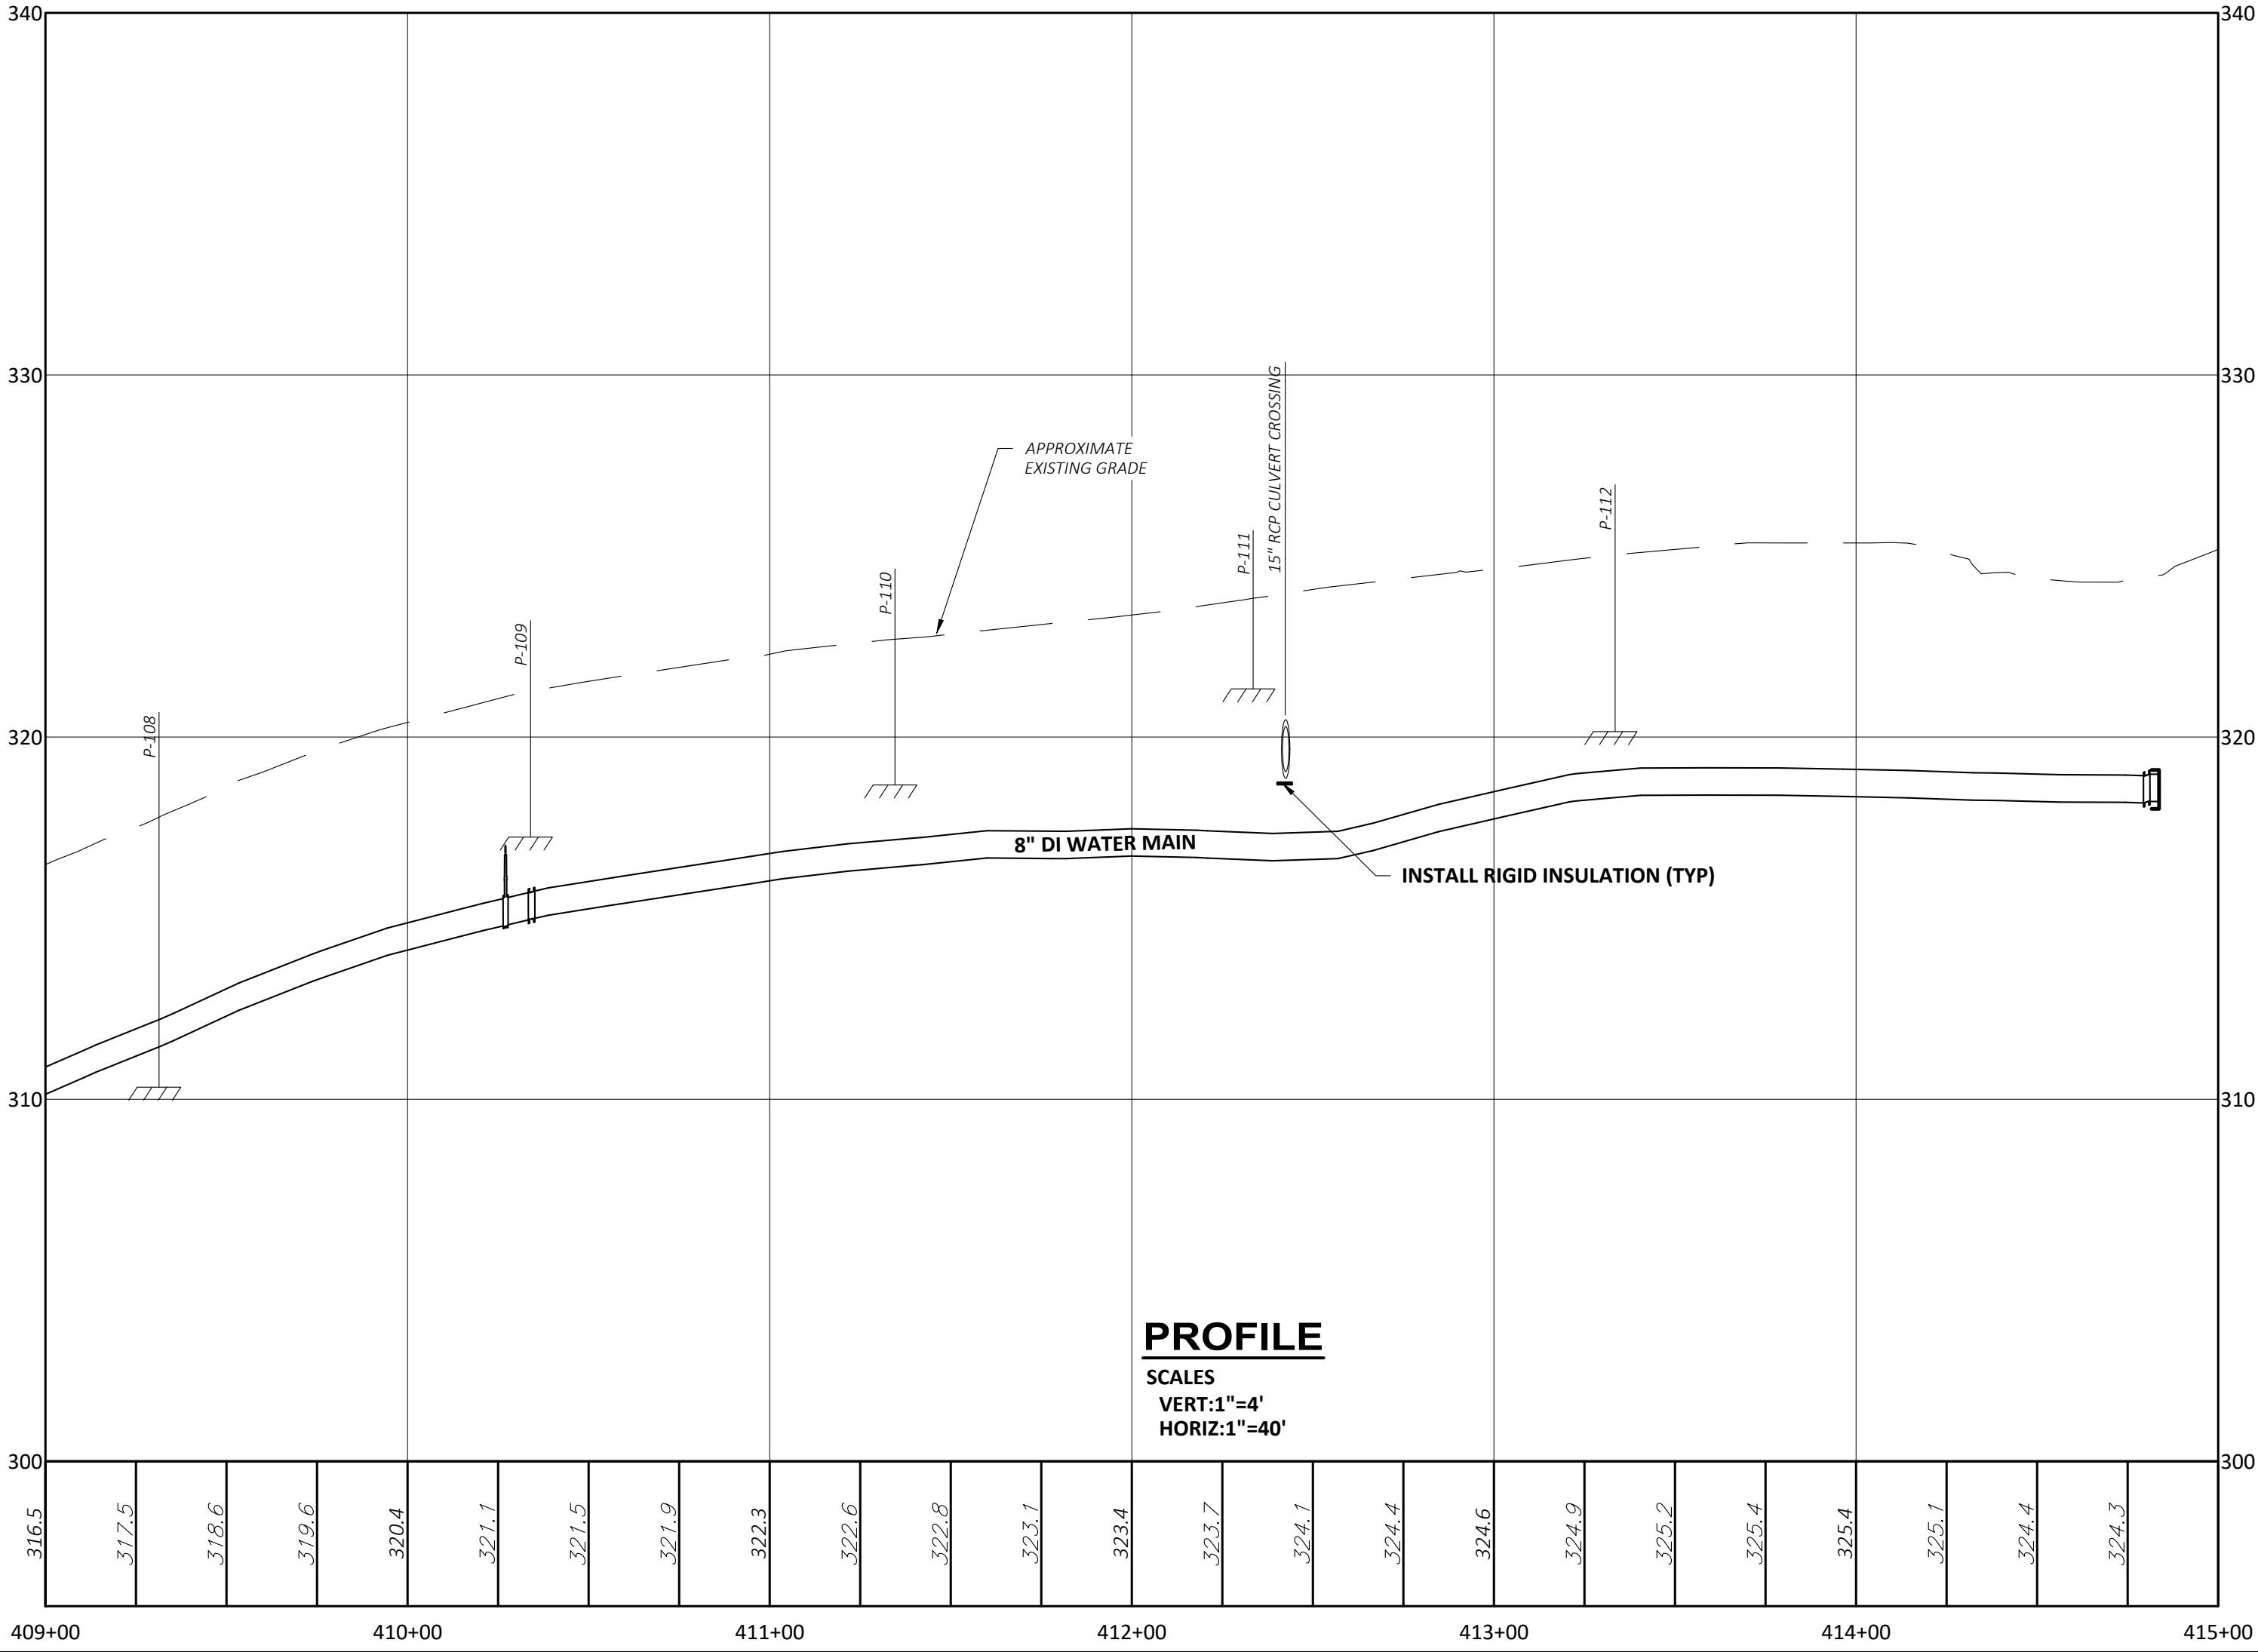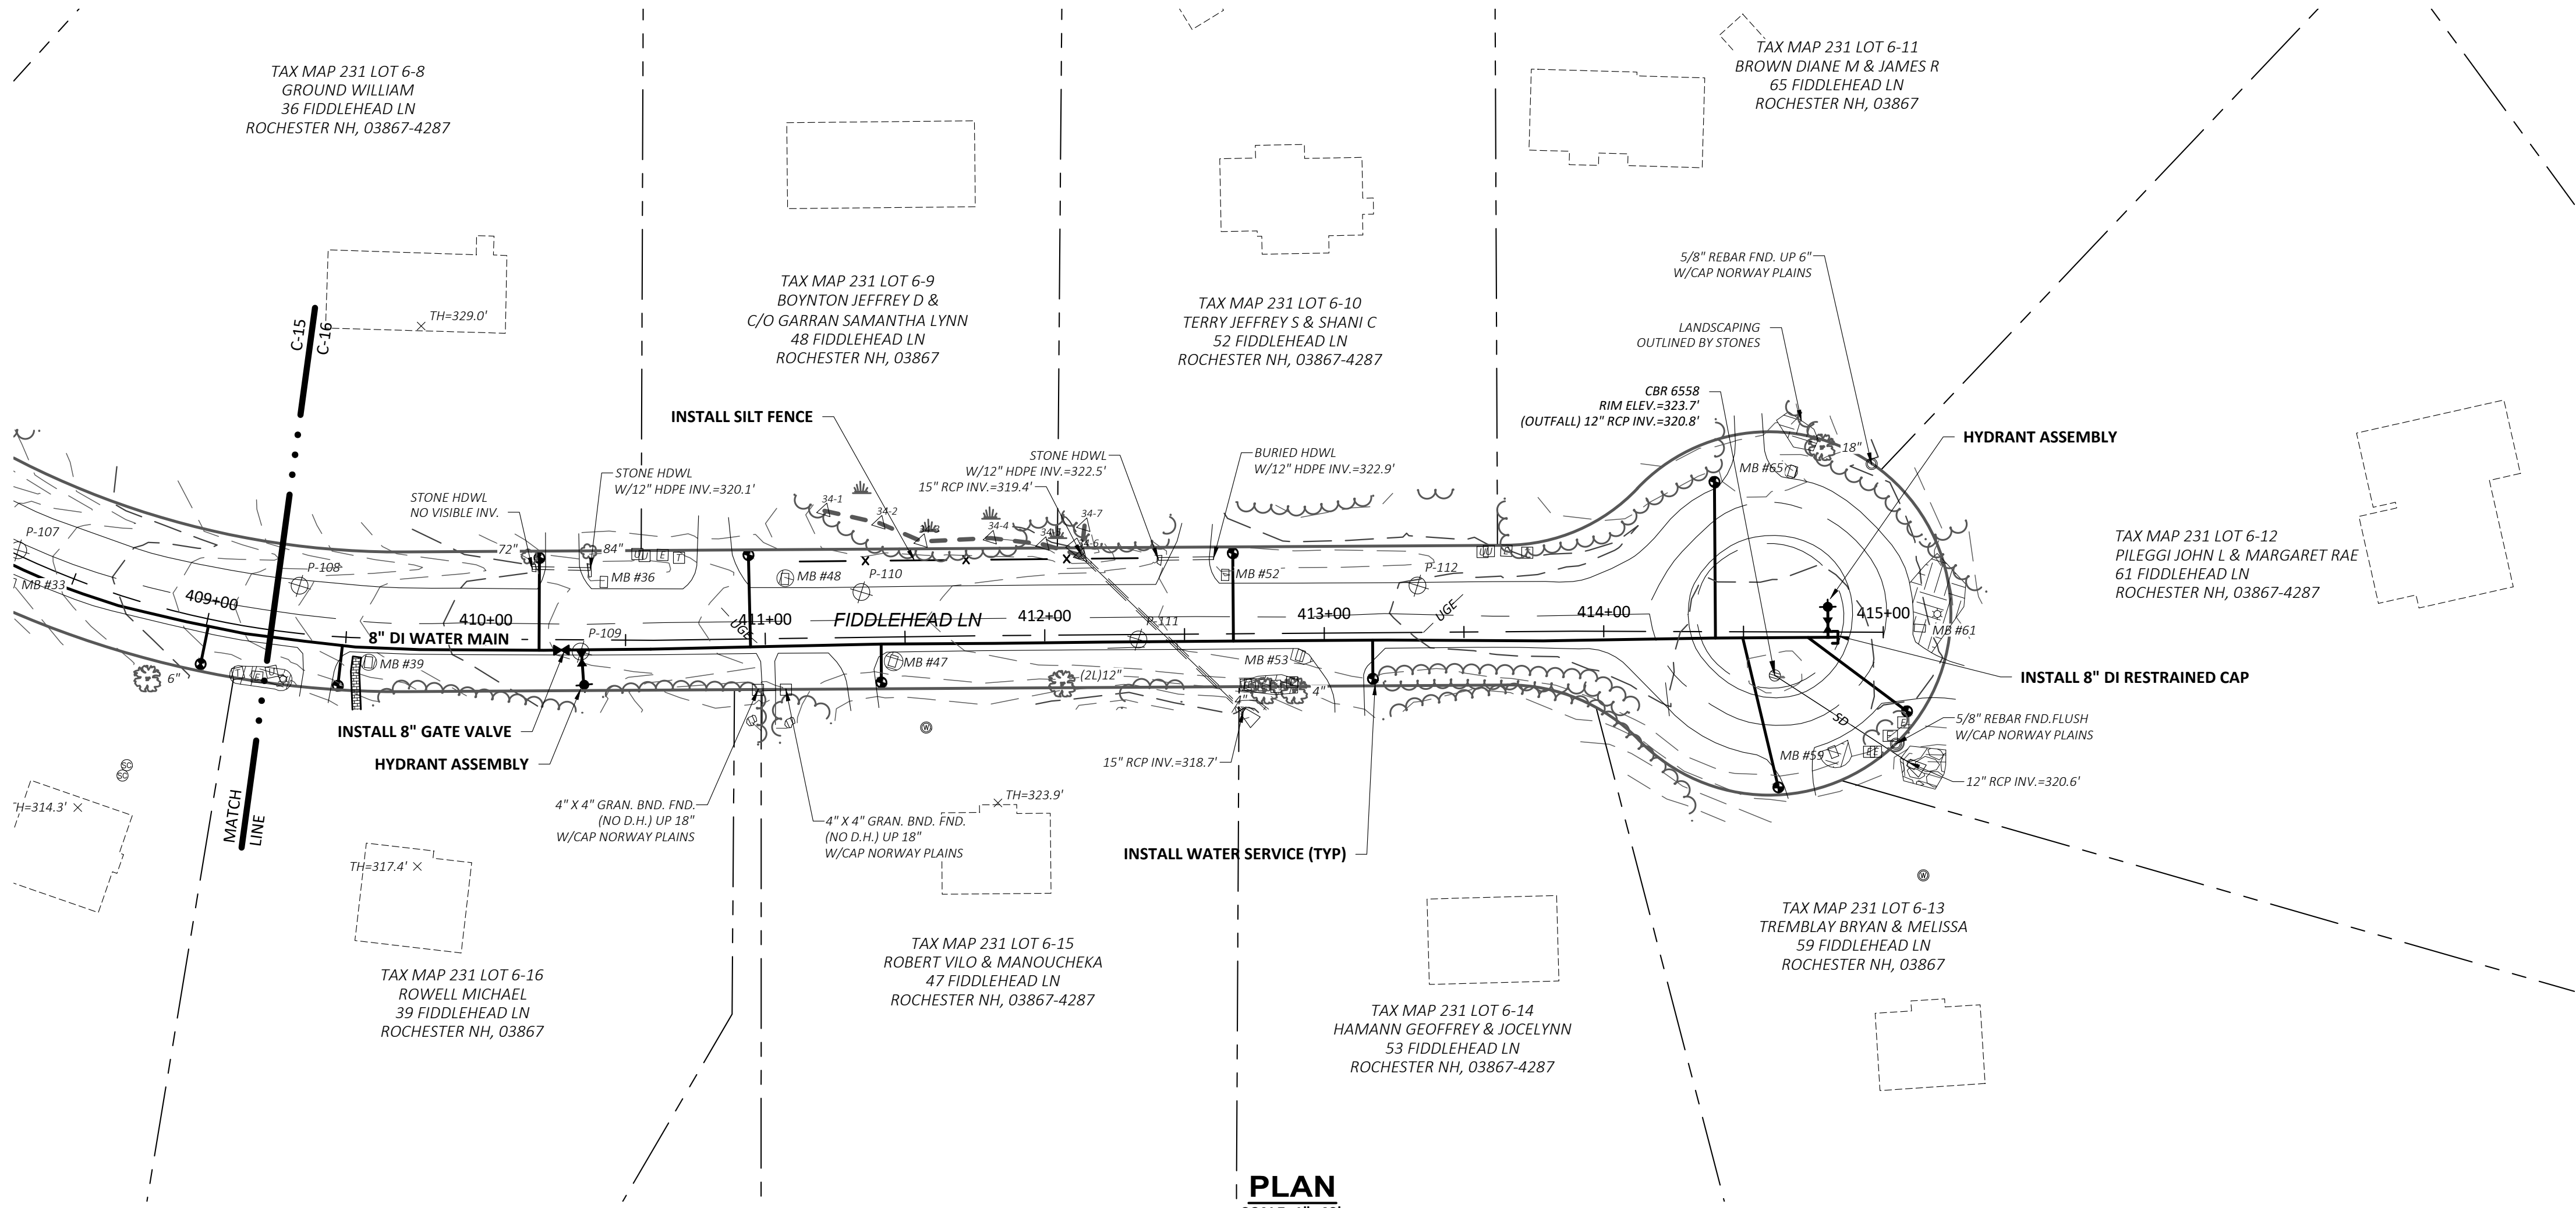

CITY OF ROCHESTER, NEW HAMPSHIRE

ROUTE 202A WATER MAIN EXTENSION & WATER STORAGE TANK

ROCHESTER, NEW HAMPSHIRE

PLAN AND PROFILE XIV

FIDDLEHEAD LANE - BID ALTERNATE A

STA. 409+00 TO STA. 415+00

DRAWING


C-16



WRIGHT-PIERCE

Engineering a Better Environment



888.621.8156 | www.wright-pierce.com

SUBMISSIONS/REVISIONS		NO	DATE
CONTRACT DRAWINGS <td></td> <td></td>			
DESIGNED BY: A.MAR	APP'D: D.T.H.		08-21
CAD CORP.: W.EDG			
CAD: W.EDG			
CHECKED BY: D.LAR			
DATE: 05-21			
APPROVED BY: D.T.H.			
DATE: 05-21			
PROJECT NO: 14206B			

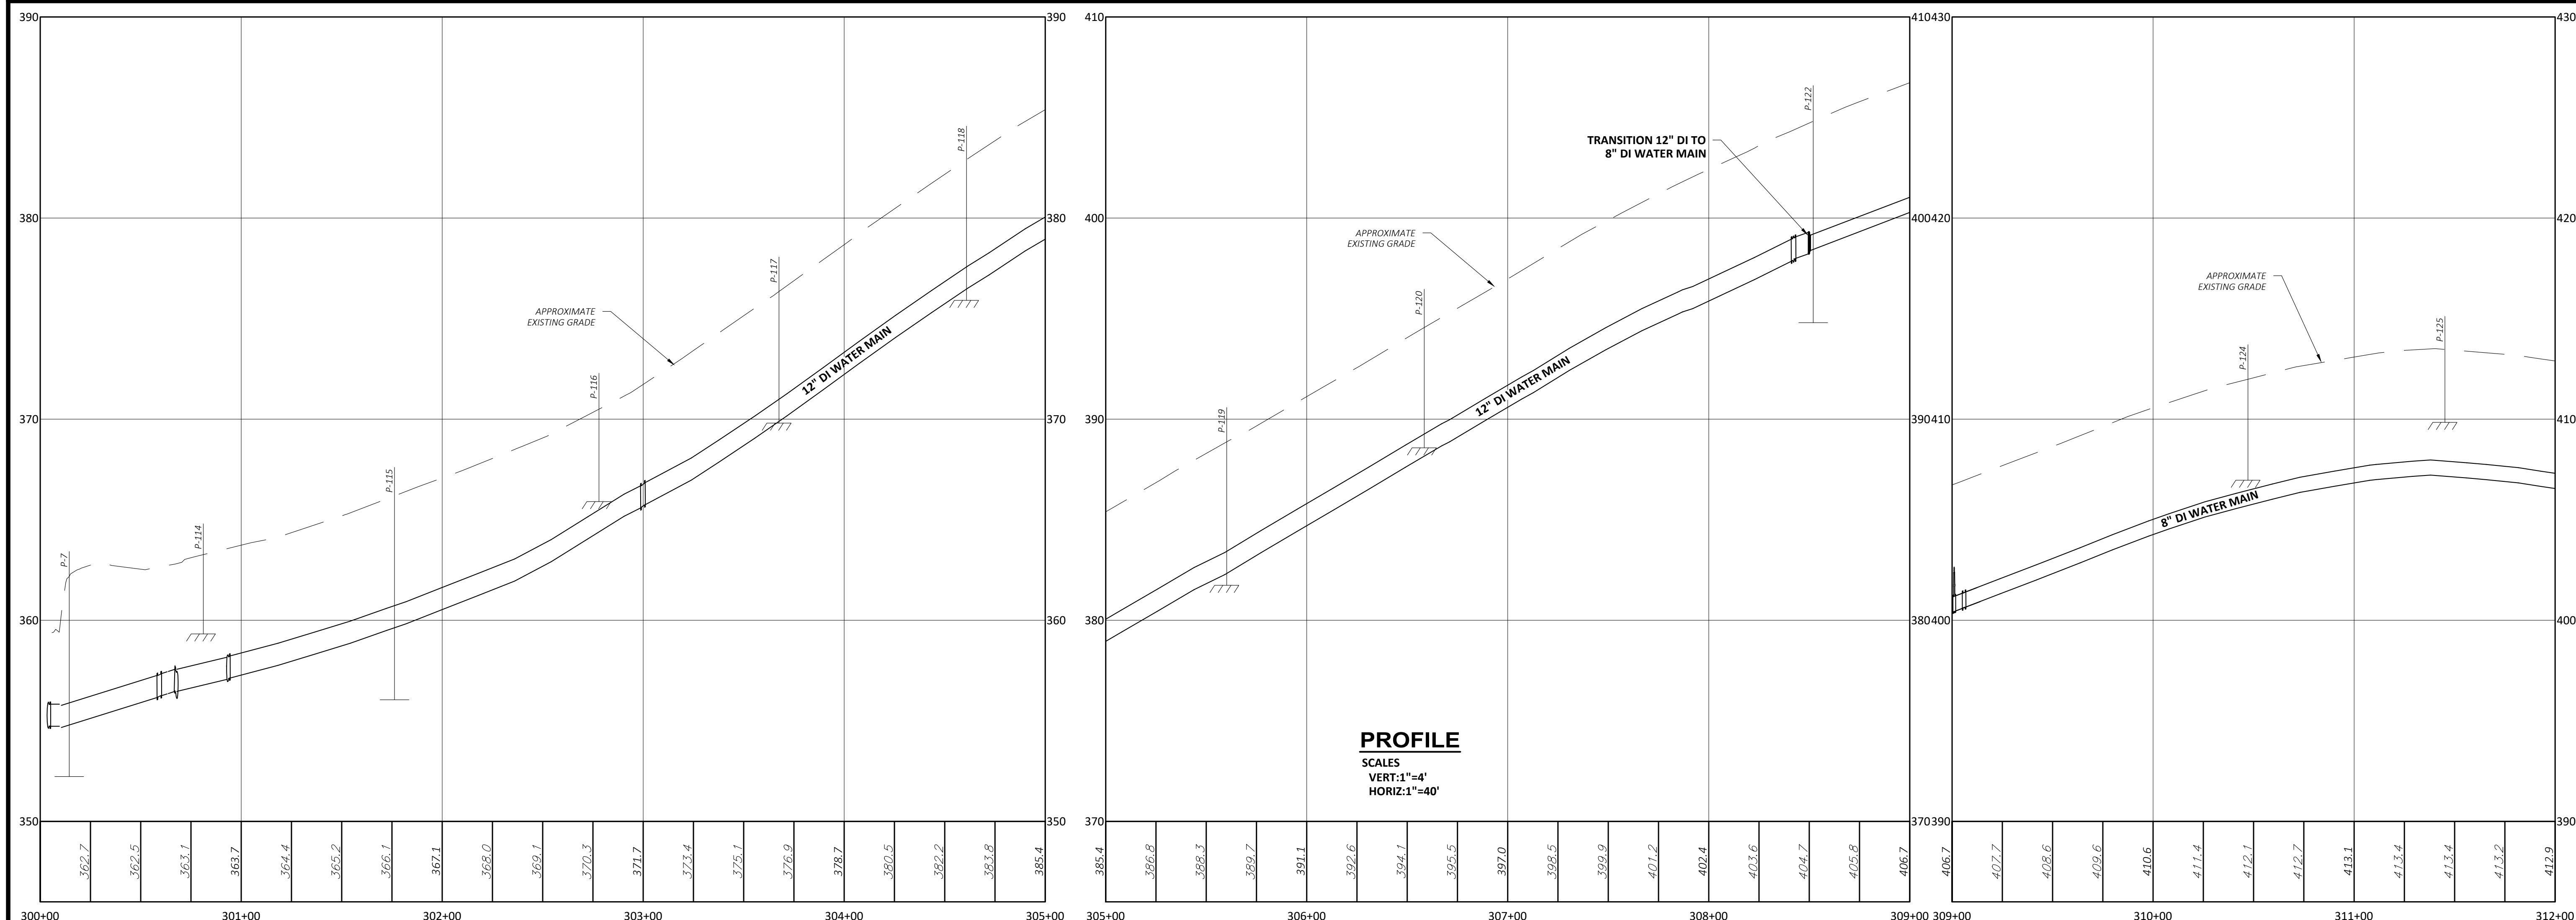

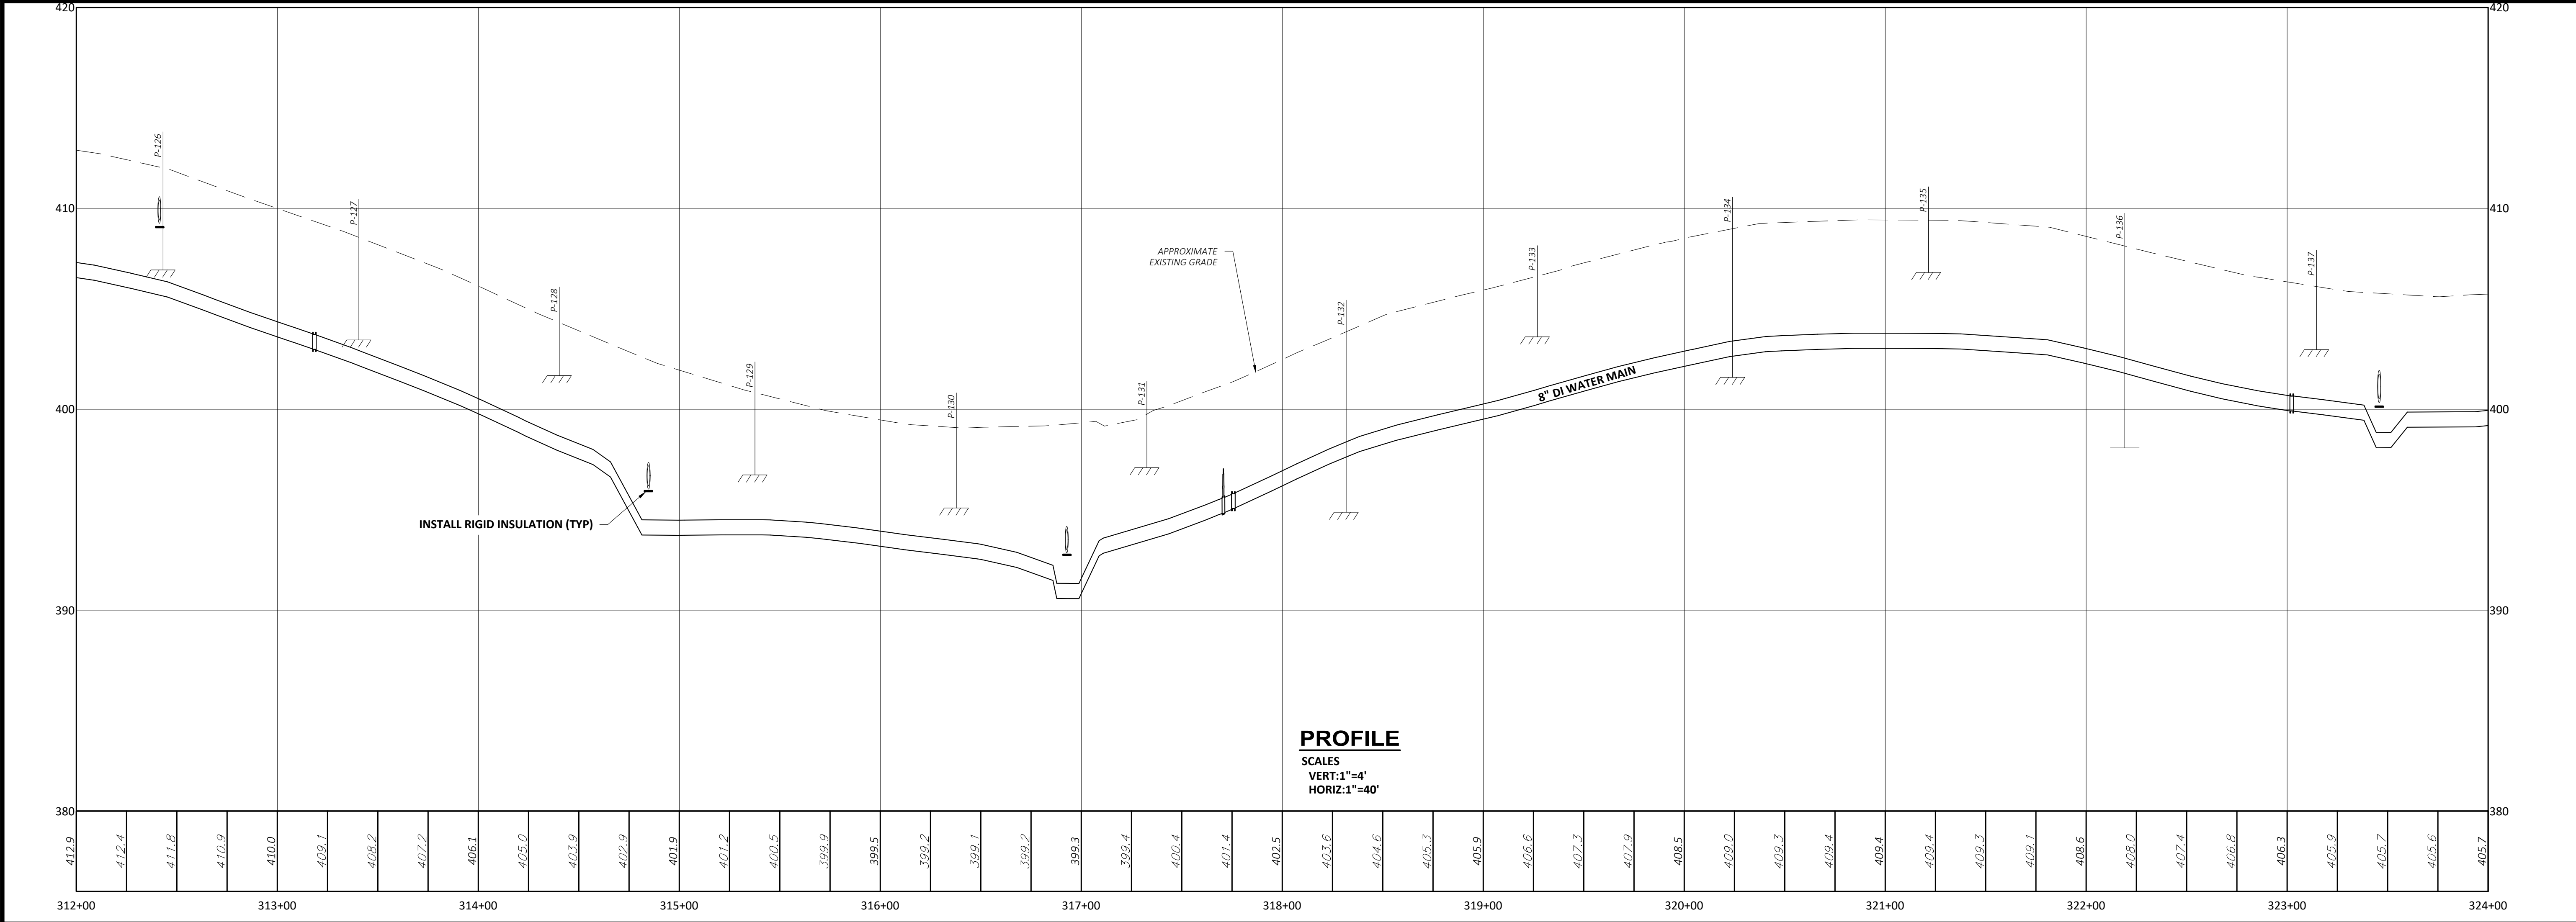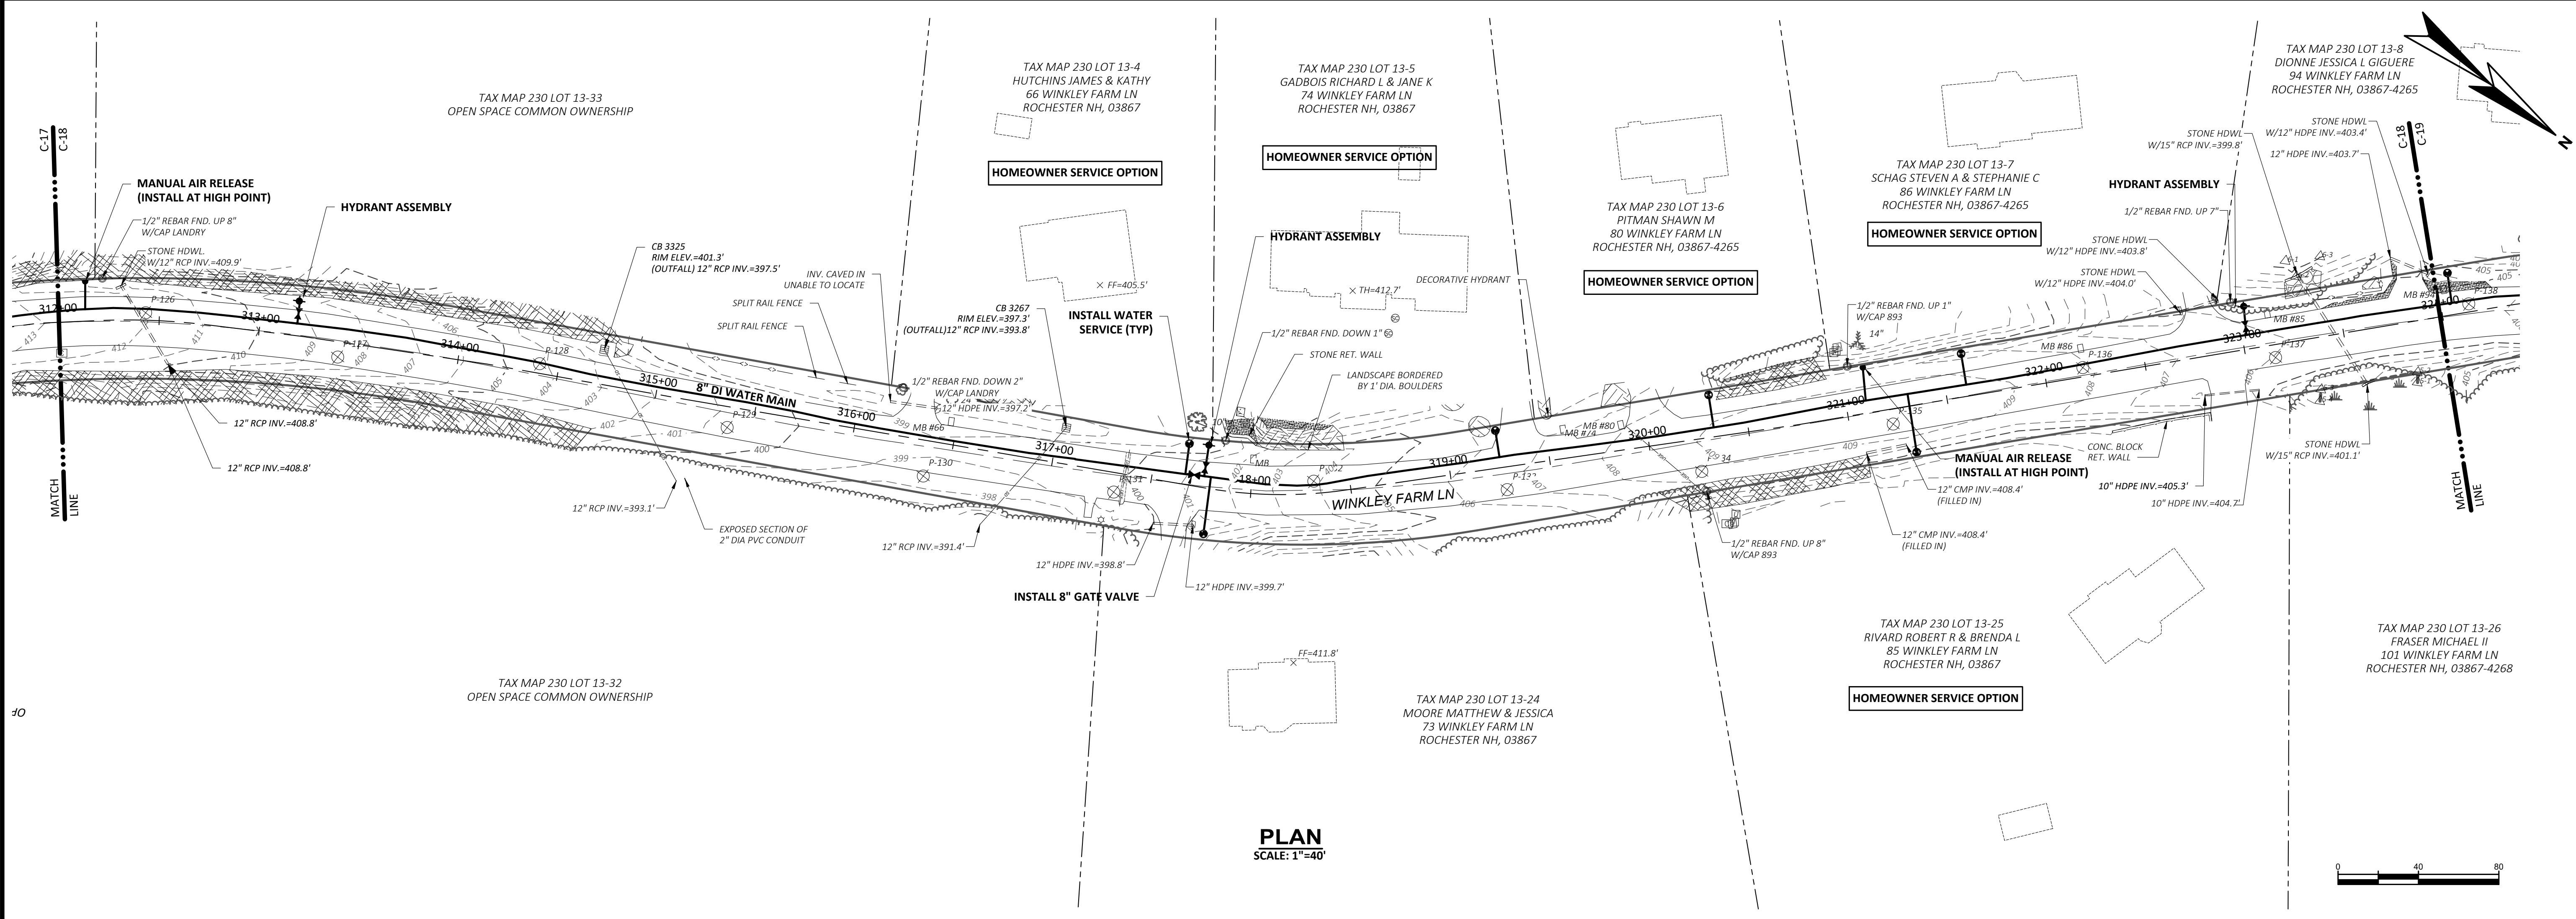

CITY OF ROCHESTER, NEW HAMPSHIRE ROUTE 202A WATER MAIN EXTENSION & WATER STORAGE TANK ROCHESTER, NEW HAMPSHIRE	DRAWING C-18	PLAN AND PROFILE XVI WINKLEY FARM LN STA 312+00 TO STA 324+00	888.621.8156 www.wright-pierce.com		WRIGHT-PIERCE Engineering a Better Environment			
CONFORMED REFERENCE DRAWINGS NOVEMBER 2021: THE CONFORMED REFERENCE DOCUMENTS HAVE BEEN REVIEWED TO INCORPORATE CLARIFICATIONS AND/OR DRAWING AND SPECIFICATION CHANGES FROM THE PROJECT AGENCIES IN ORDER TO CLEARLY AND ACCURATELY REPRODUCE THESE CLARIFICATIONS/CHANGES FOR CONVENIENCE AND REFERENCE. THE EXECUTED CONTRACT DOCUMENTS, INCLUDING THE BASIS FOR ALL ACCEPTED WORK UNDER THIS CONTRACT.		DESIGNED BY: A.MAR CAD COORD: W.EDG CAD: W.EDG CHECKED BY: D.LAR DATE: 05-21 APPROVED BY: D.THI DATE: 05-21 PROJECT NO: 14206B		NO. CONTRACT DRAWINGS		SUBMISSIONS/REVISIONS		APPD DATE D.THI 08-21

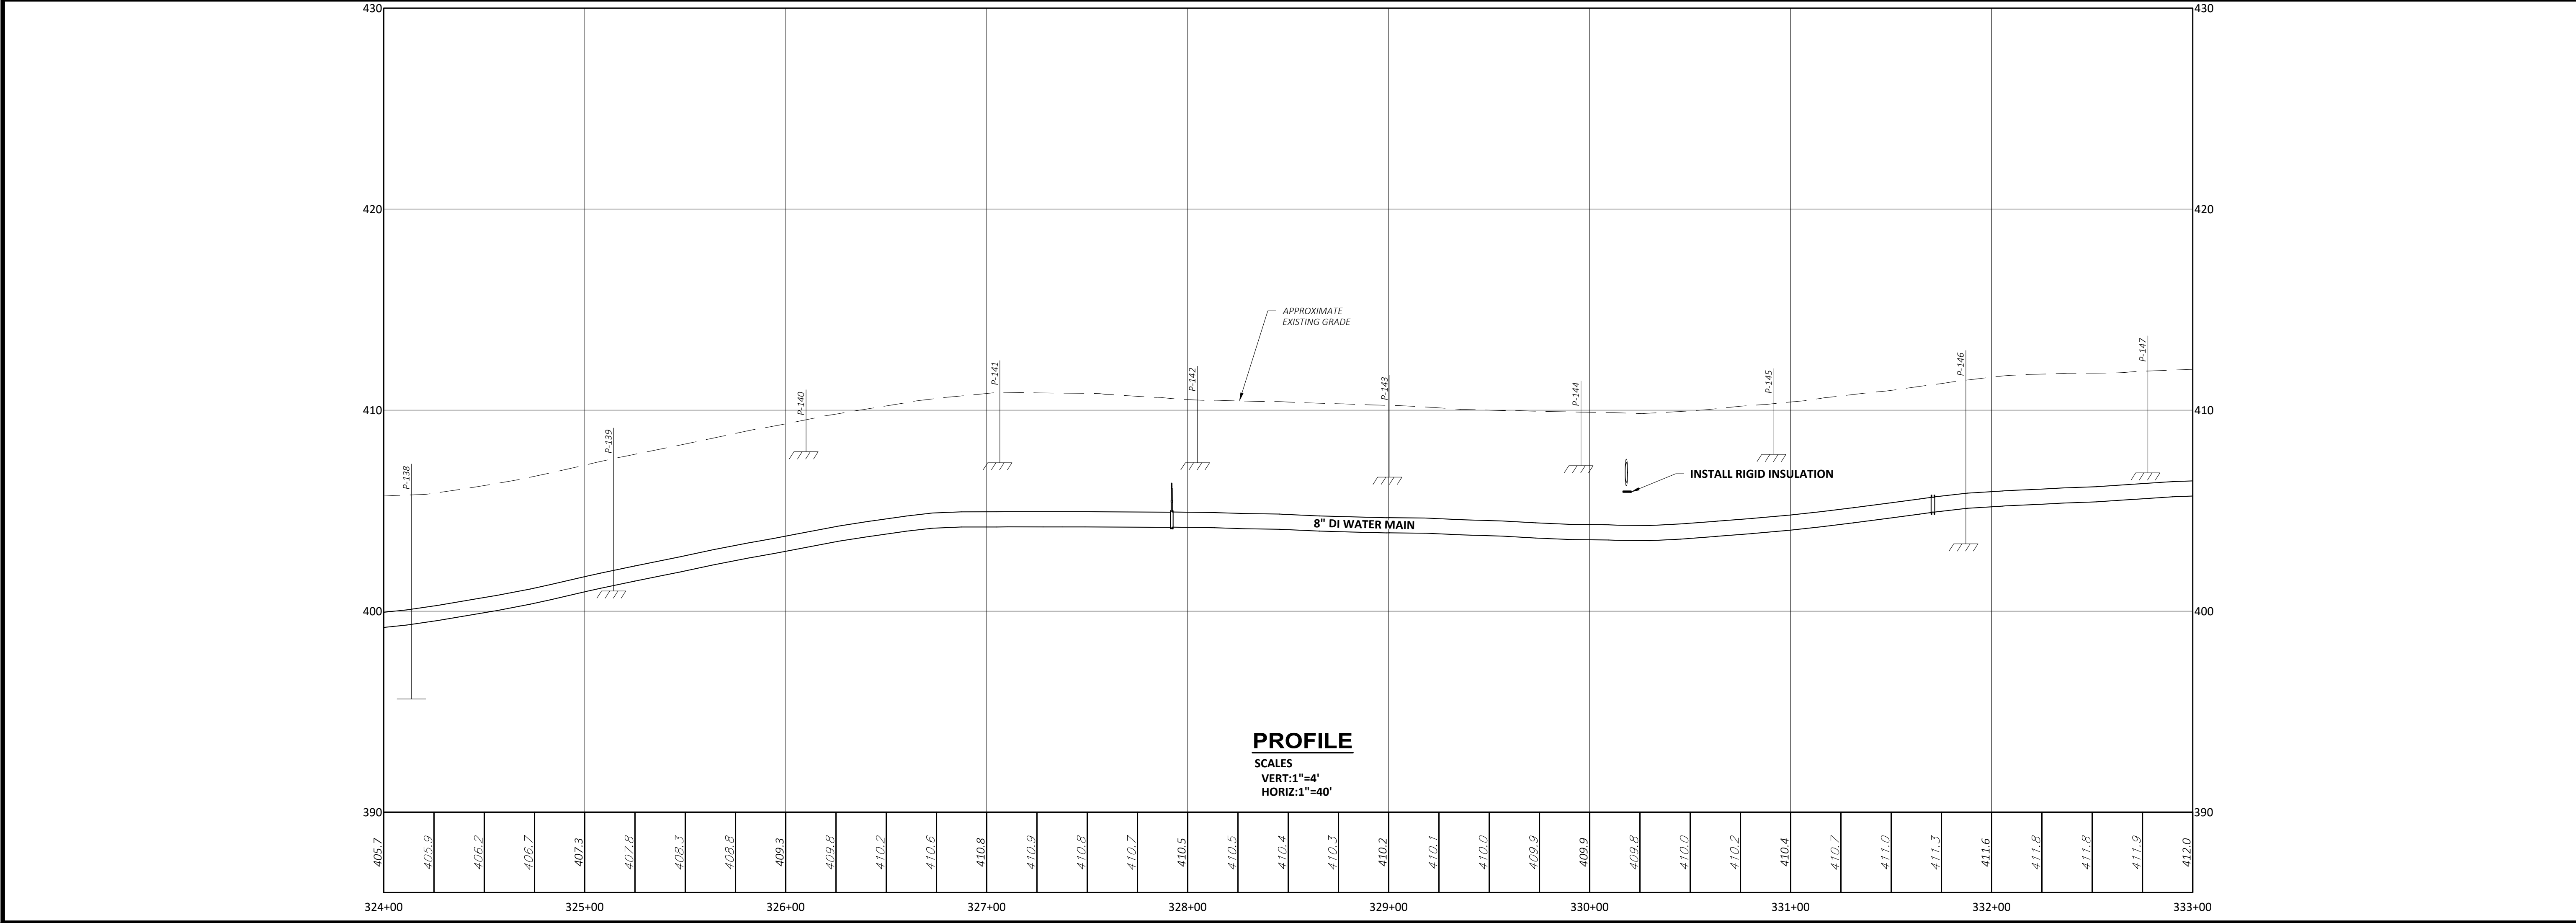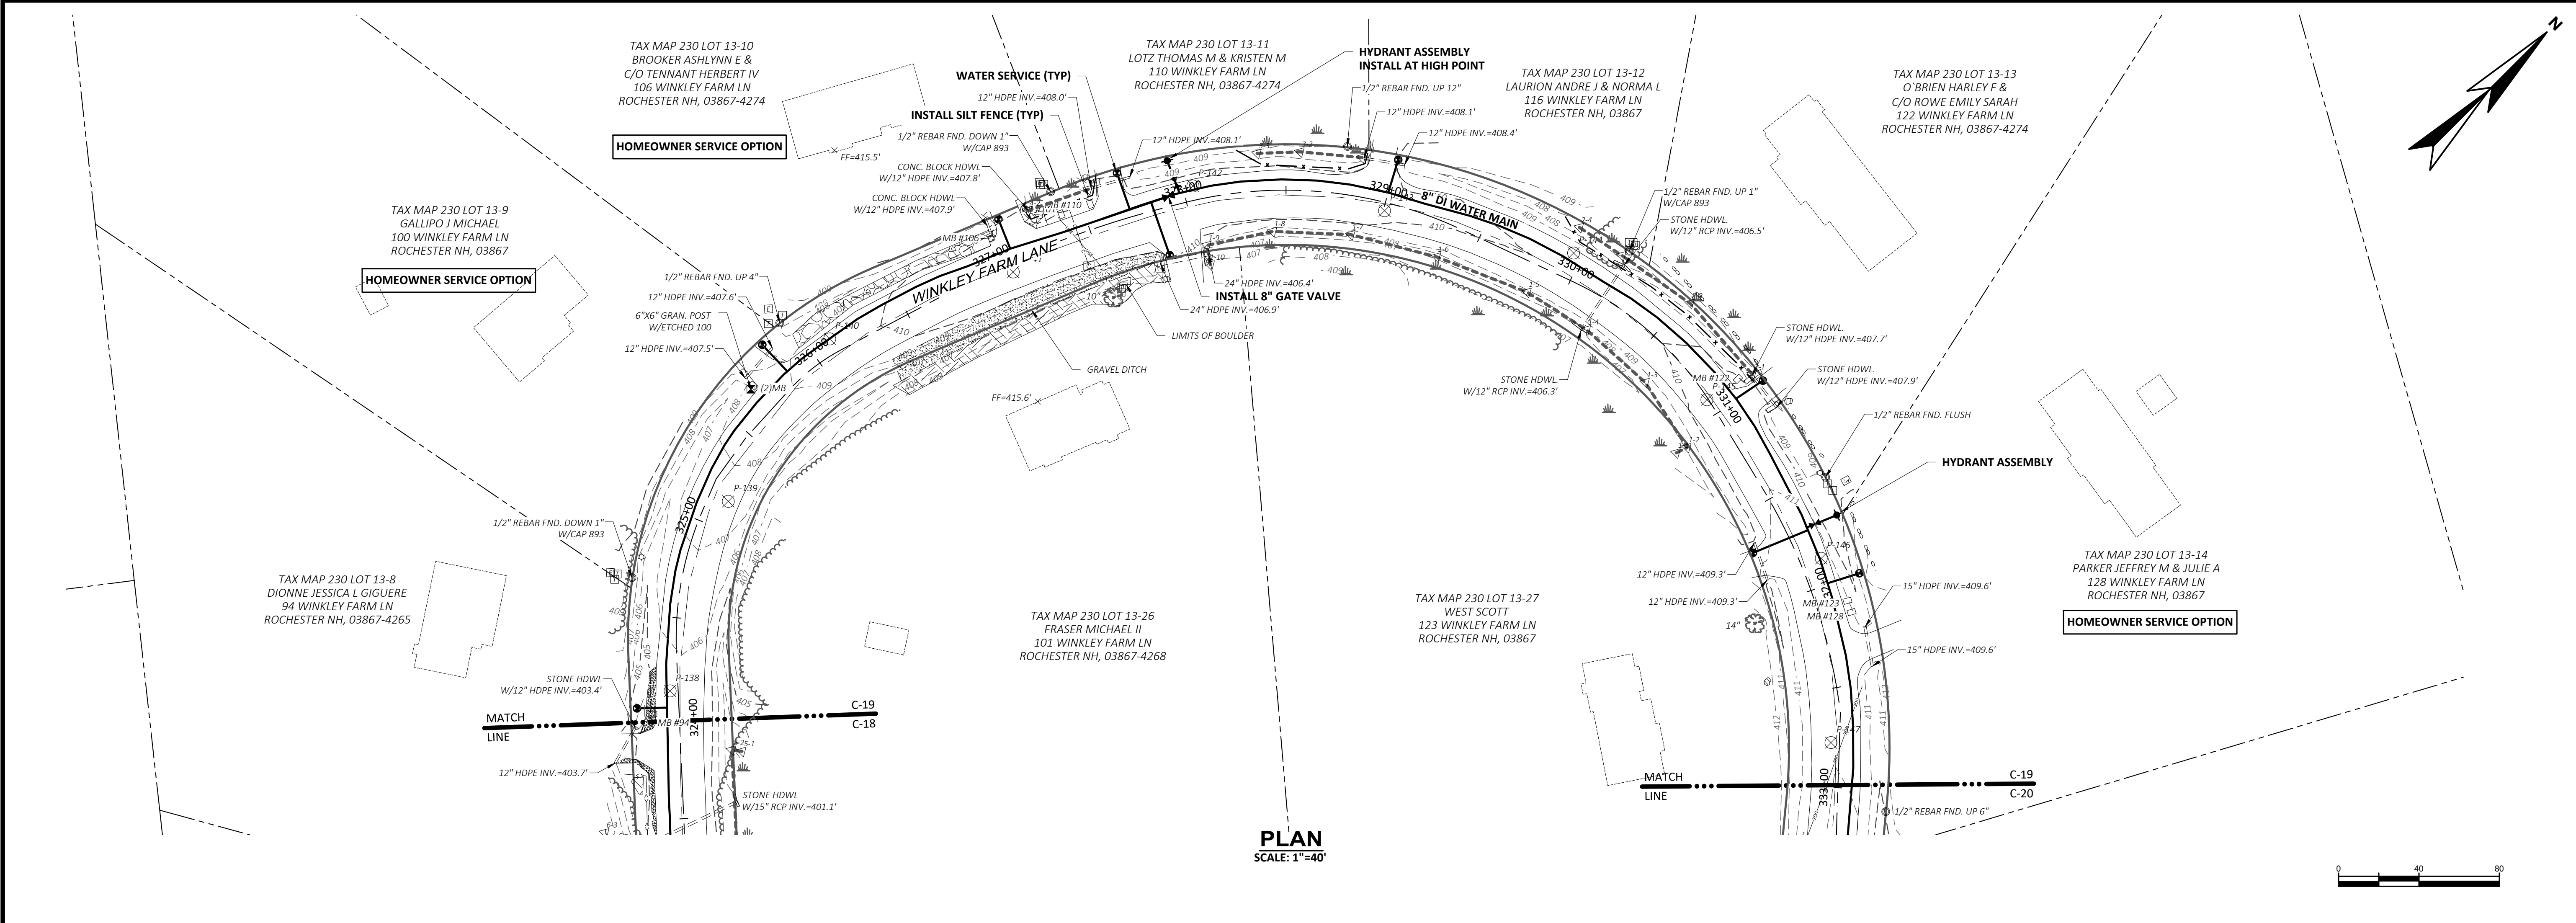

SUBMISSIONS/REVISIONS	
NO	DATE
1	08-21
2	08-21
3	08-21
4	08-21
5	08-21
6	08-21
7	08-21
8	08-21
9	08-21
10	08-21




CONTRACT DRAWINGS	
NO	DATE
1	08-21
2	08-21
3	08-21
4	08-21
5	08-21
6	08-21
7	08-21
8	08-21
9	08-21
10	08-21

DESIGNED BY: A. MAR	
CAD CORP.	W. EDG
CAD	W. EDG
CHECKED BY: D. LAR	DATE: 05-21
APPROVED BY: D. THI	DATE: 05-21
PROJECT NO.	14206B

CITY OF ROCHESTER, NEW HAMPSHIRE	
ROUTE 202A WATER MAIN EXTENSION & WATER STORAGE TANK	
ROCHESTER, NEW HAMPSHIRE	
PLAN AND PROFILE XVII	
WINKLEY FARM LANE	
STA. 324+00 TO STA. 333+00	

DRAWING	
C-19	

WRIGHT-PIERCE	
Engineering a Better Environment	
888.621.8156 www.wright-pierce.com	

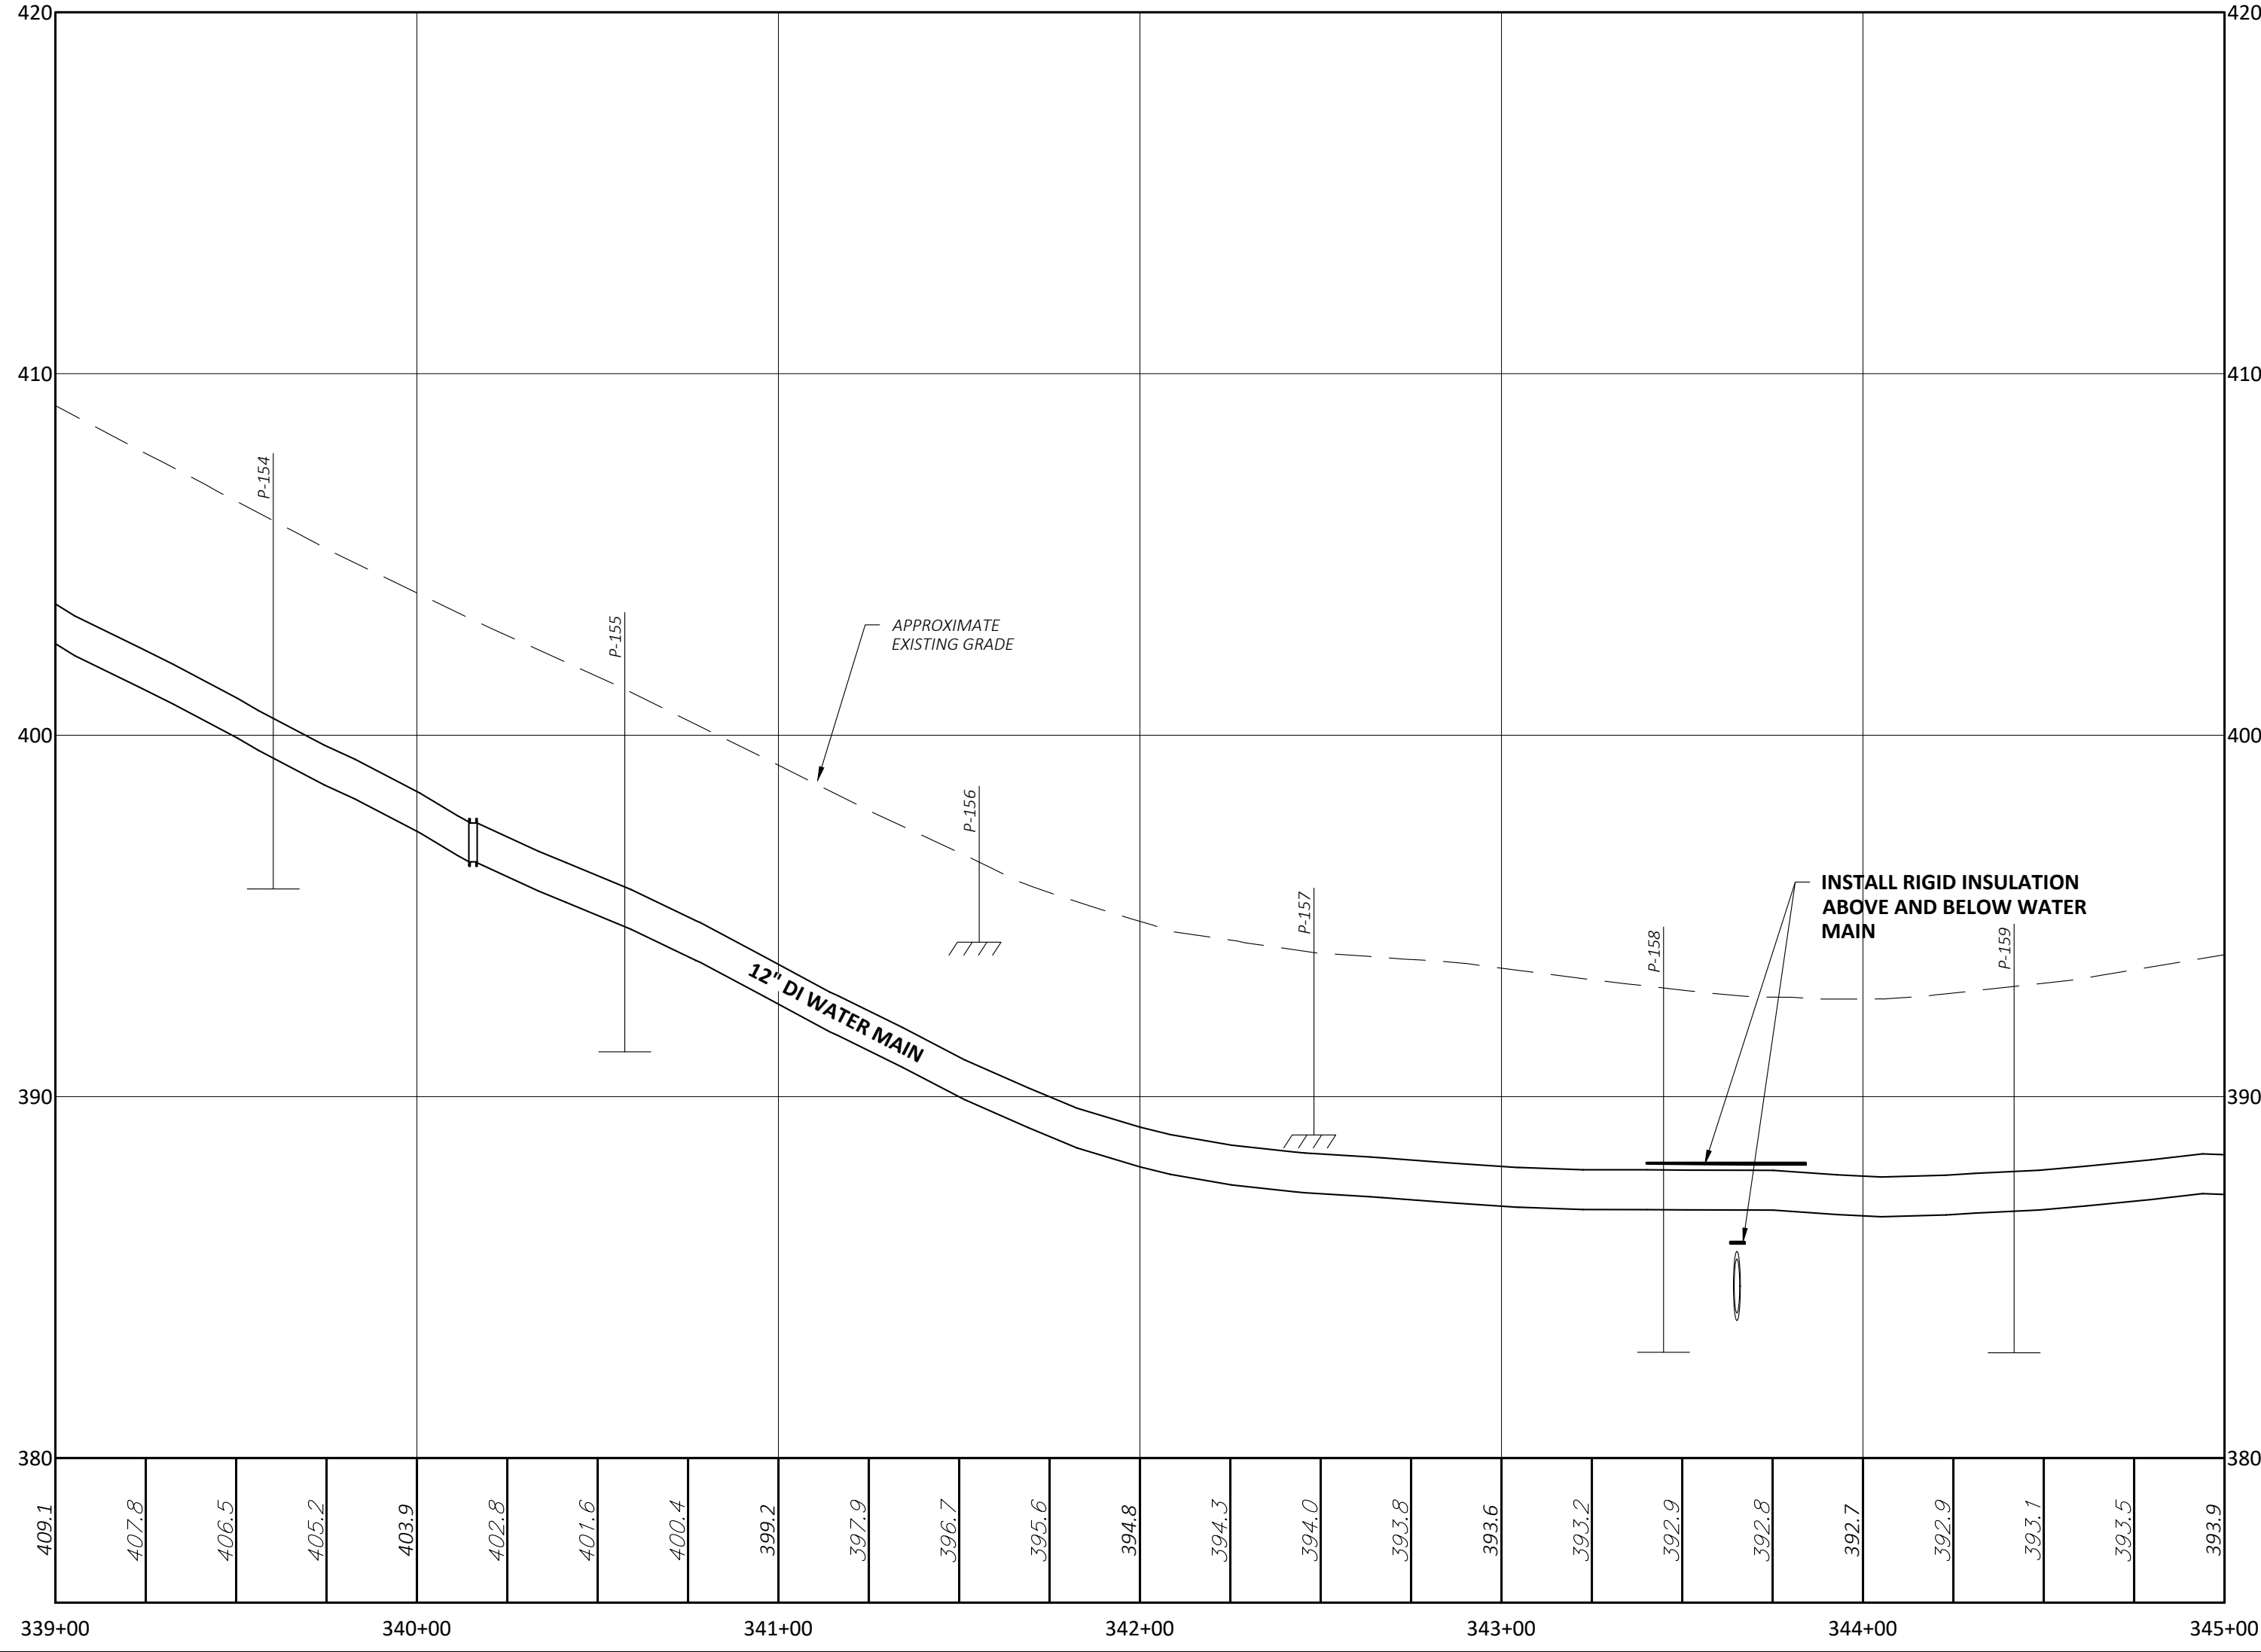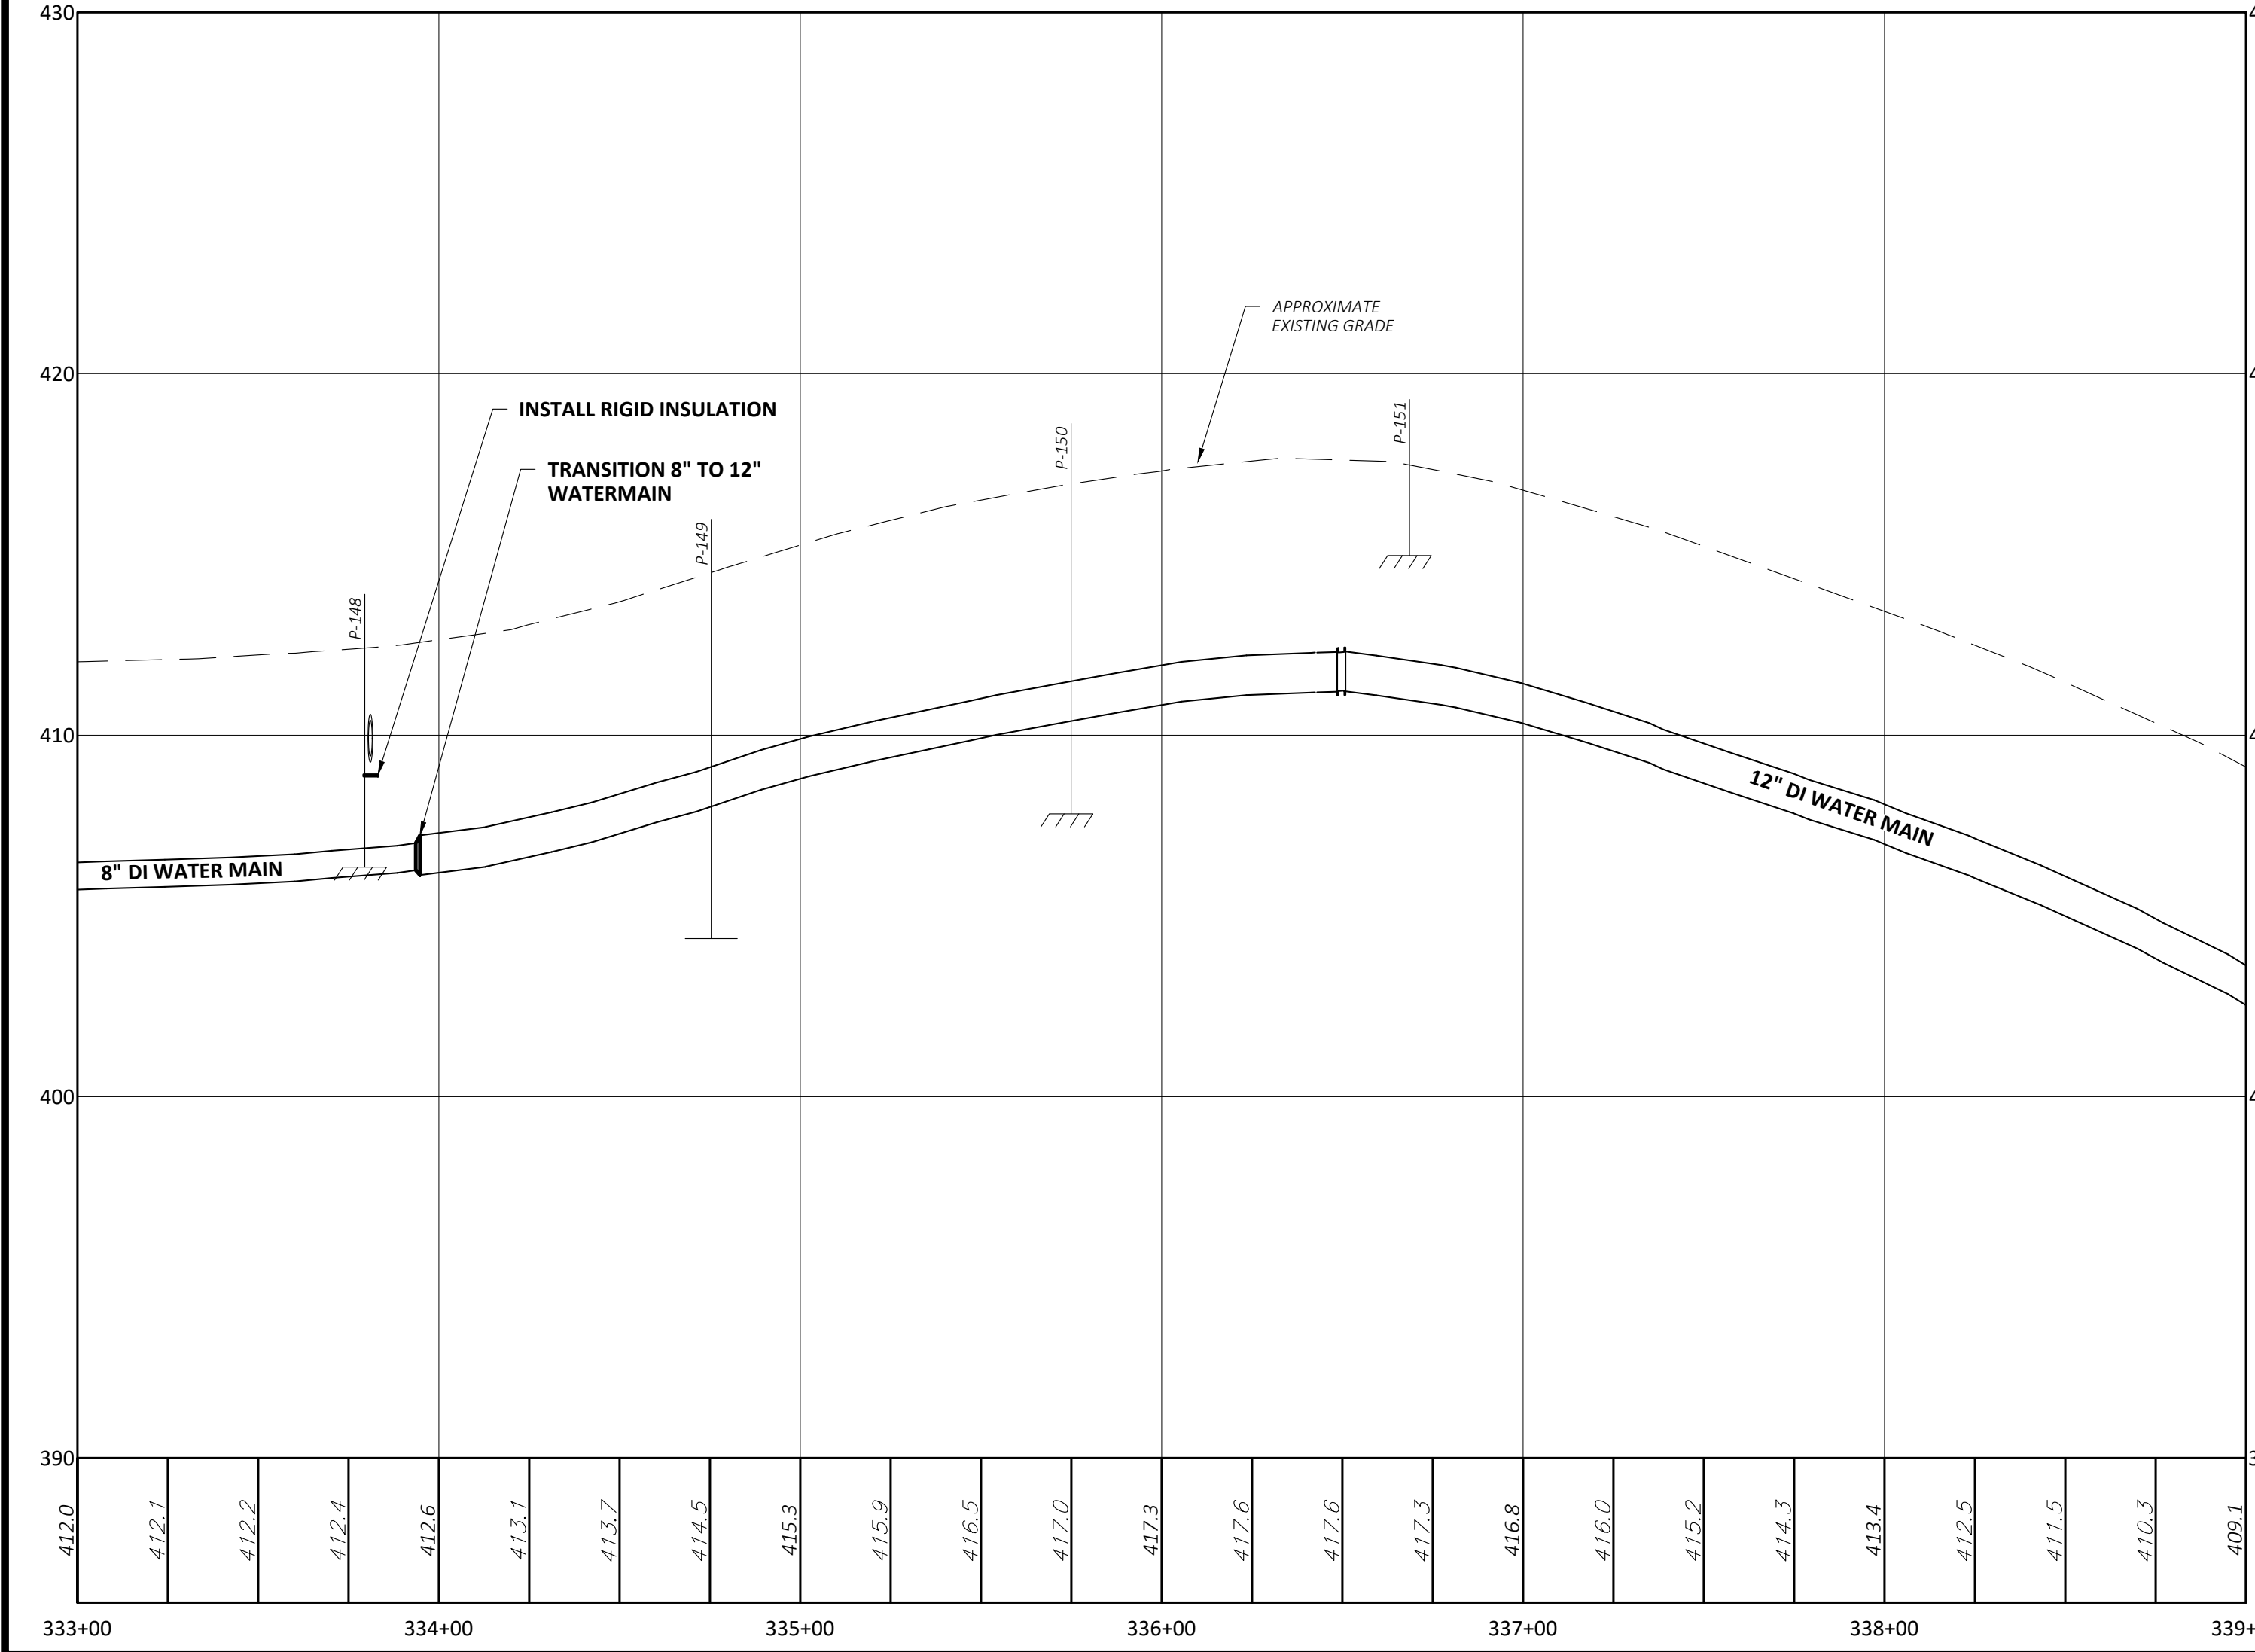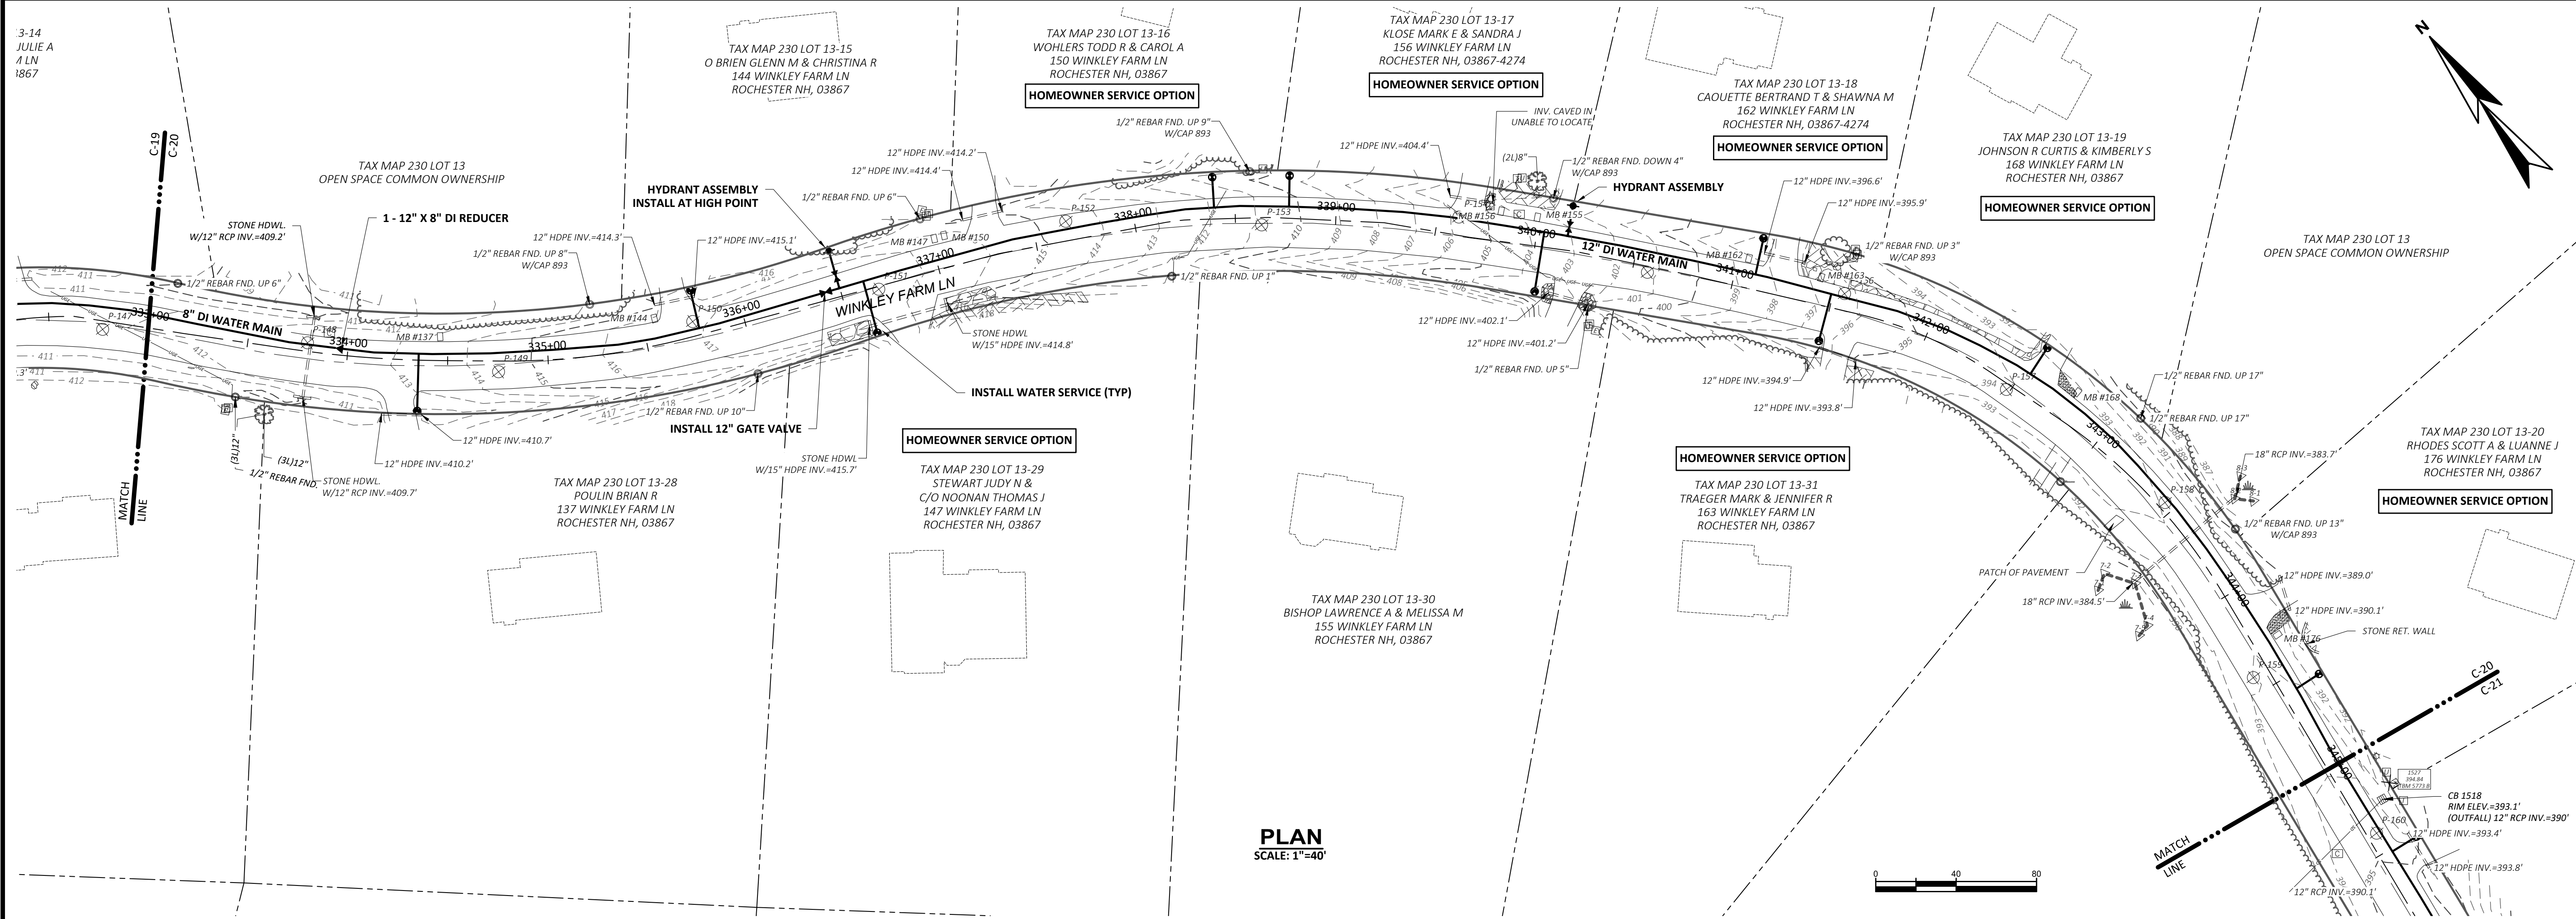

CONFORMED REFERENCE CHANGES NOVEMBER 2021. THE CONFORMED REFERENCE CHANGES HAVE BEEN REVIEWED TO INCORPORATE CLARIFICATIONS AND/OR DRAWING AND SPECIFICATION CHANGES FROM THE PROJECT DESIGNER IN ORDER TO CLARIFY AND ACCURATELY REFLECT THE PROJECT DESIGNER'S INTENT. THE EXISTING CONTRACT DOCUMENTS, INCLUDING THE BASIS OF DESIGN, SHALL BE THE BASIS FOR ALL ACCEPTED WORK UNDER THE CONTRACT.

NO SUBMISSIONS/REVISIONS

CONTRACT DRAWINGS



APPROVED BY: A.MAR
C.O. CORP. W. EDG
C.D. W. EDG
CHECKED BY: D.LAR
DATE: 05-21
APPROVED BY: D.THI
DATE: 05-21
PROJECT NO: 14206B

CITY OF ROCHESTER, NEW HAMPSHIRE
ROUTE 202A WATER MAIN EXTENSION &
WATER STORAGE TANK
ROCHESTER, NEW HAMPSHIRE

PLAN AND PROFILE XVII
WINKLEY FARM LANE
STA. 333+00 TO STA. 345+00

WRIGHT-PIERCE
Engineering a Better Environment
888.621.8156 | www.wright-pierce.com

DRAWING
C-20

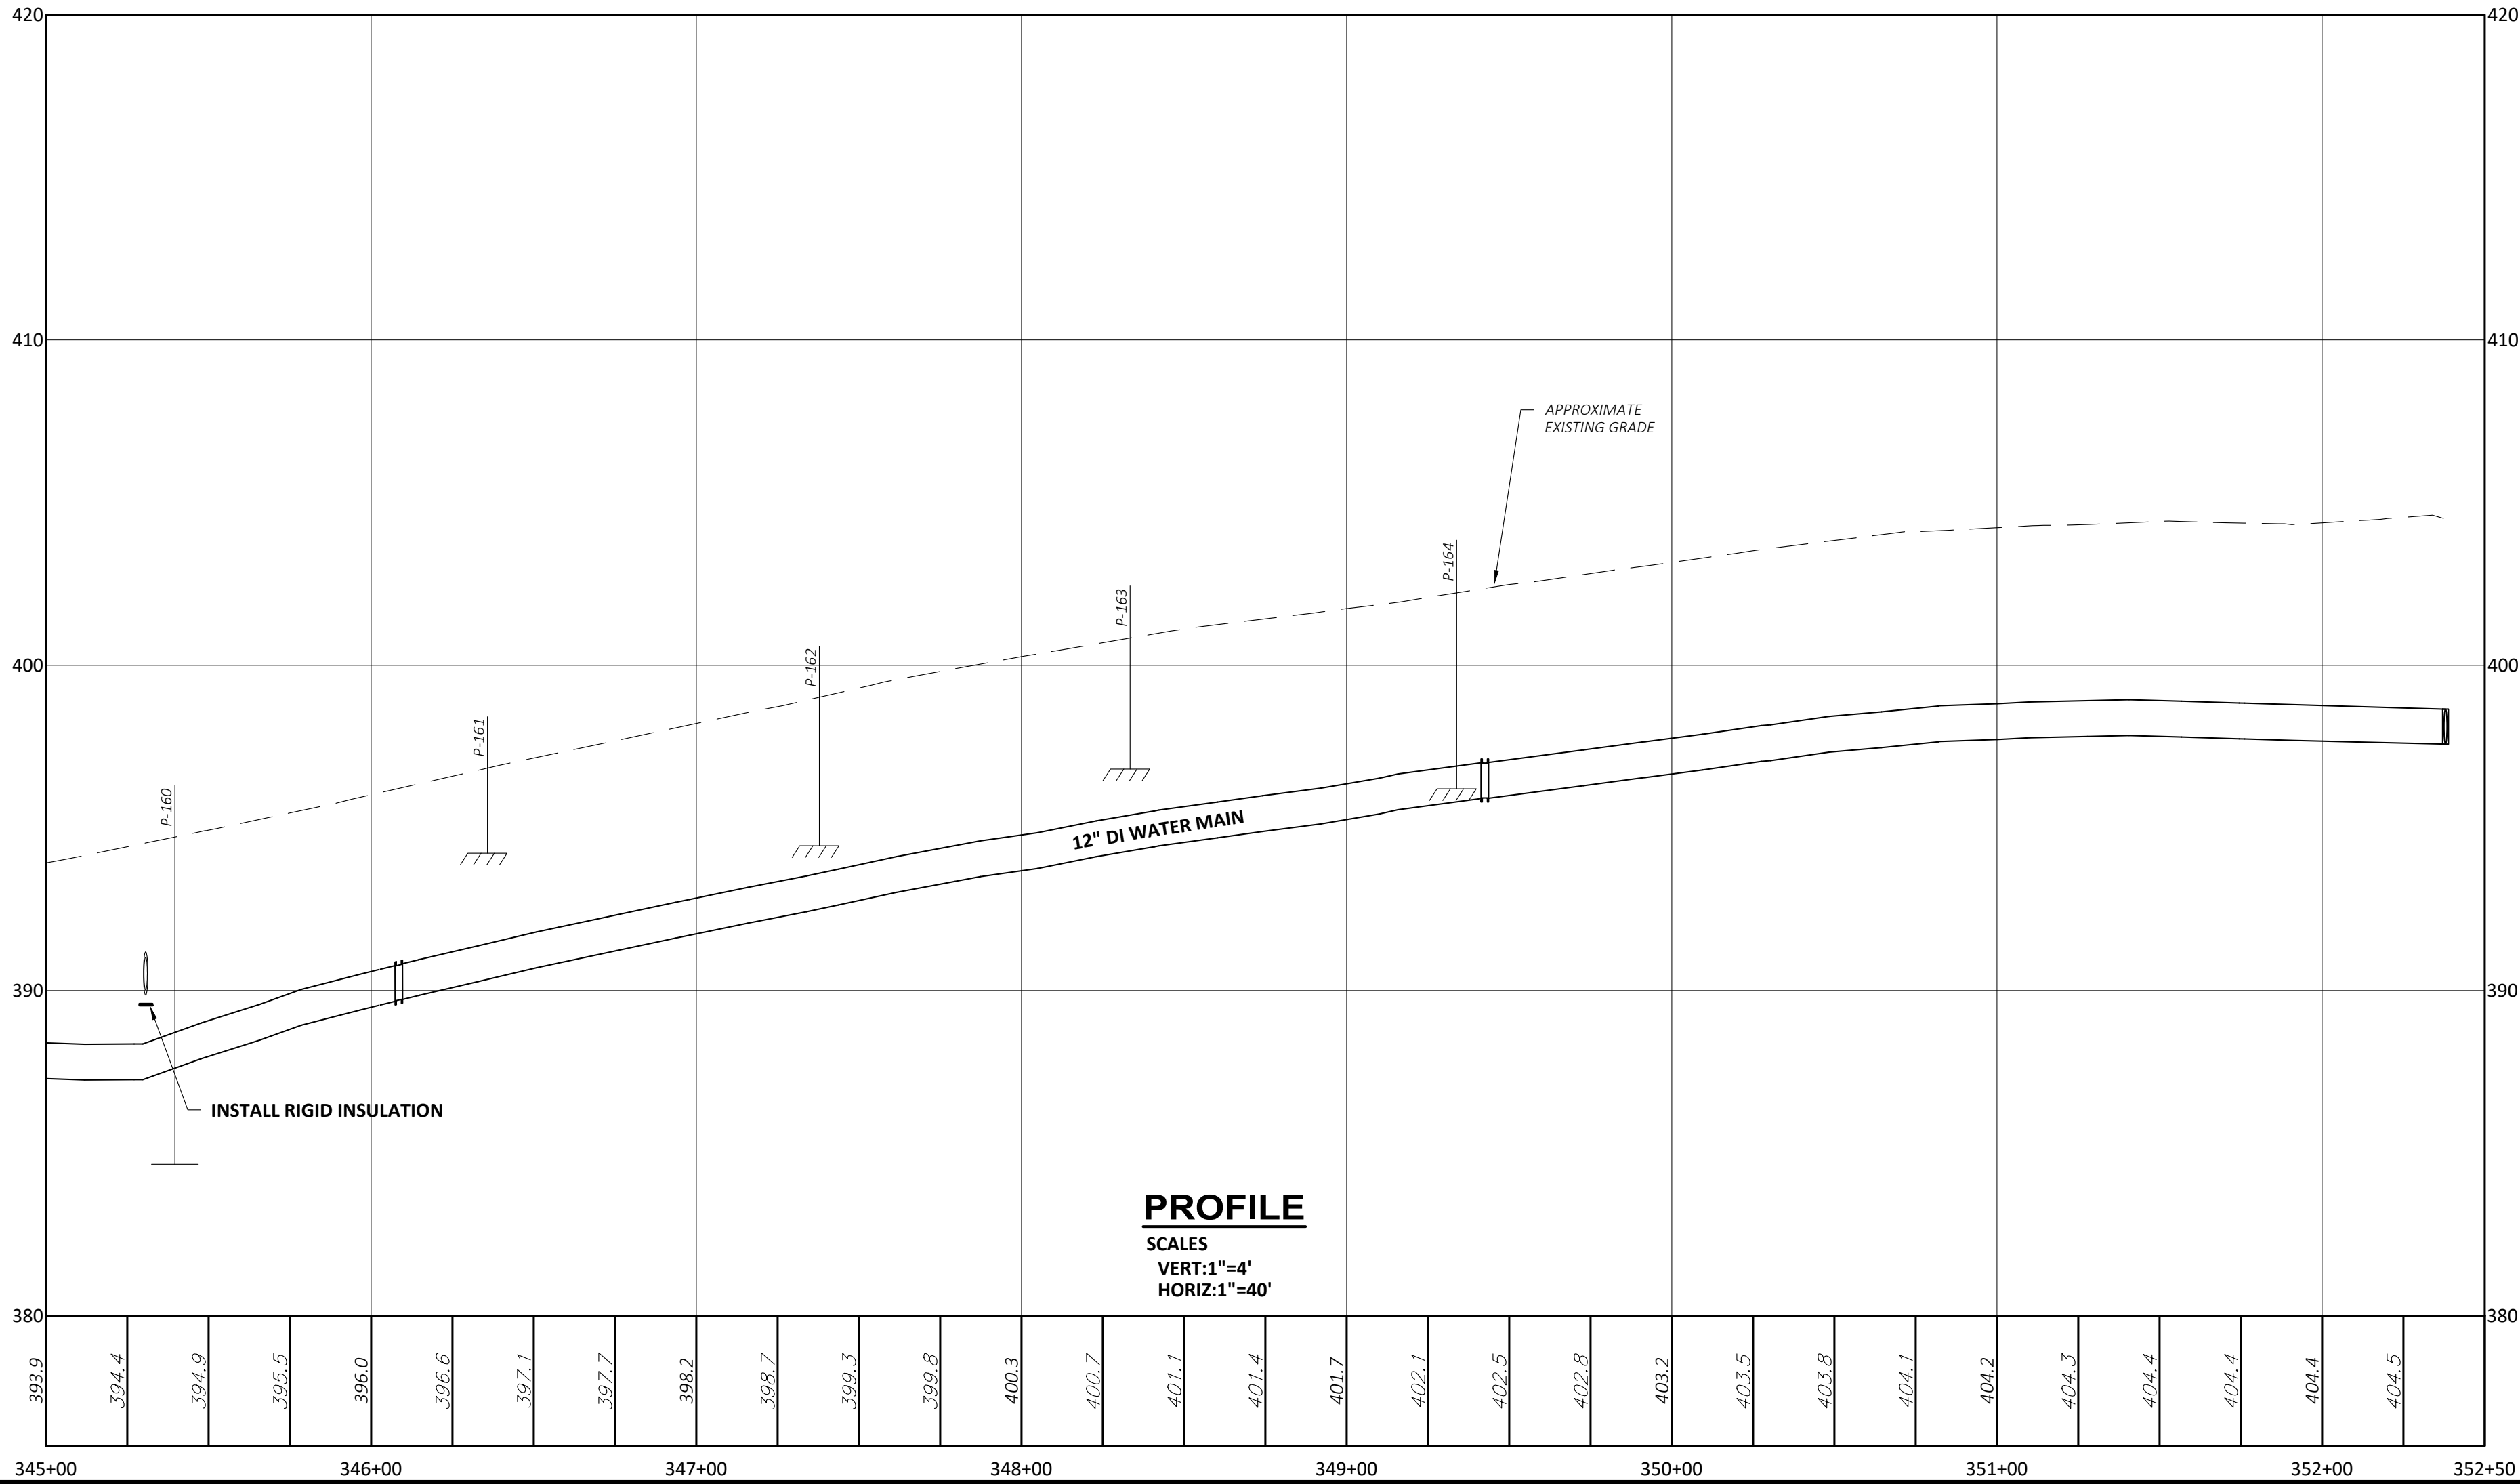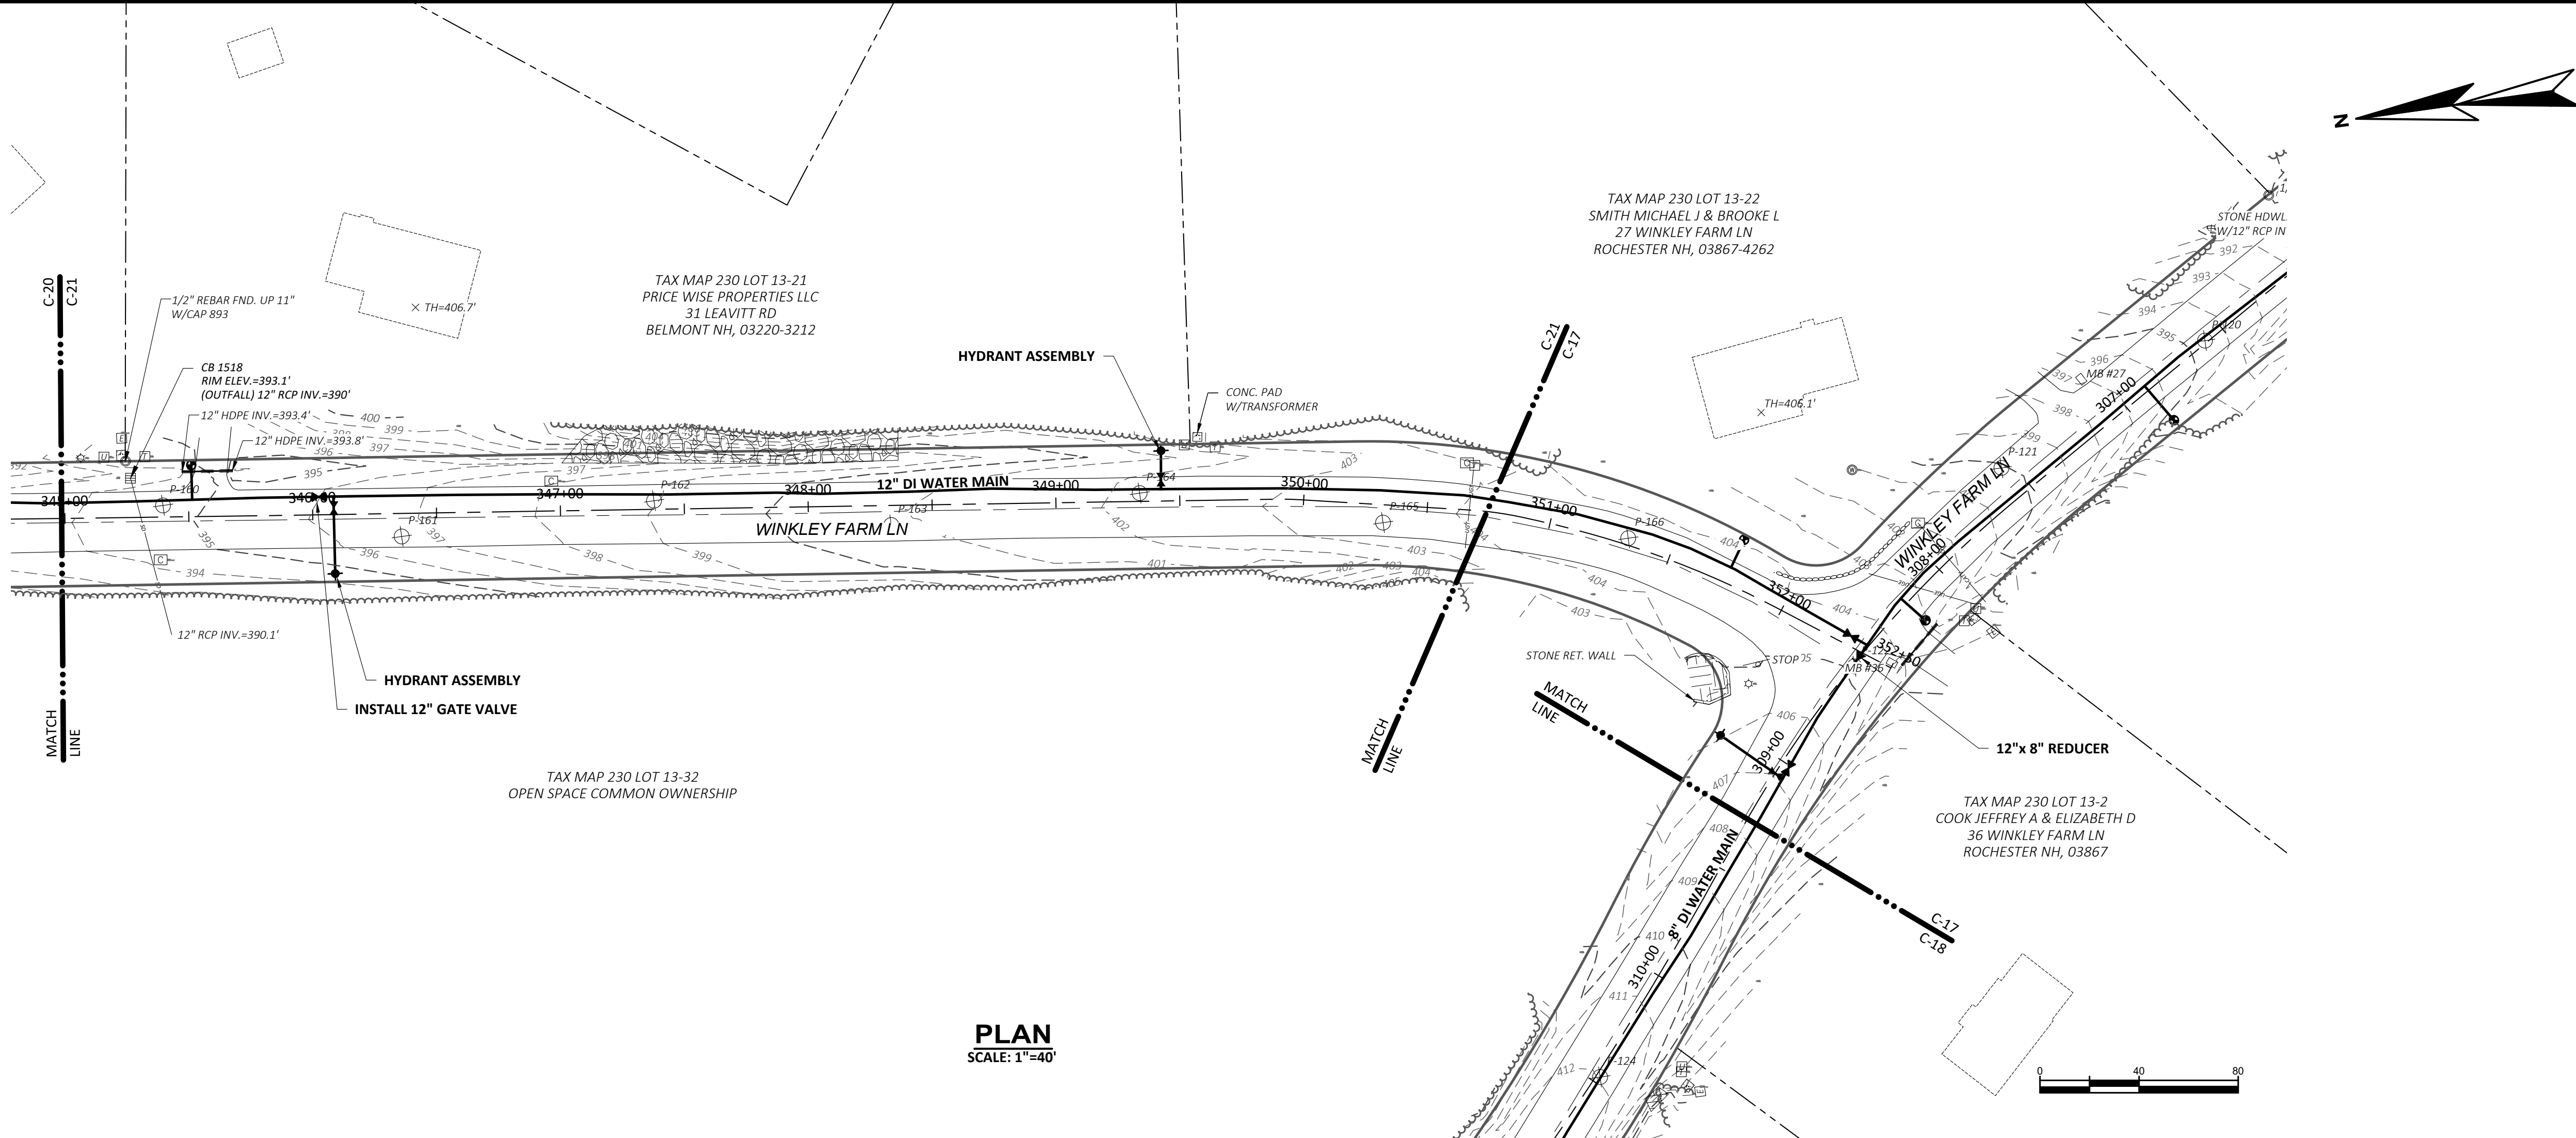

CITY OF ROCHESTER, NEW HAMPSHIRE ROUTE 202A WATER MAIN EXTENSION & WATER STORAGE TANK ROCHESTER, NEW HAMPSHIRE		DRAWING C-21	
PLAN AND PROFILE XIX WINKLEY FARM LANE STA. 345+00 TO STA. 352+50		WRIGHT-PIERCE Engineering a Better Environment 888.621.8156 www.wright-pierce.com	
DESIGNED BY: A.MAR C&D CORP.: W.EDG C&D: W.EDG CHECKED BY: D.LAR DATE: 05-21 APPROVED BY: D.THI DATE: 05-21 PROJECT NO.: 14206B		SUBMISSIONS/REVISIONS NO CONTRACT DRAWINGS	
APP'D DATE D.THI 08-21		NO CONTRACT DRAWINGS	

COPYRIGHTS REFERENCE CHANGES NOVEMBER 2021. THE CONTRACTOR REFERENCE DOCUMENTS HAVE BEEN REVIEWED TO INCORPORATE CLARIFICATIONS AND FOR DRAWING AND SPECIFICATION CHANGES FROM THE PROJECT DESIGNER IN ORDER TO CLARIFY AND ACCURATELY DETERMINE THE CLARIFICATIONS CHANGES FOR CONFORMANCE AND REFERENCE. THE EXISTING CONTRACT DOCUMENTS, INCLUDING THE BASIS FOR BID DRAWINGS AND SPECIFICATIONS, AND ANY SUBSEQUENT ADDENDUMS SHALL BE THE BASIS FOR ALL ACCEPTED WORK UNDER THIS CONTRACT.